


F.A.I. RTE.	SECTION	COUNTY	TOTAL SHEETS	SHEET NO.
255	•	MADISON	4	3
STA.		TO STA.		
FED. ROAD DIST. NO.	ILLINOIS	FED. AID PROJECT		

• DIST 8 DEEP WELLS 2007-2

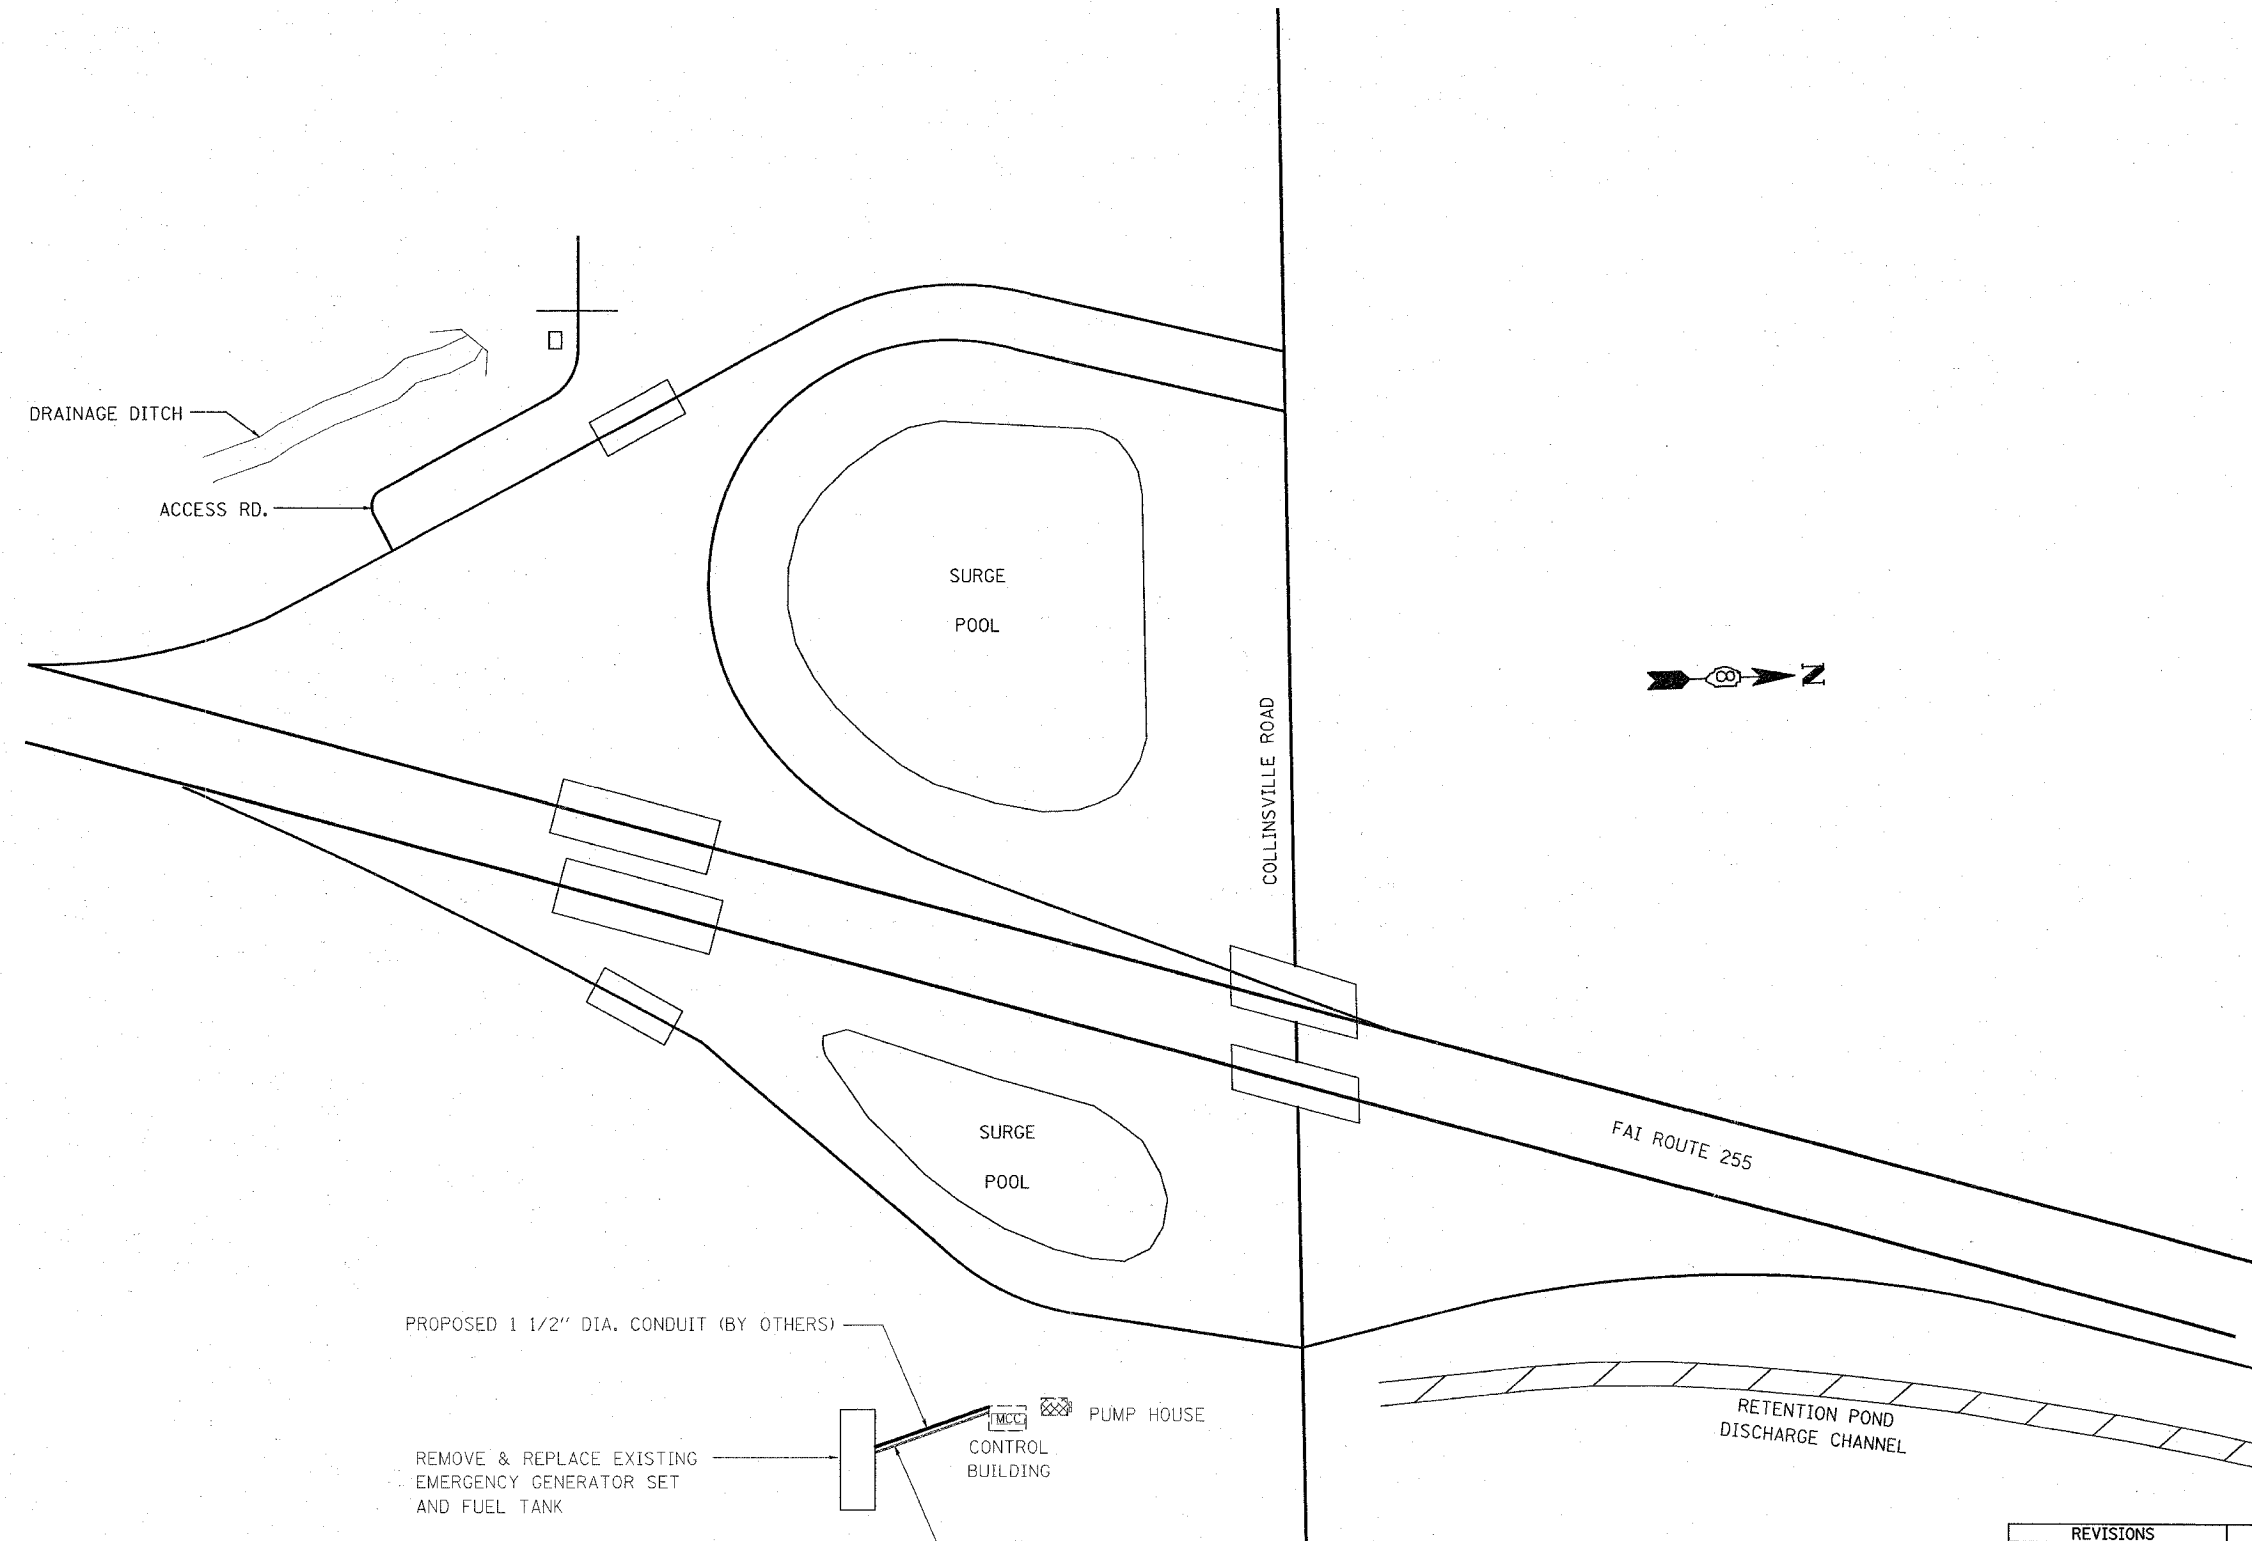

PROPOSED 1 1/2" DIA. CONDUIT (BY OTHERS)

REMOVE & REPLACE EXISTING EMERGENCY GENERATOR SET AND FUEL TANK



EXISTING 3" DIA. GSC CONDUIT. REMOVE EXISTING CABLES. INSTALL PROPOSED 3-1/C, 500 MCM AND 1/C- #1/0 GROUND CABLES FROM GENERATOR BREAKER TO EXISTING MCC (400 AMP GENERATOR BREAKER)

REVISIONS	
NAME	DATE

ILLINOIS DEPARTMENT OF TRANSPORTATION  
**SITE PLAN LAYOUT**  
 FAI ROUTE 255  
 SECTION DIST 8 DEEP WELLS 2007-2  
 MADISON COUNTY

SCALE: VERT. \_\_\_\_\_  
 HORIZ. \_\_\_\_\_  
 DATE \_\_\_\_\_

DRAWN BY \_\_\_\_\_  
 CHECKED BY \_\_\_\_\_

PLOT DATE = #DATE#  
 FILE NAME = #FILE#  
 PLOT SCALE = #SCALE#  
 REFERENCE = #REF#