

F.A. DIST.	SECTION	COUNTY	TOTAL SHEETS	SHEET NO.
2585/97-00071-00-PV		COOK	116	27
STA.	TO STA.			
FED. ROAD DIST. NO.	ILLINOIS	FED. AID PROJECT		



DATE	BY
DATE	BY

CHRISTOPHER B. BURKE ENGINEERING LTD.  
 9575 West Higgins Road, Suite 600  
 Rosemont, Illinois 60018  
 (847) 823-0500



DATE	BY
DATE	BY

PROFILE SUBMITTED  
 SCALE CHECKED  
 DATE NOTED  
 STRUCTURE NOTING OK

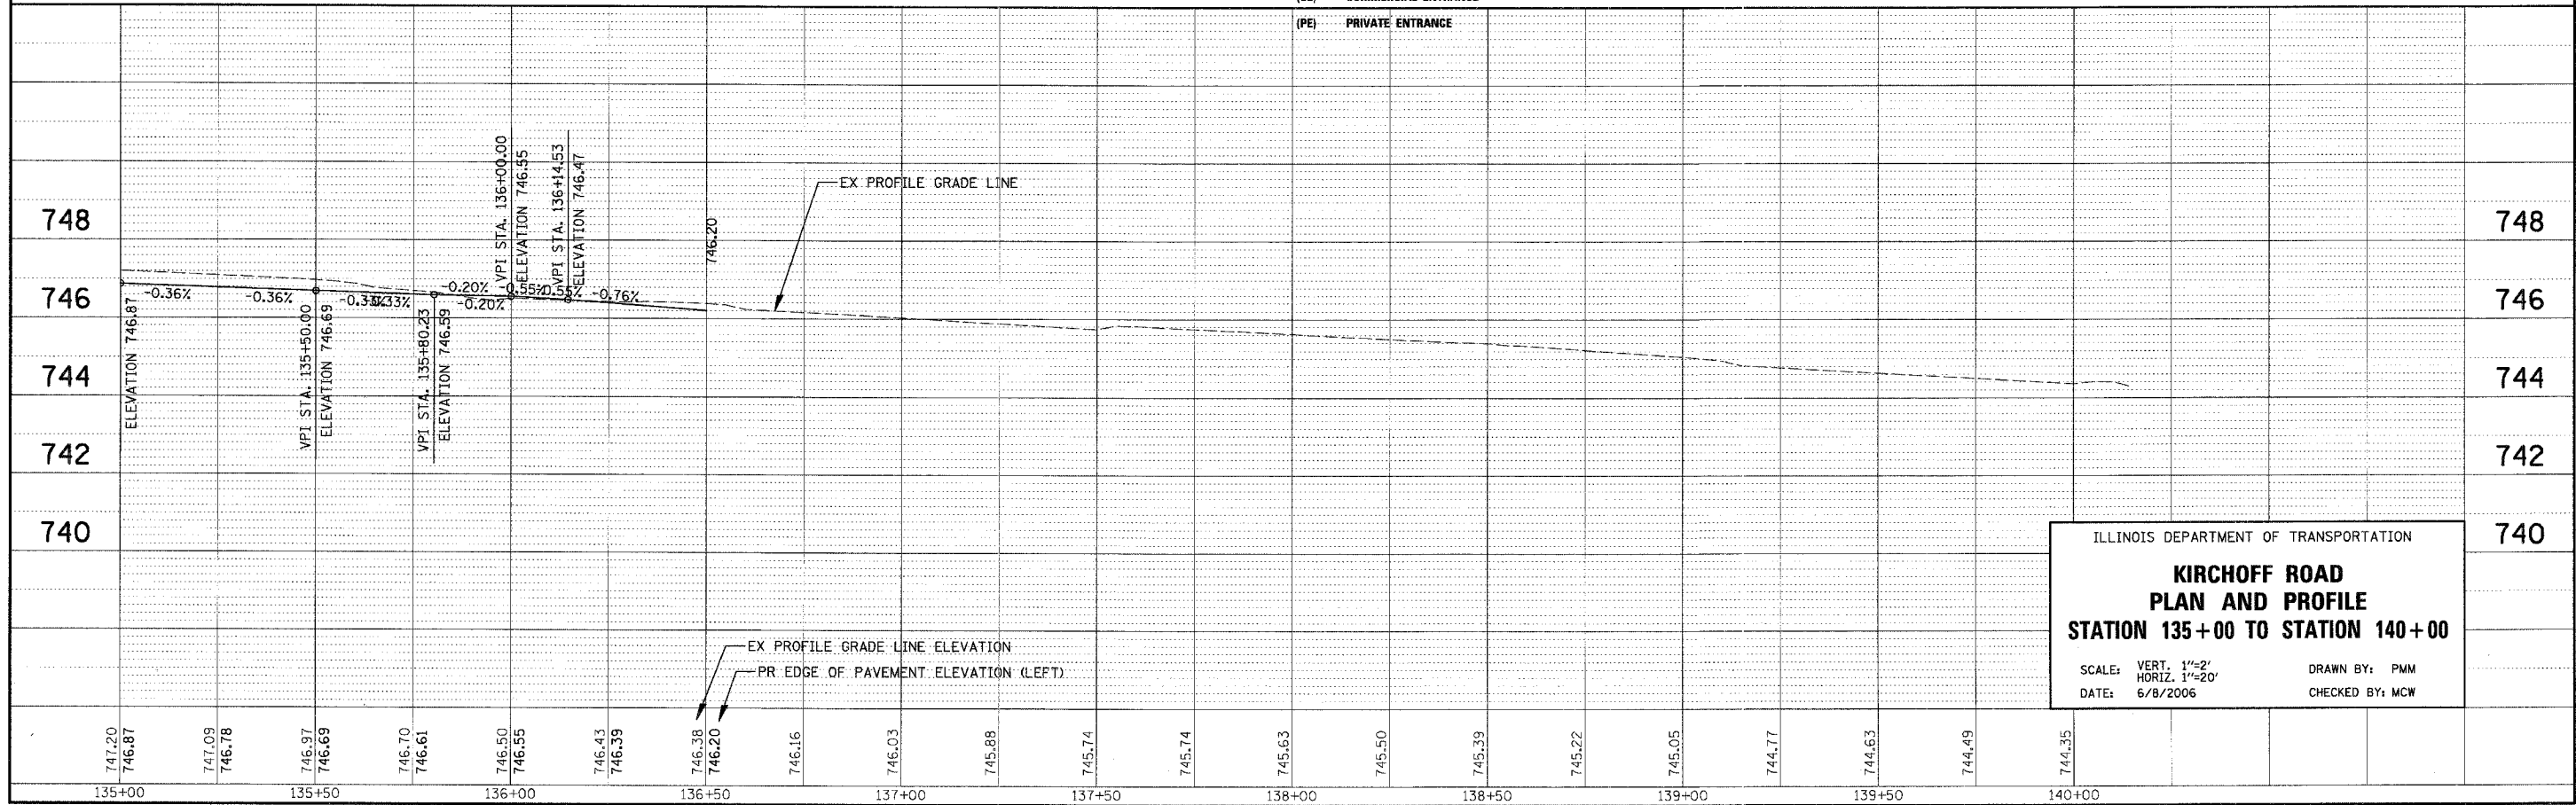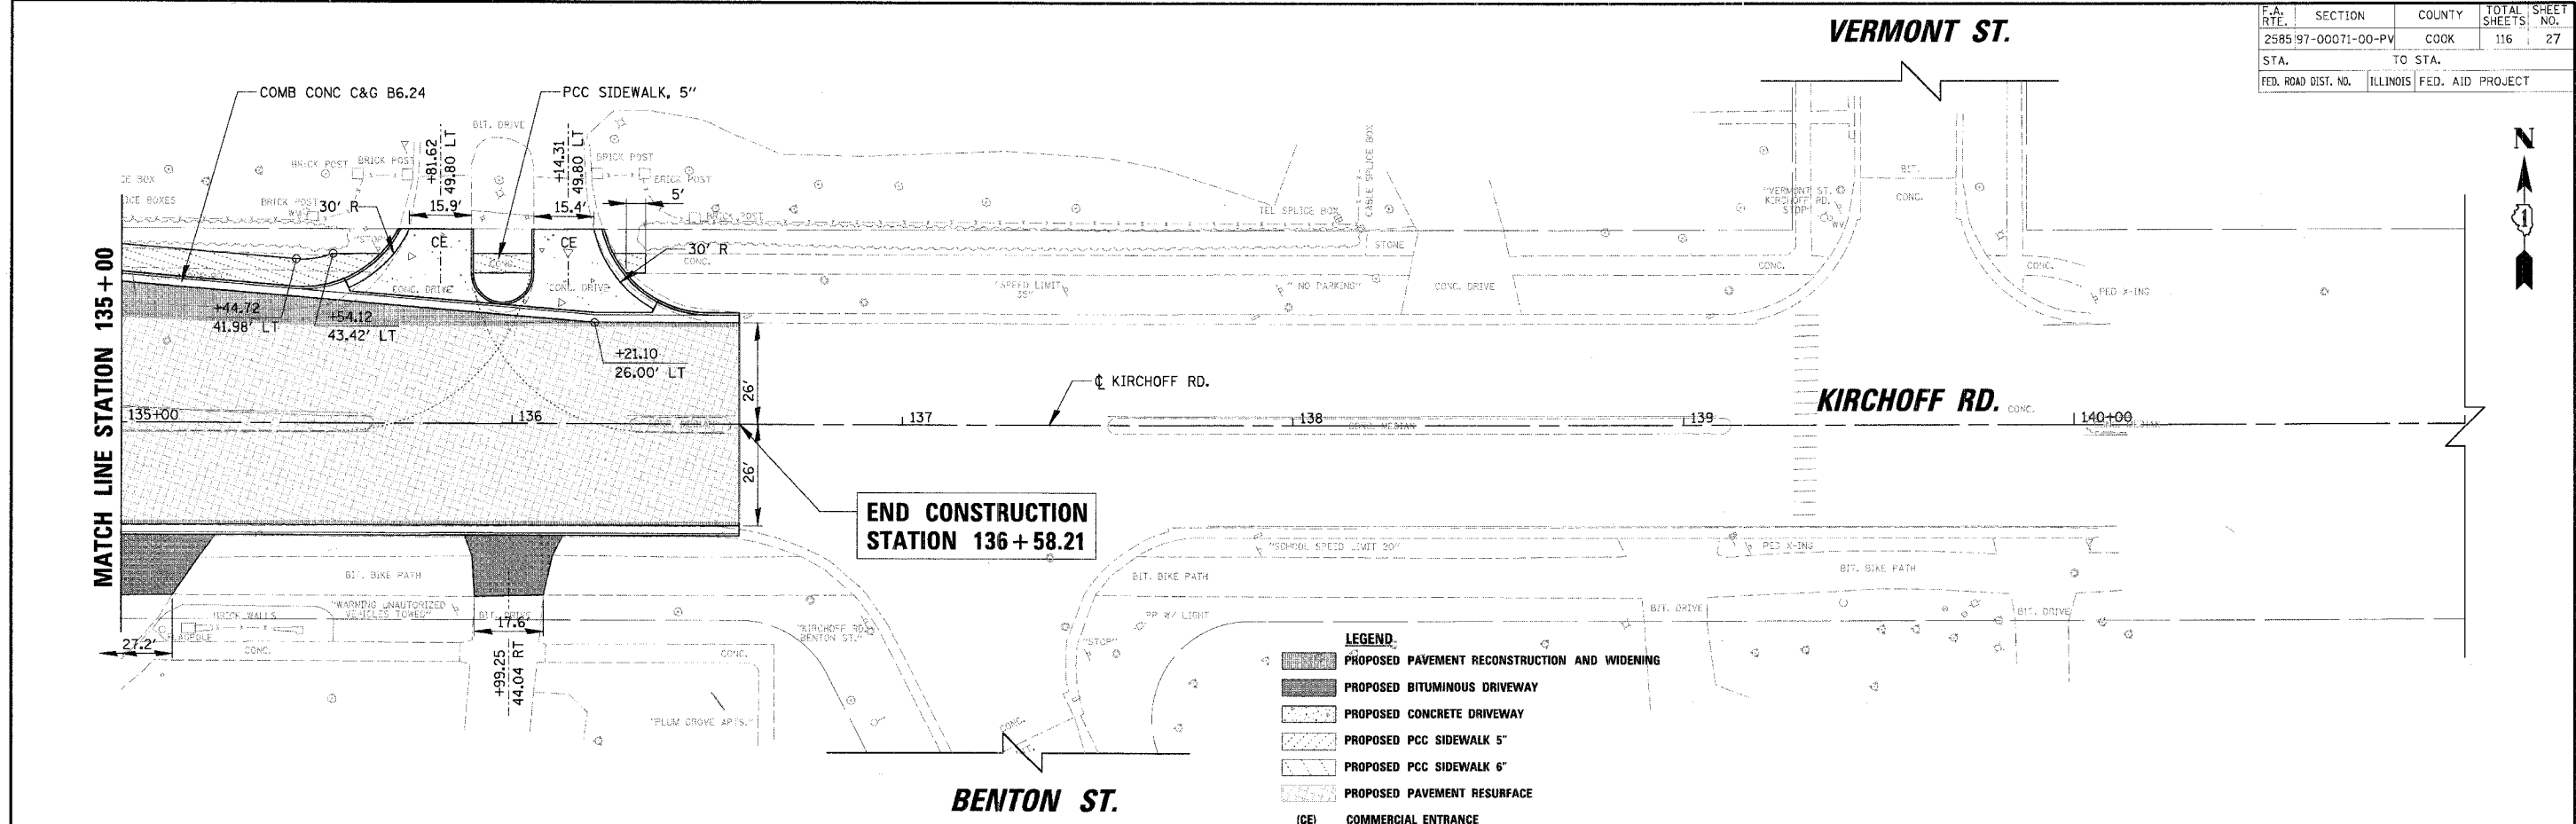

ILLINOIS DEPARTMENT OF TRANSPORTATION  
**KIRCHOFF ROAD  
 PLAN AND PROFILE  
 STATION 135+00 TO STATION 140+00**  
 SCALE: VERT. 1"=2'  
 HORIZ. 1"=20'  
 DATE: 6/8/2006  
 DRAWN BY: PMM  
 CHECKED BY: MCW