 



F.A. RTE.	SECTION	COUNTY	TOTAL SHEET NO.
2585	97-00071-00-PV	COOK	116 48
STA.	TO STA.		
FED. ROAD DIST. NO.	ILLINOIS	FED. AID PROJECT	




MATCH LINE STATION 135 + 00

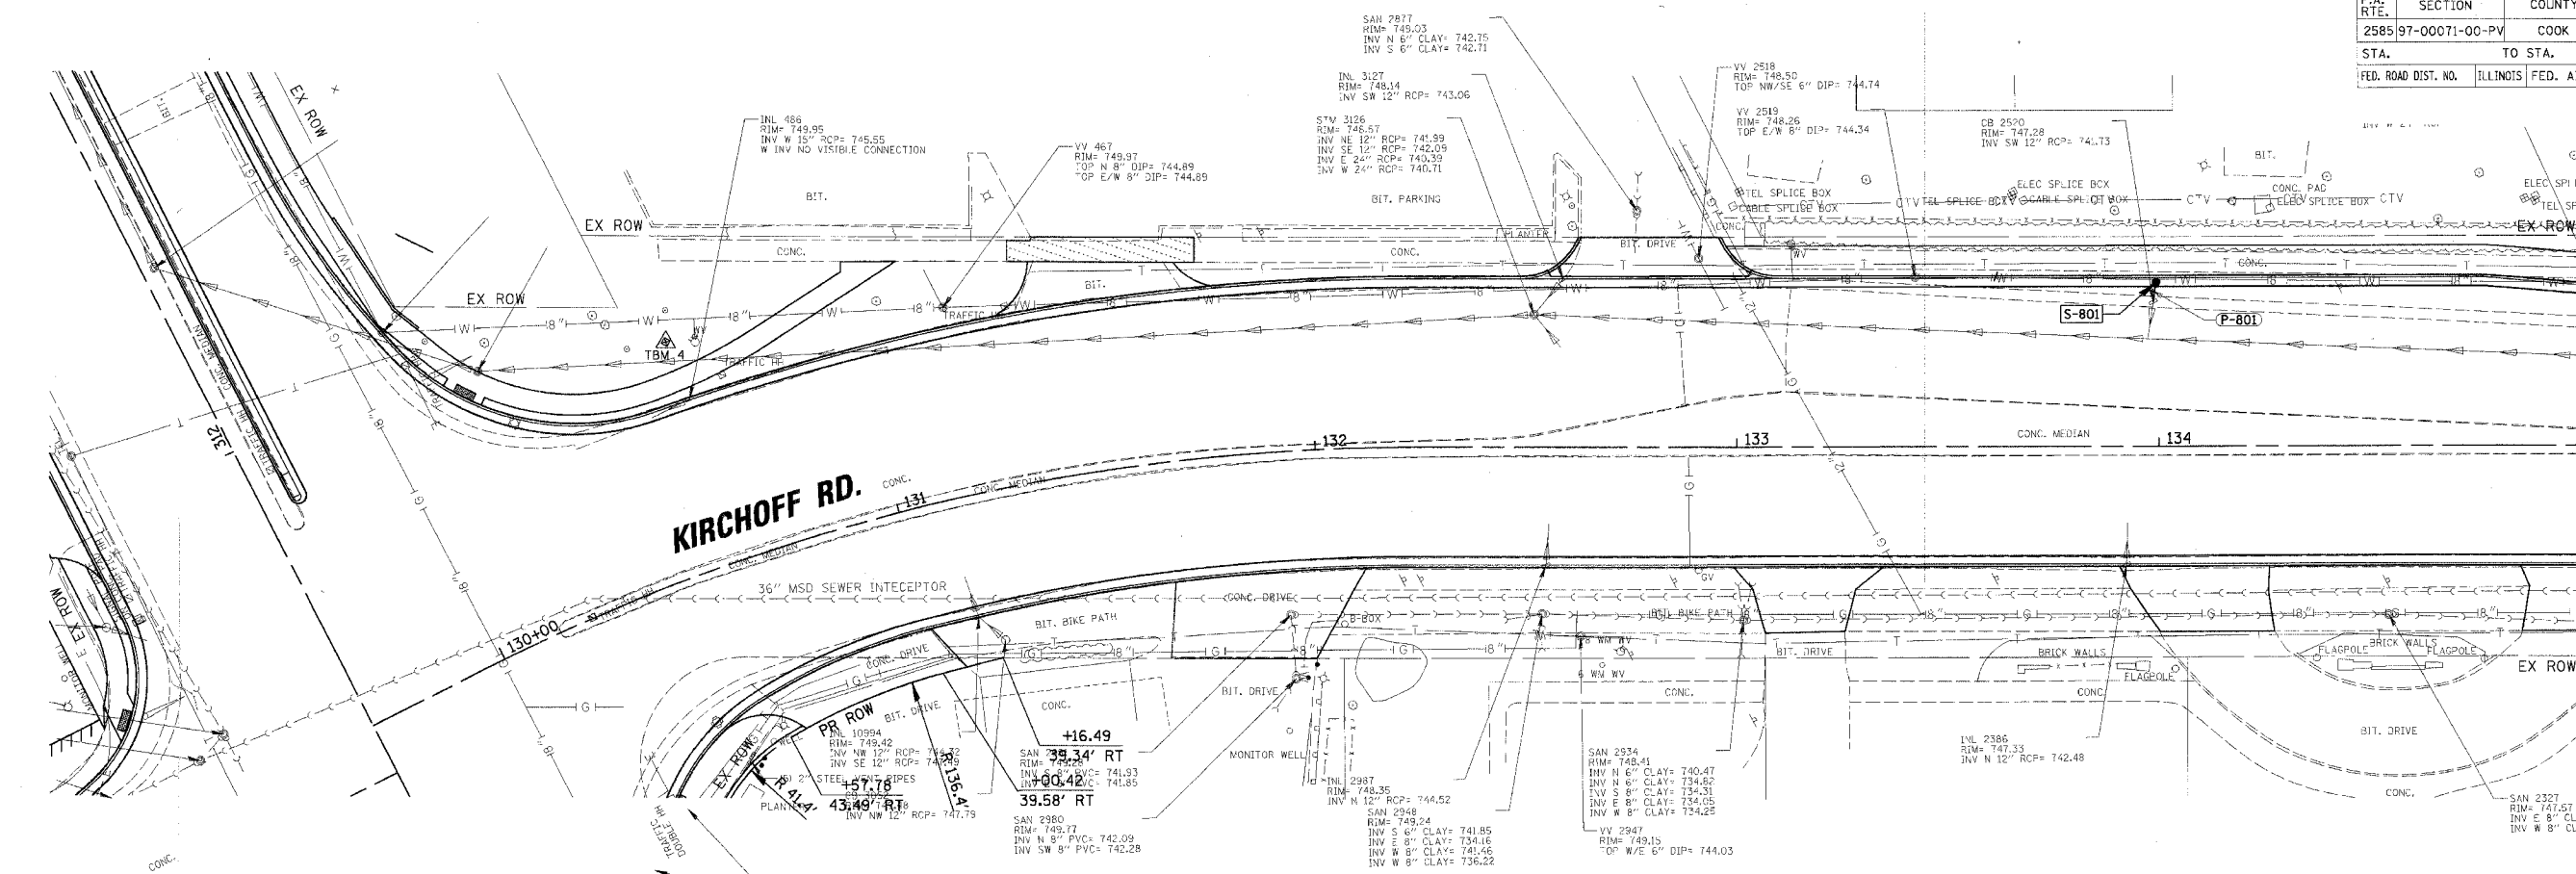

STRUCTURE NO.	STATION	OFFSET	STRUCTURE TYPE	DIA.(FT.)	RIM ELEV.	N	S	E	W
S-801	134+00	38.00' LT	CB TC T24F&G	2	747.25		741.78		

PIPE NO.	STRUCTURE	FROM	TO	STRUCTURE	MATERIAL	TYPE	LENGTH (FT)	DIA. (IN)	UPPER INVERT	LOWER INVERT	SLOPE	TBF
P-801	S-801				ex-pipe	RCP	5	12	741.78	741.59	1.00	3.00

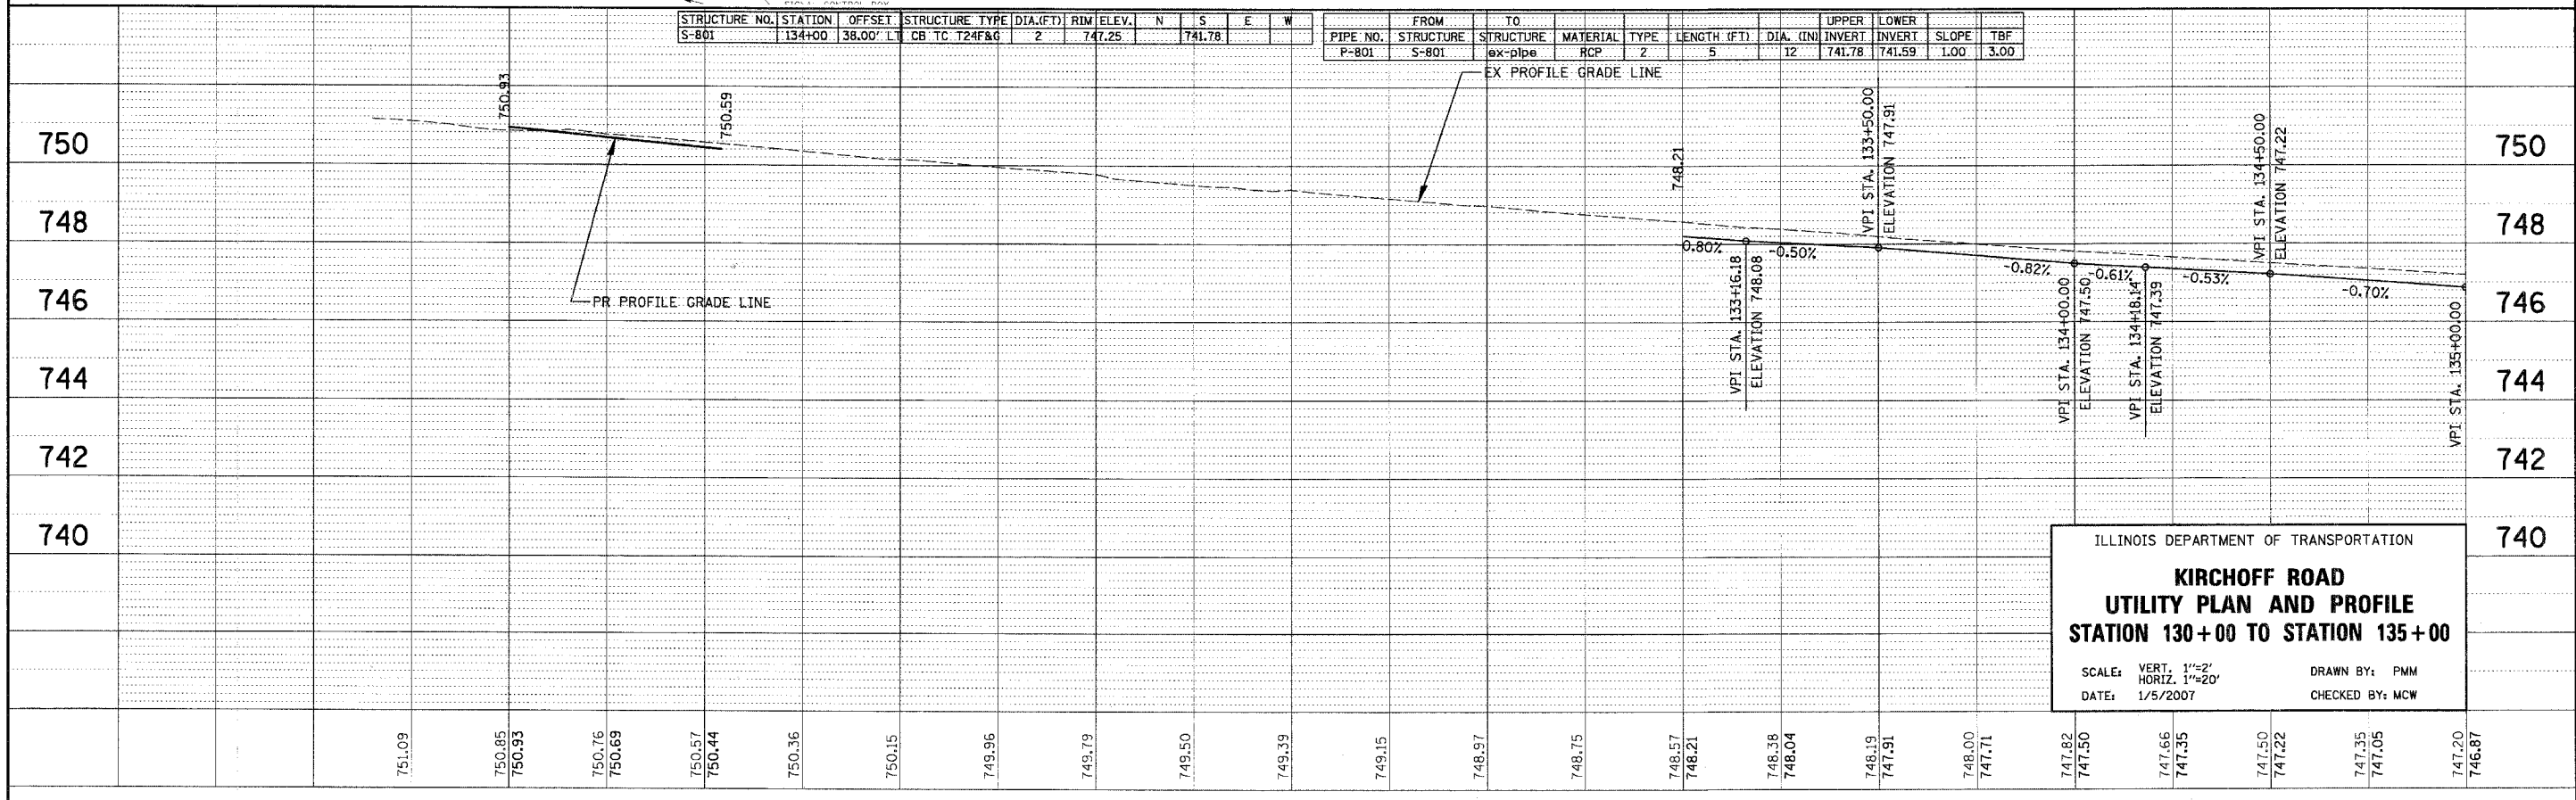

ILLINOIS DEPARTMENT OF TRANSPORTATION
KIRCHOFF ROAD
UTILITY PLAN AND PROFILE
STATION 130+00 TO STATION 135+00

SCALE: VERT. 1"=2'
 HORIZ. 1"=20'
 DATE: 1/5/2007
 DRAWN BY: PMM
 CHECKED BY: MCW

PLAN SUBMITTED BY: [blank]
 DATE: [blank]
 CHECKED BY: [blank]
 DATE: [blank]
 NO. [blank]

CHRISTOPHER B. BURKE ENGINEERING LTD.
 9575 West Higgins Road, Suite 600
 Rosemont, Illinois 60018
 (847) 823-0500

PROFILE SUBMITTED BY: [blank]
 DATE: [blank]
 CHECKED BY: [blank]
 DATE: [blank]
 NO. [blank]