 



CONTRACT NO. #83853

F.A. RTE.	SECTION	COUNTY	TOTAL SHEETS	SHEET NO.
2585	97-00071-00-PV	COOK	116	54
STA.	TO STA.			
FED. ROAD DIST. NO.	ILLINOIS FED. AID PROJECT			




**BEGIN IMPROVEMENT
STATION 300+25**

- LEGEND:**
- SILT FENCE
 - INLET AND PIPE PROTECTION
 - INLET FILTER
 - SODDING
 - DITCH CHECK

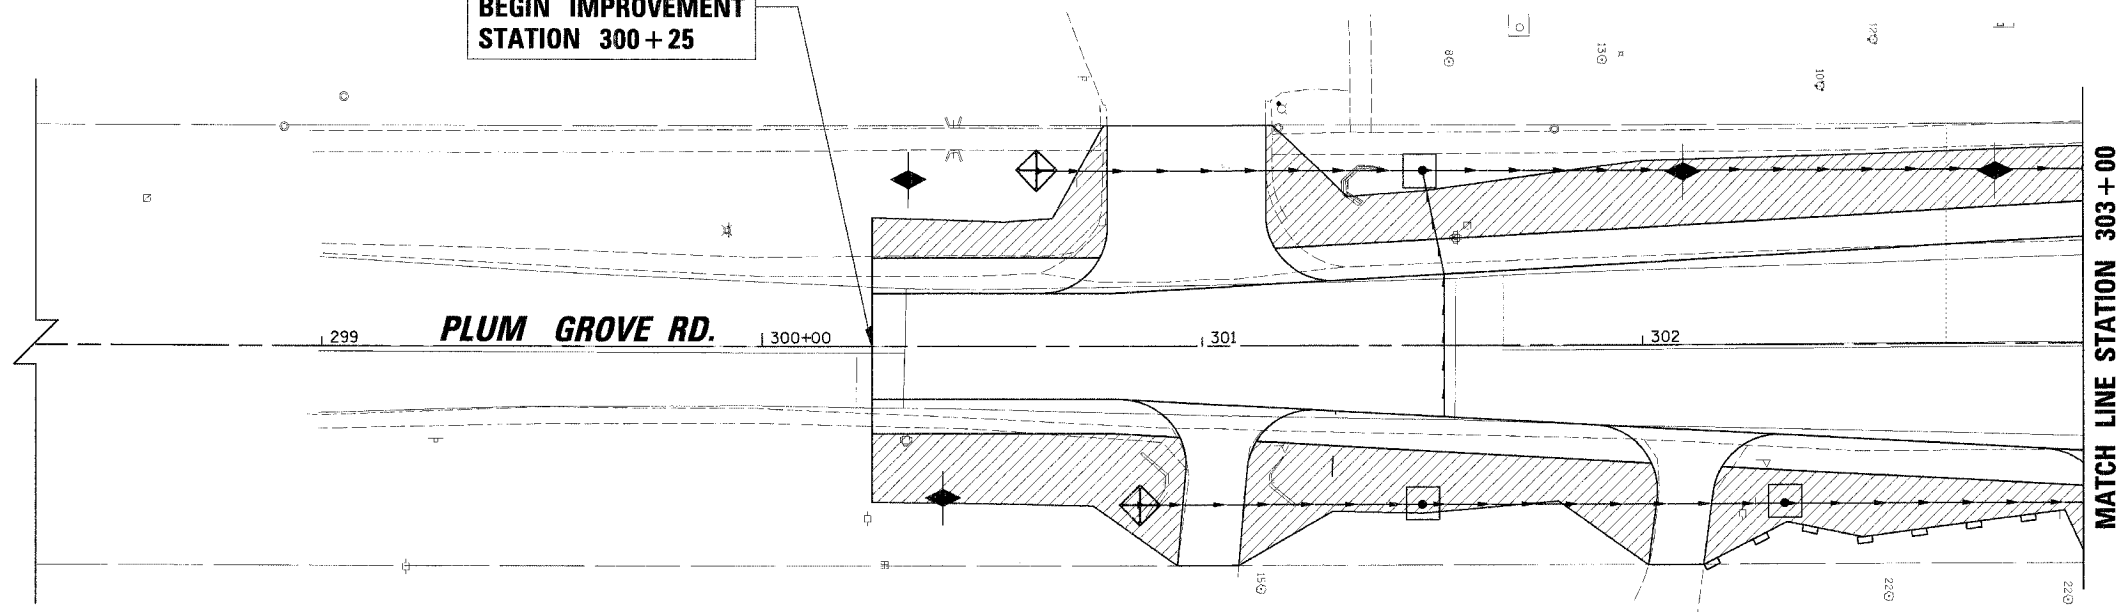

EMERSON AVE.

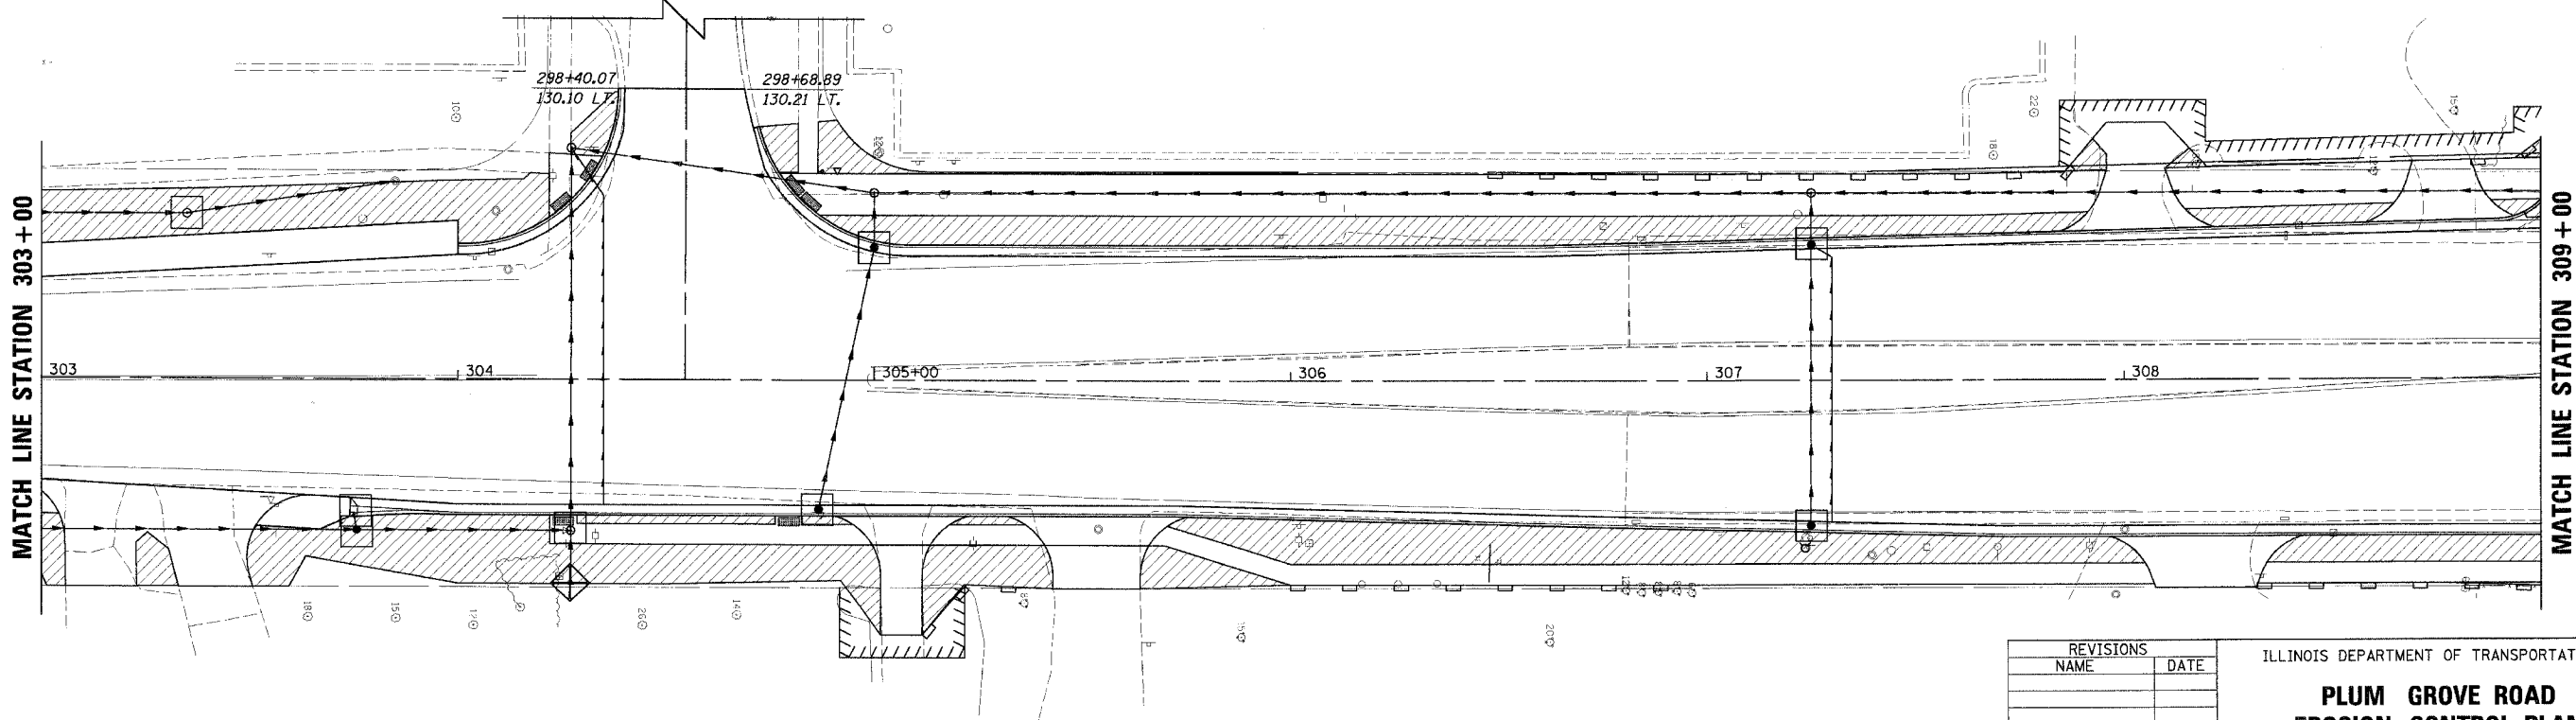

DATE	BY
PLAN	
NOTE BOOK	
NO.	

CHRISTOPHER B. BURKE ENGINEERING LTD.
 9875 West Higgins Road, Suite 600
 Rosemont, Illinois 60018
 (847) 823-0500

DATE	BY
PROFILE	
NOTE BOOK	
NO.	

REVISIONS	
NAME	DATE

ILLINOIS DEPARTMENT OF TRANSPORTATION
**PLUM GROVE ROAD
 EROSION CONTROL PLAN
 STATION 300+25 TO STATION 309+00**

SCALE: 20'
 DATE: 6/8/2006
 DRAWN BY: PMM
 CHECKED BY: MCW

h:\olm\ms\98361br48\design\98361br48_plum237.ecp