


| F.A. RTE.           | SECTION        | COUNTY                    | TOTAL SHEETS | SHEET NO. |
|---------------------|----------------|---------------------------|--------------|-----------|
| M5<br>6600          | 05-00012-00-FF | HENRY                     | 75           | 51        |
| STA. 10+16.03       |                | TO STA. 16+00             |              |           |
| FED. ROAD DIST. NO. |                | ILLINOIS FED. AID PROJECT |              |           |

# LIGHTING PLANS

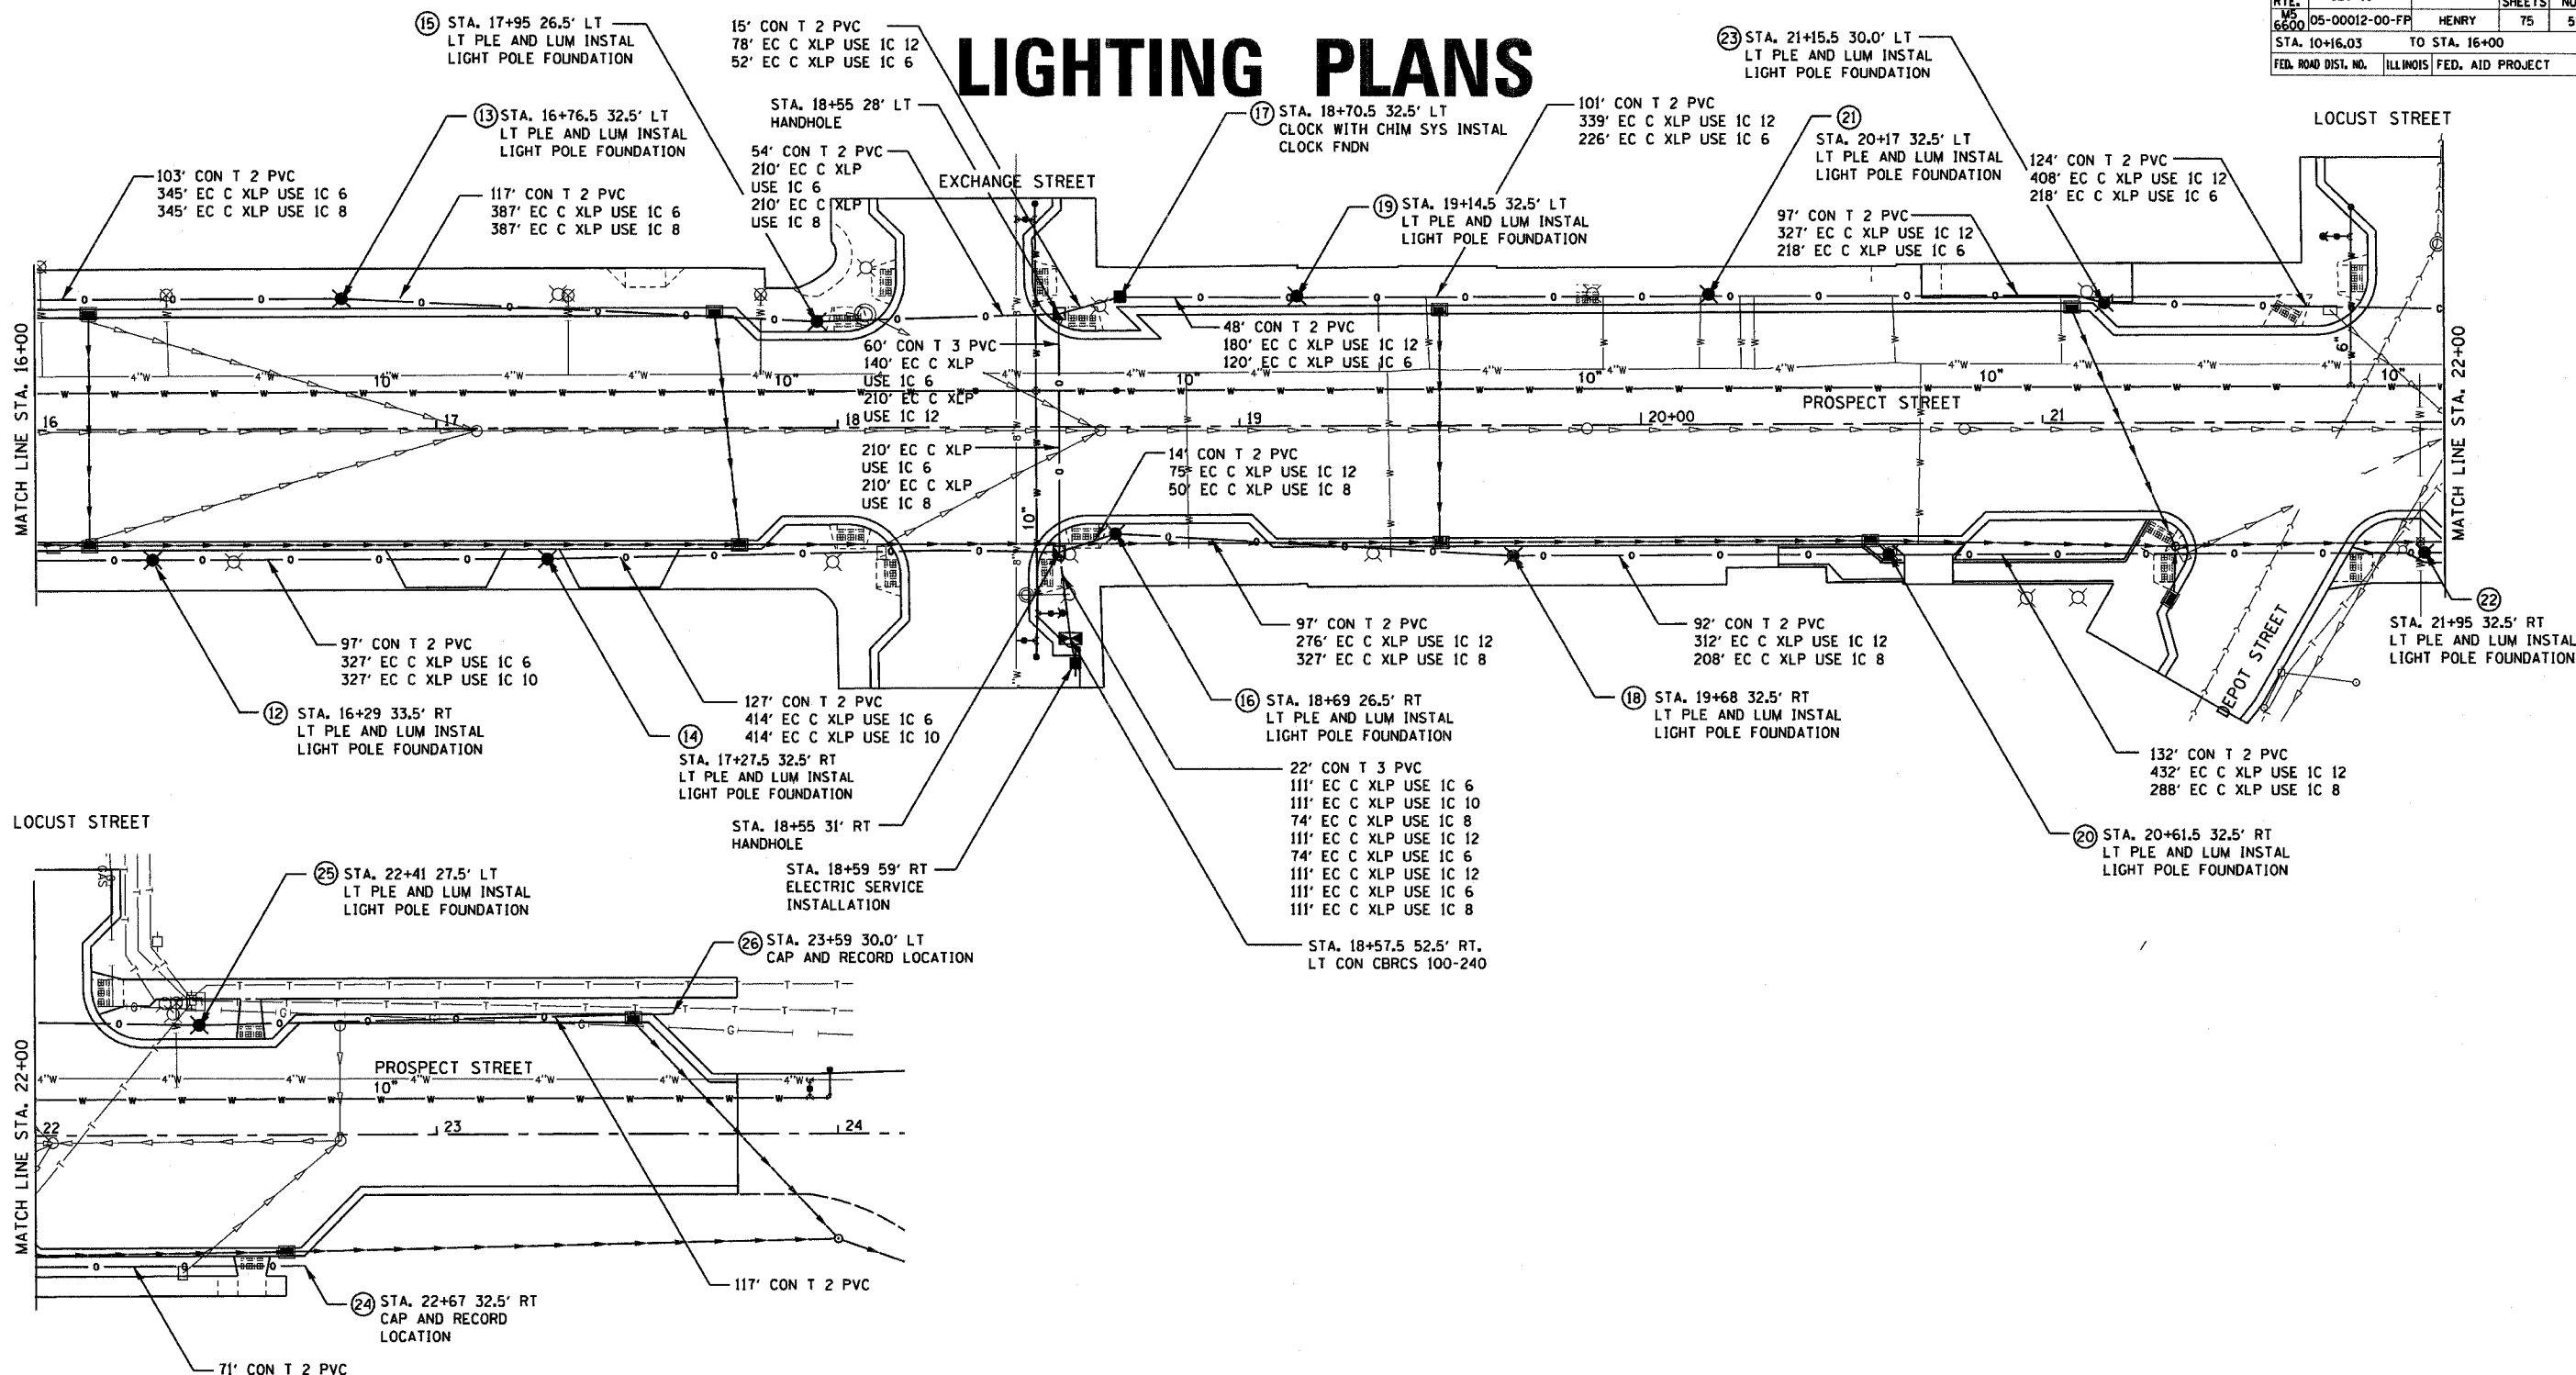

DATE: \_\_\_\_\_  
 FILE NAME: \_\_\_\_\_  
 PLOT SCALE: \_\_\_\_\_  
 USER NAME: \_\_\_\_\_

| REVISIONS |      | ILLINOIS DEPARTMENT OF TRANSPORTATION |
|-----------|------|---------------------------------------|
| NAME      | DATE |                                       |
|           |      |                                       |
|           |      |                                       |
|           |      |                                       |
|           |      |                                       |
|           |      |                                       |

|        |              |                |
|--------|--------------|----------------|
| SCALE: | VERT. _____  | DRAWN BY _____ |
| DATE:  | HORIZ. _____ |                |