




F.A.I.D. NO.	SECTION	COUNTY	TOTAL SHEETS	SHEET NO.
6998	99-00209-01-PV	VERMILION	296	80
STA. 139+00		TO STA. 145+00		
FED. ROAD DIST. NO. ILLINOIS		FED. AID PROJECT-		
CONTRACT NO.: 91358				

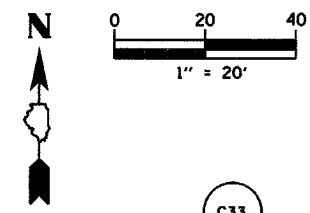

PLAN	SURVEYED	BY	DATE
	NOTED		
	CHECKED		
	RT. OF WAY CHECKED		
	NO. OF		
	NO.		

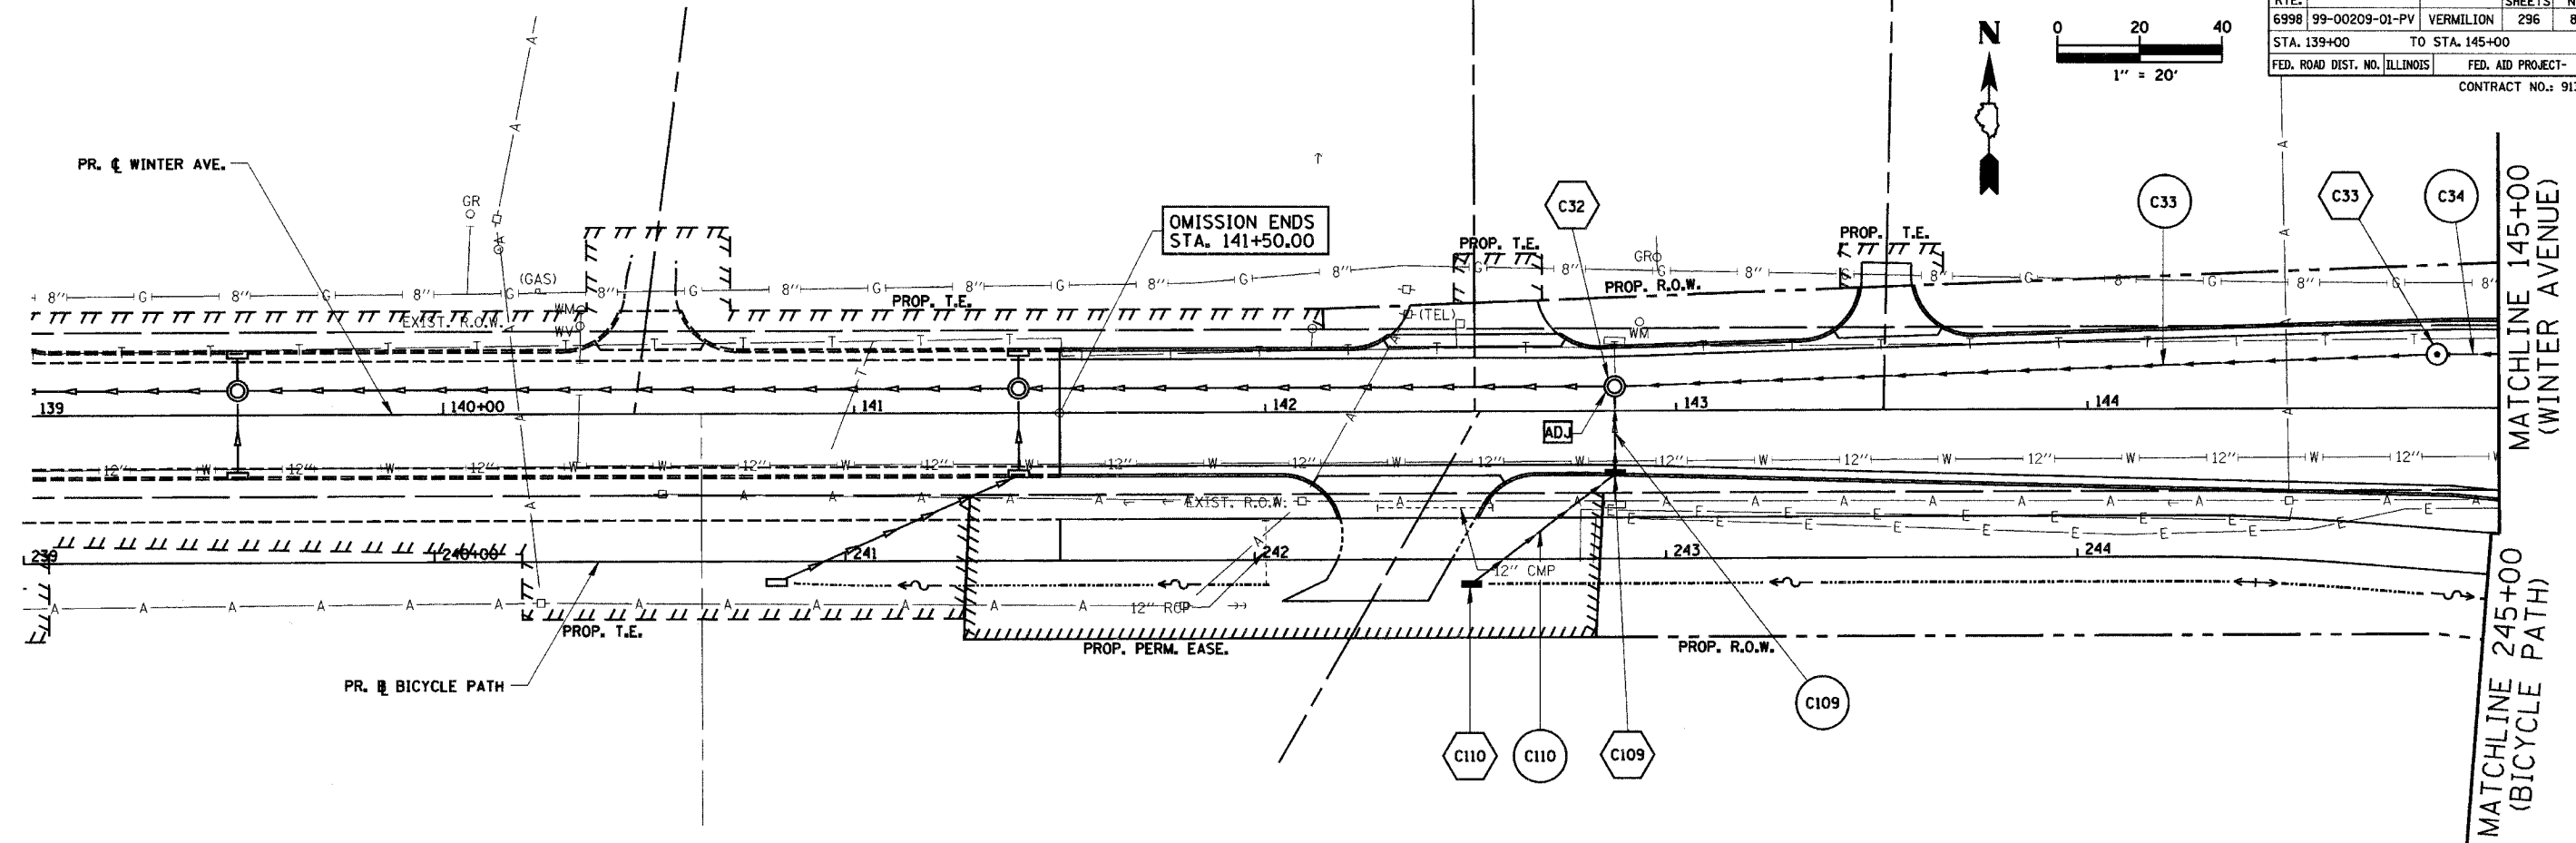

PROFILE	SURVEYED	BY	DATE
	NOTED		
	CHECKED		
	B.M. NOTED		
	STRUCTURE NOTATION		
	CHRD		

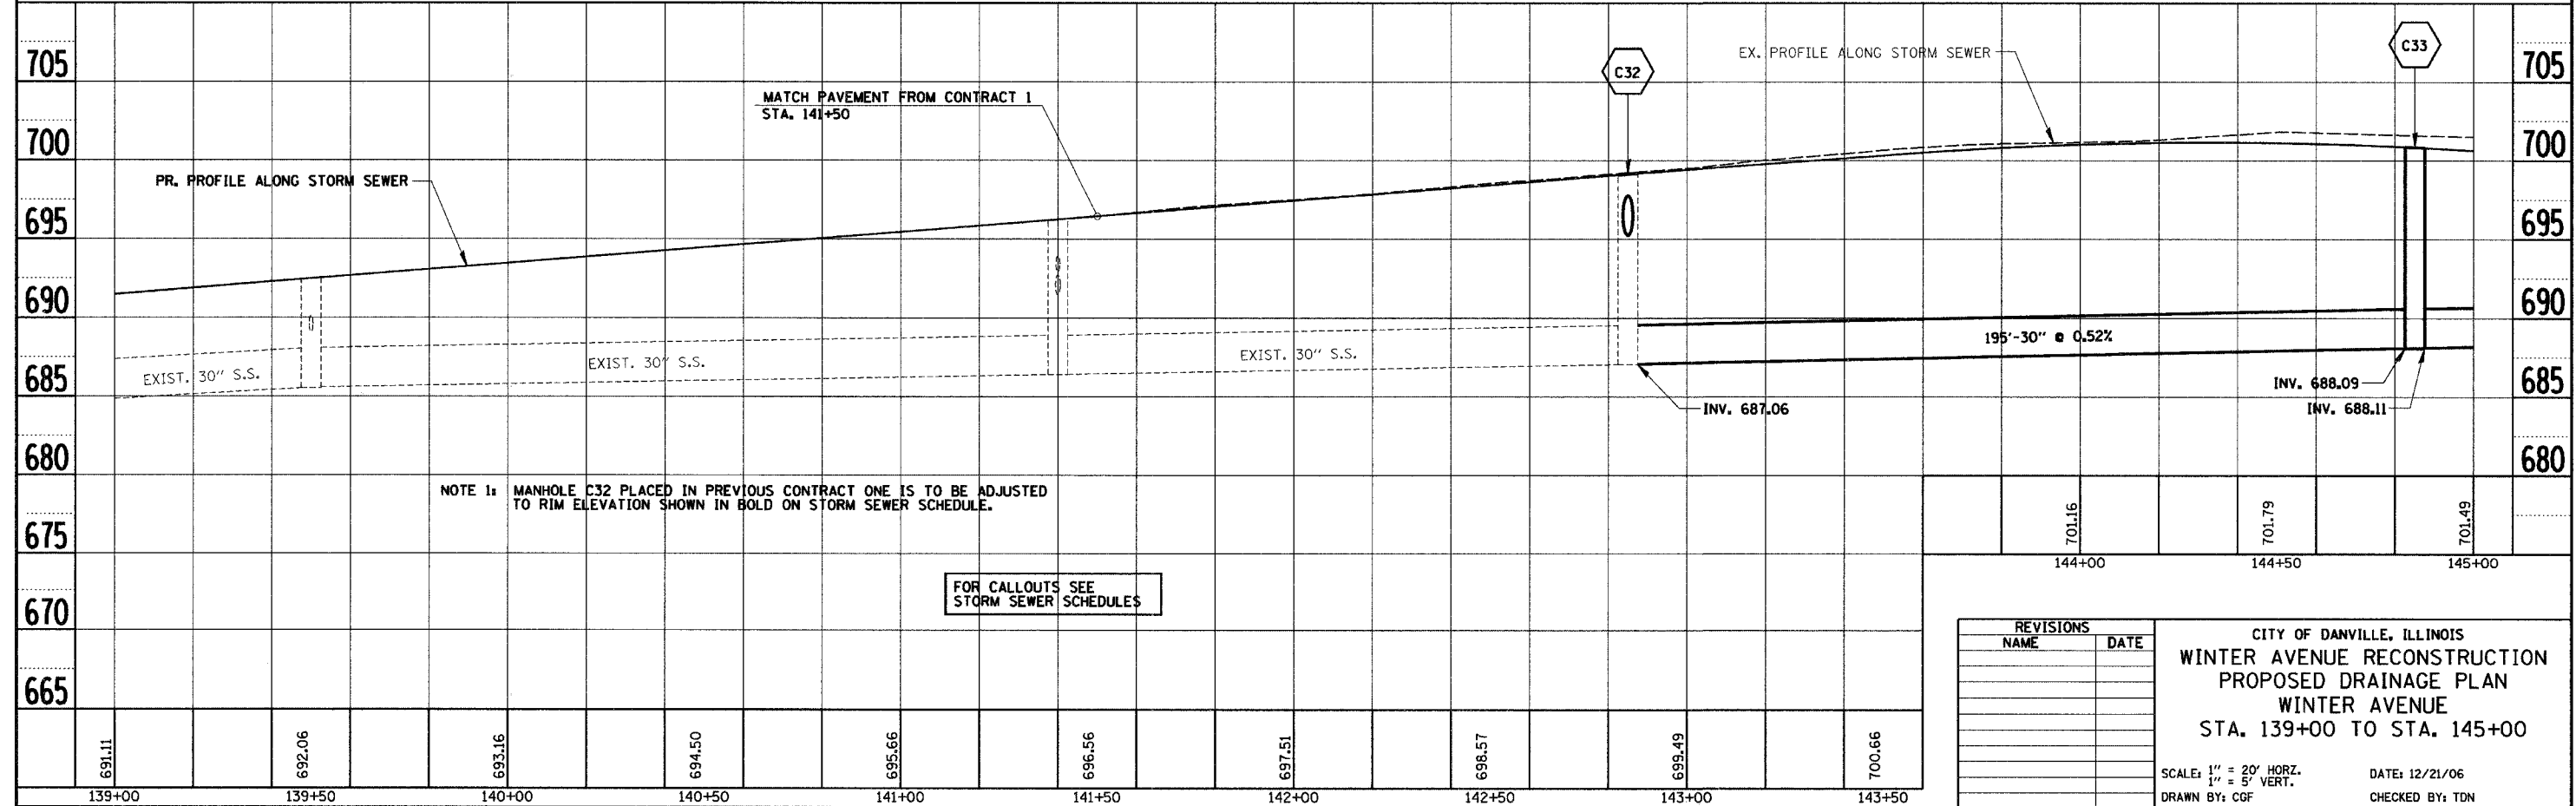

REVISIONS	
NAME	DATE

CITY OF DANVILLE, ILLINOIS
WINTER AVENUE RECONSTRUCTION
PROPOSED DRAINAGE PLAN
WINTER AVENUE
STA. 139+00 TO STA. 145+00

SCALE: 1" = 20' HORZ.
1" = 5' VERT.

DATE: 12/21/06
DRAWN BY: CGF
CHECKED BY: TDN

691.11	692.06	693.16	694.50	695.66	696.56	697.51	698.57	699.49	700.66
139+00	139+50	140+00	140+50	141+00	141+50	142+00	142+50	143+00	143+50