 




DATE	BY

DATE	BY

F.A.U. ROUTE	SECTION	COUNTY	TOTAL SHEETS	SHEET NO.
9089	04-00180-02-PV	MADISON	92	39
FED. ROAD DIST. NO.	ILLINOIS	FED. AID PROJECT		
CONTRACT NO. 97299				

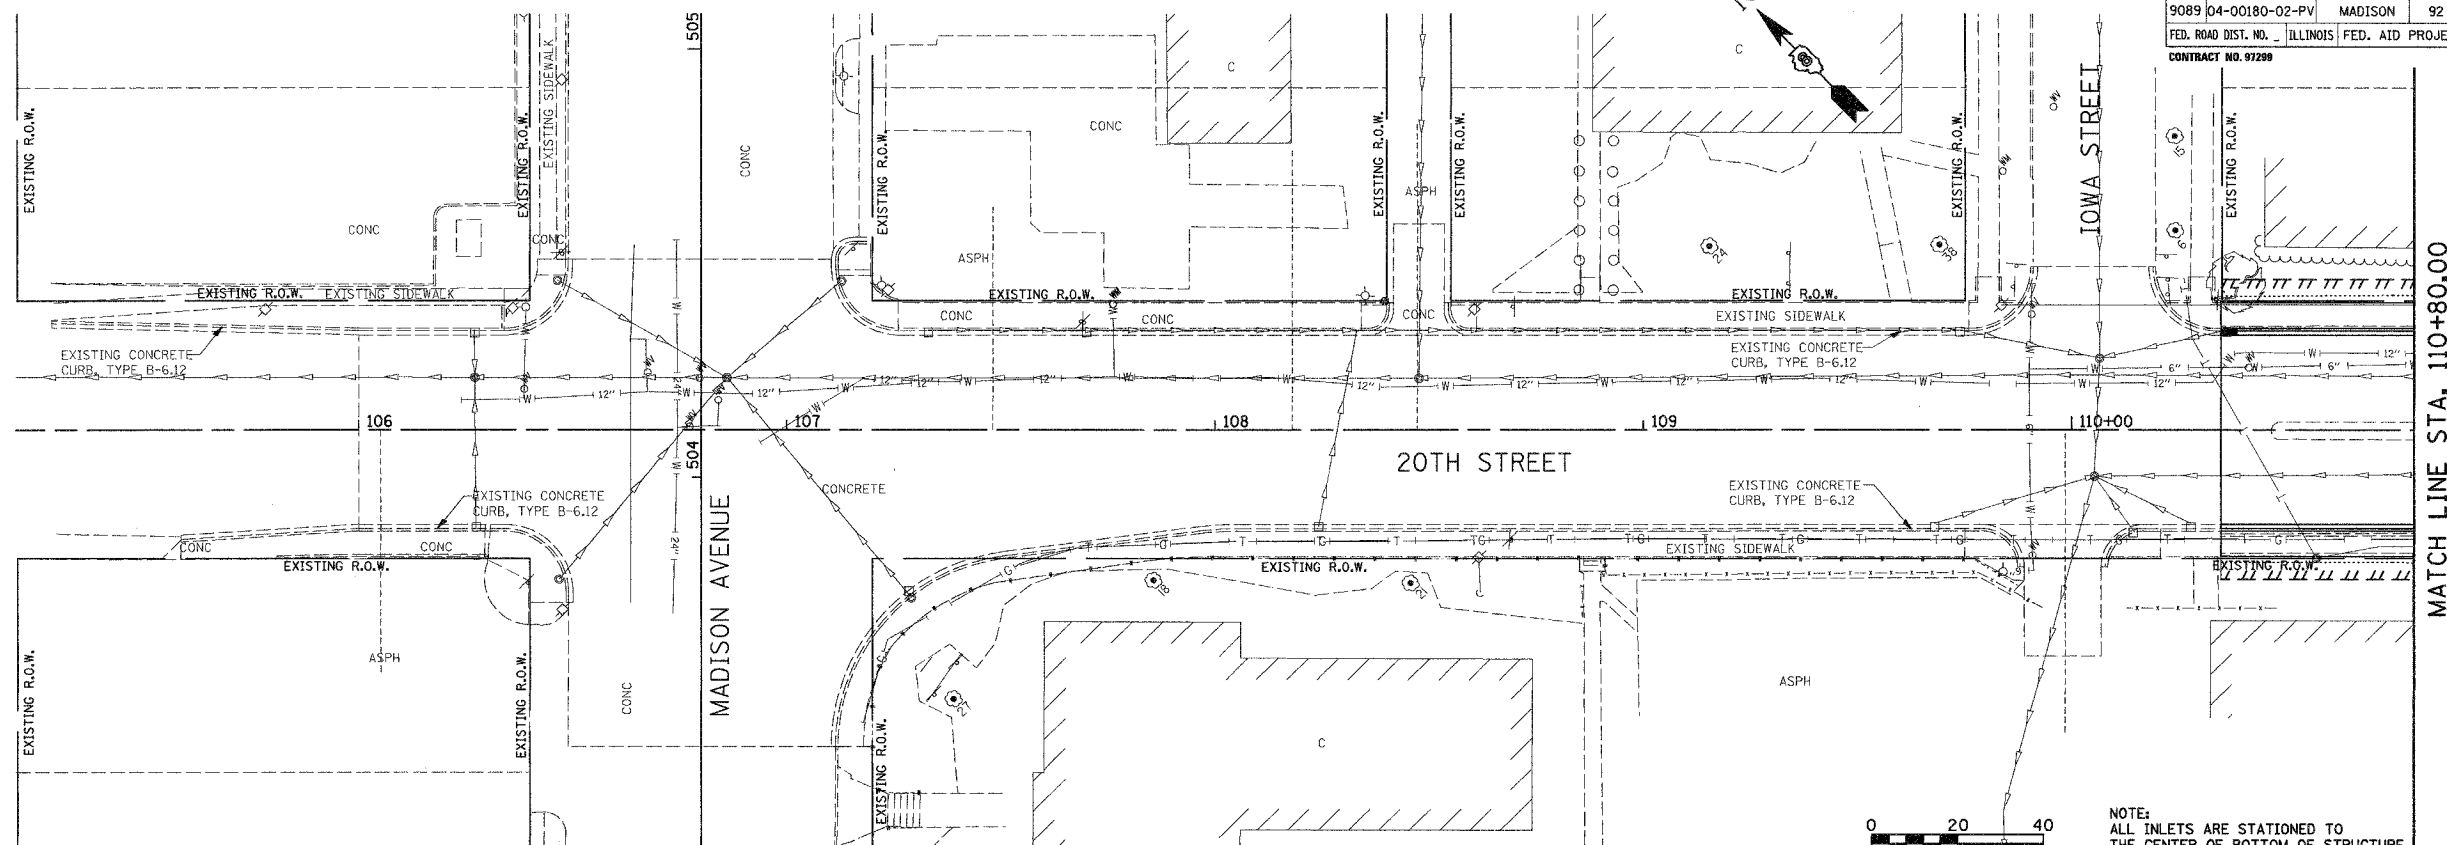

NOTE:
ALL INLETS ARE STATIONED TO
THE CENTER OF BOTTOM OF STRUCTURE.

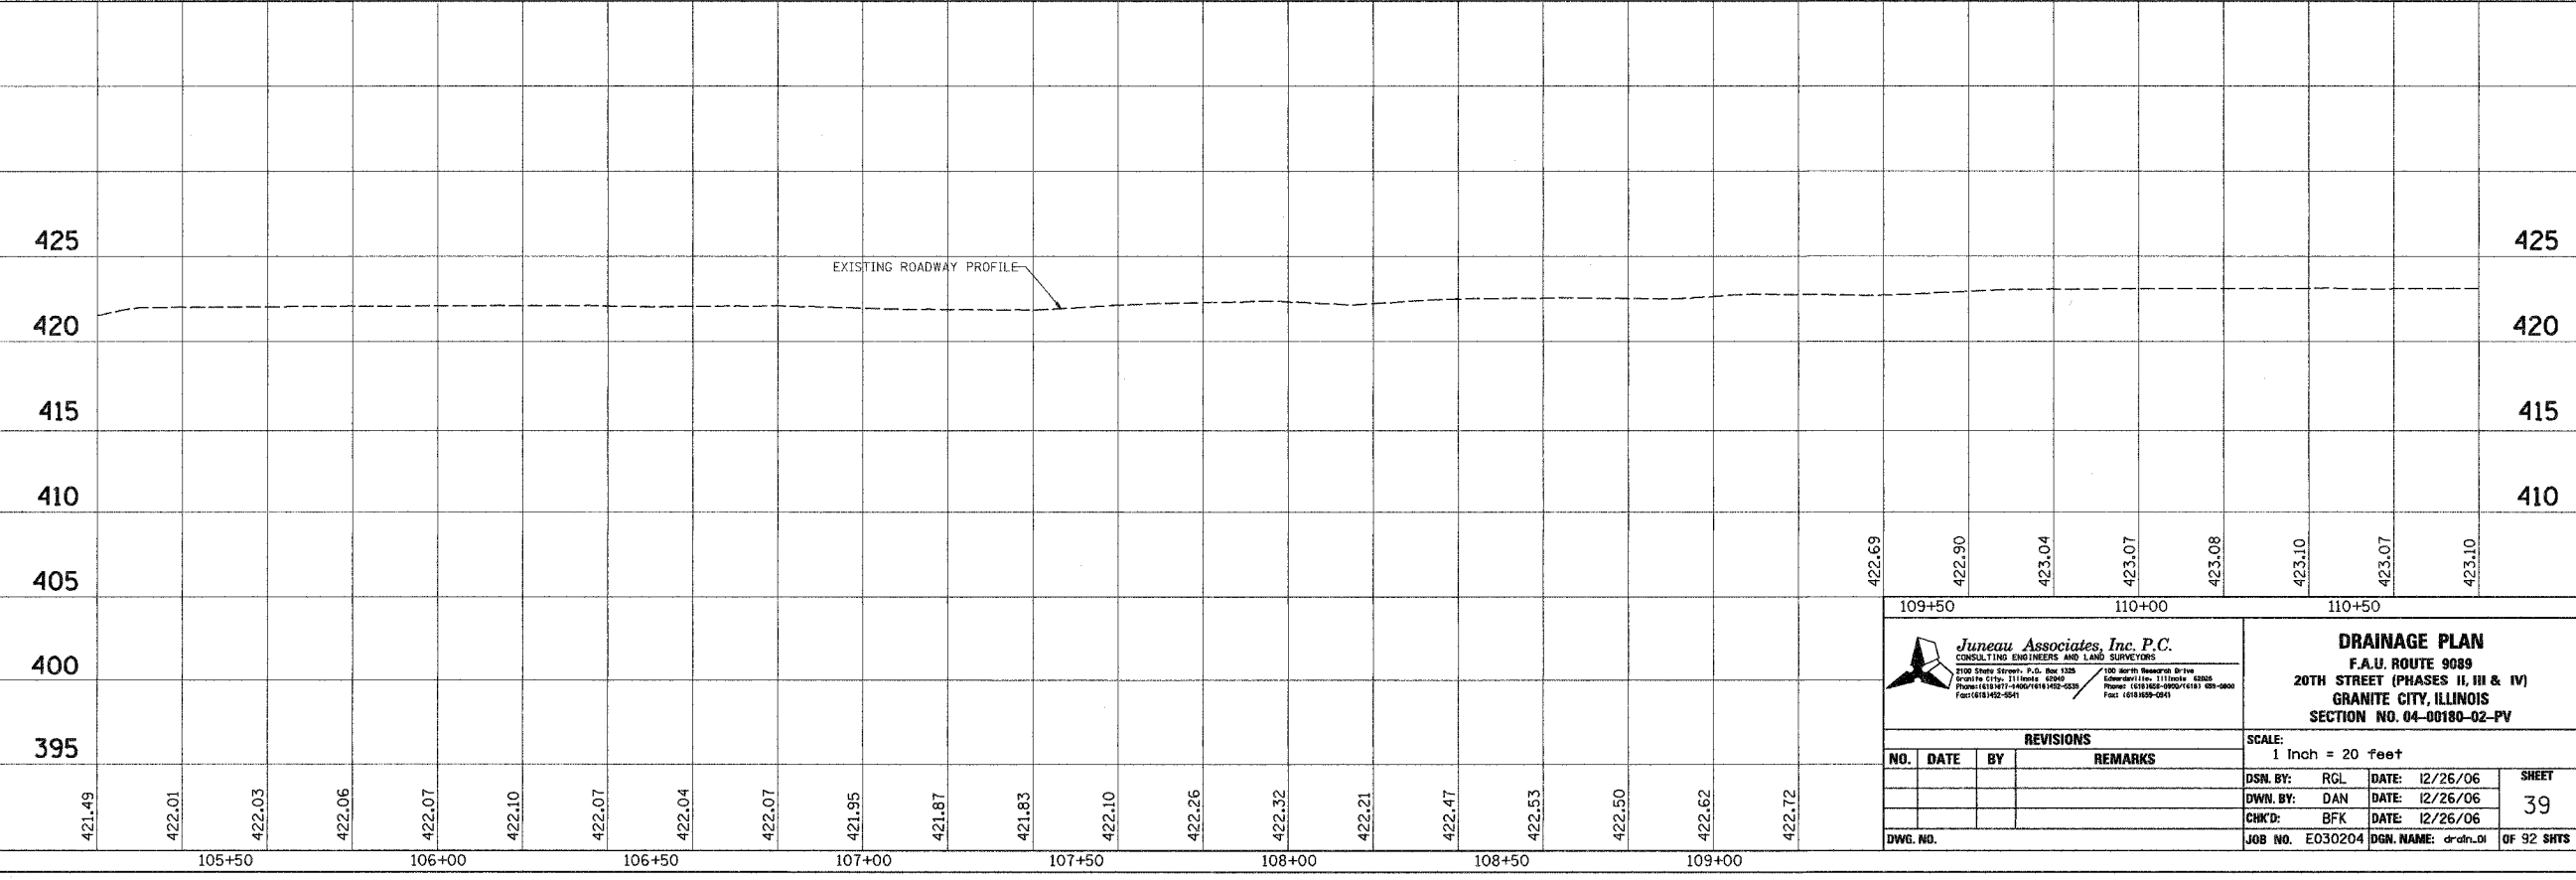

Juneau Associates, Inc. P.C.
CONSULTING ENGINEERS AND LAND SURVEYORS
2109 State Street, P.O. Box 1218
Granite City, Illinois 62040
Phone: (618) 977-4400 (618) 977-4533
Fax: (618) 977-5541

DRAINAGE PLAN
F.A.U. ROUTE 9089
20TH STREET (PHASES II, III & IV)
GRANITE CITY, ILLINOIS
SECTION NO. 04-00180-02-PV

SCALE: 1 Inch = 20 feet

NO.		DATE	BY	REMARKS

DSN. BY: RGL	DATE: 12/26/06	SHEET 39
DWN. BY: DAN	DATE: 12/26/06	
CHKD: BFK	DATE: 12/26/06	
DWG. NO.:	JOB NO. E030204	DSN. NAME: dr_ah_01

OF 92 SHTS