



F.A.U. ROUTE	SECTION	COUNTY	TOTAL SHEETS	SHEET NO.
9089	04-00180-02-PV	MADISON	92	42
FED. ROAD DIST. NO. - ILLINOIS FED. AID PROJECT				
CONTRACT NO. 97299				

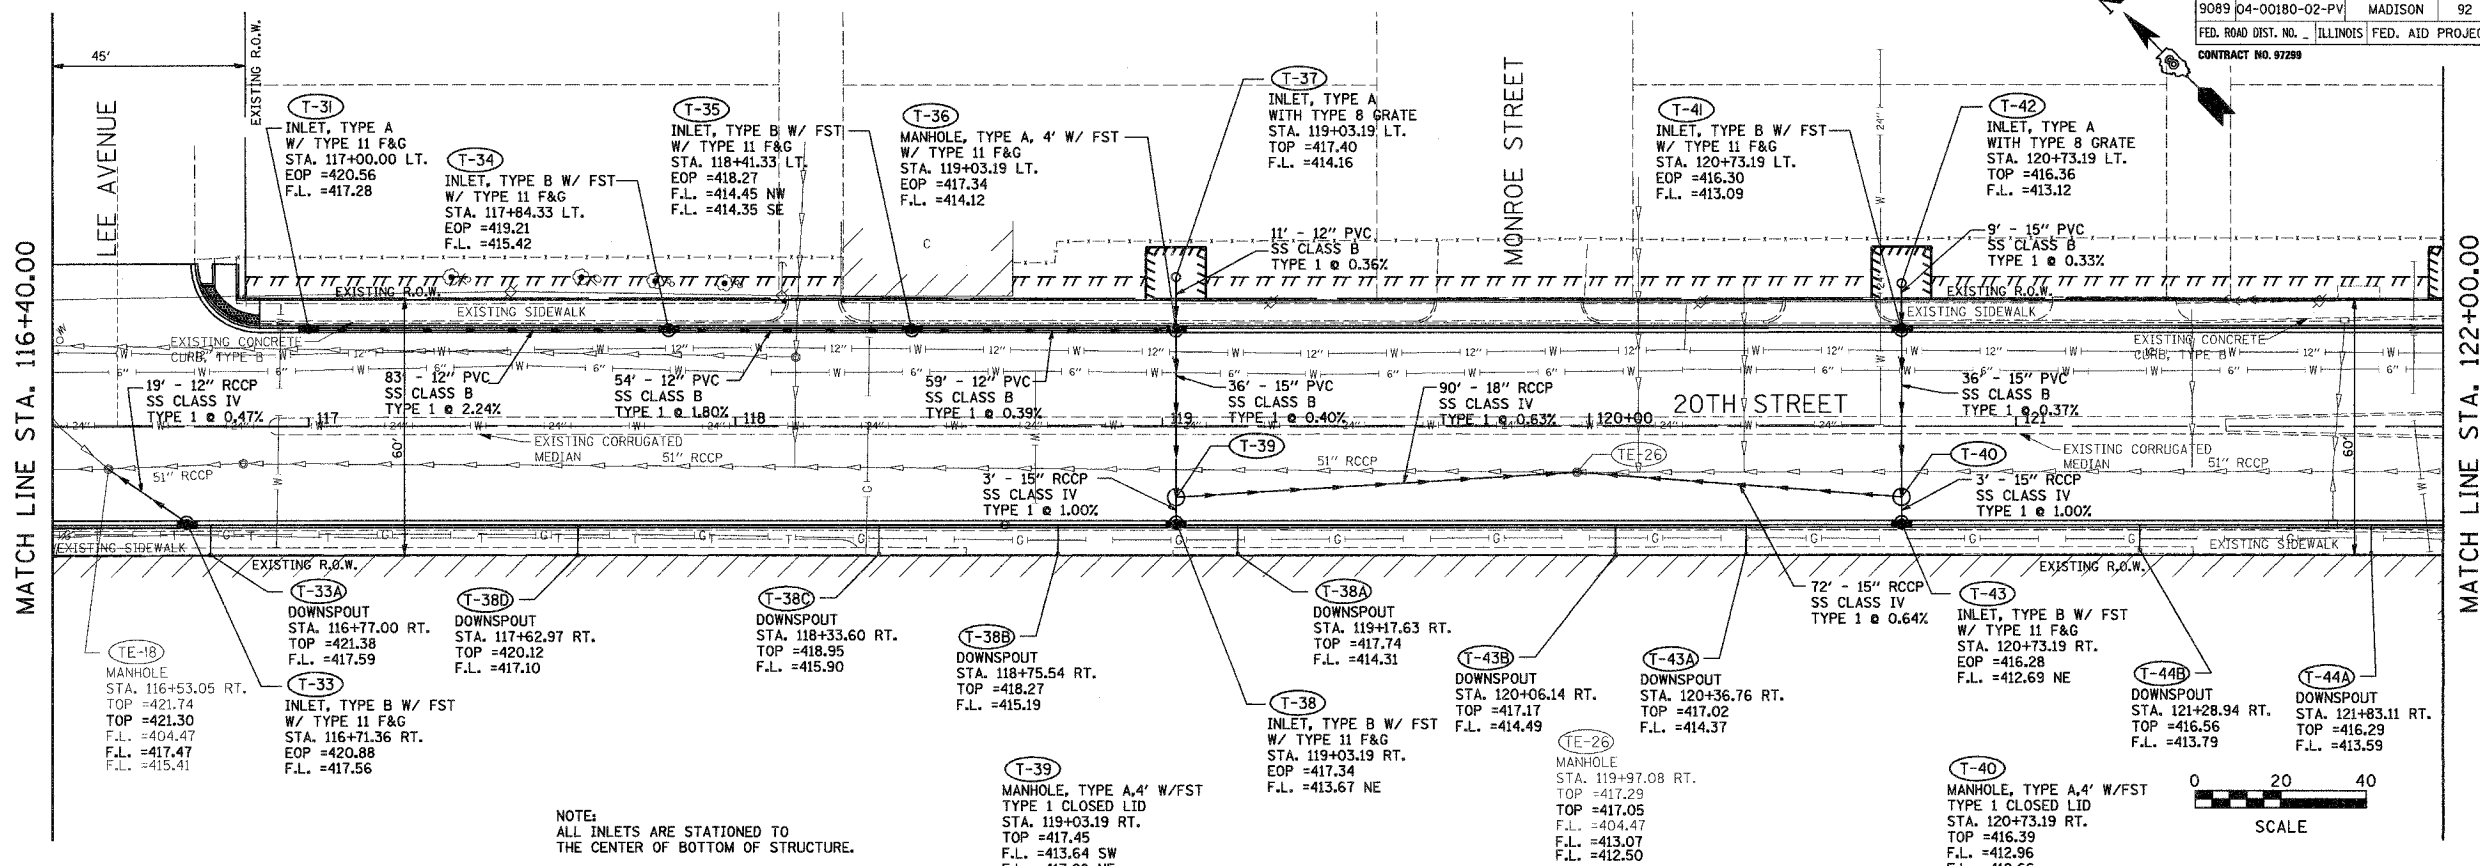

NOTE:
ALL INLETS ARE STATIONED TO
THE CENTER OF BOTTOM OF STRUCTURE.

BY	DATE
FINAL SURVEYED	
SURVEY PLOTTED	
NOTE BOOK	
TEMPLATE	
AREAS CHECKED	
NO.	

BY	DATE
ORIGINAL SURVEYED	
SURVEY PLOTTED	
NOTE BOOK	
TEMPLATE	
AREAS CHECKED	
NO.	

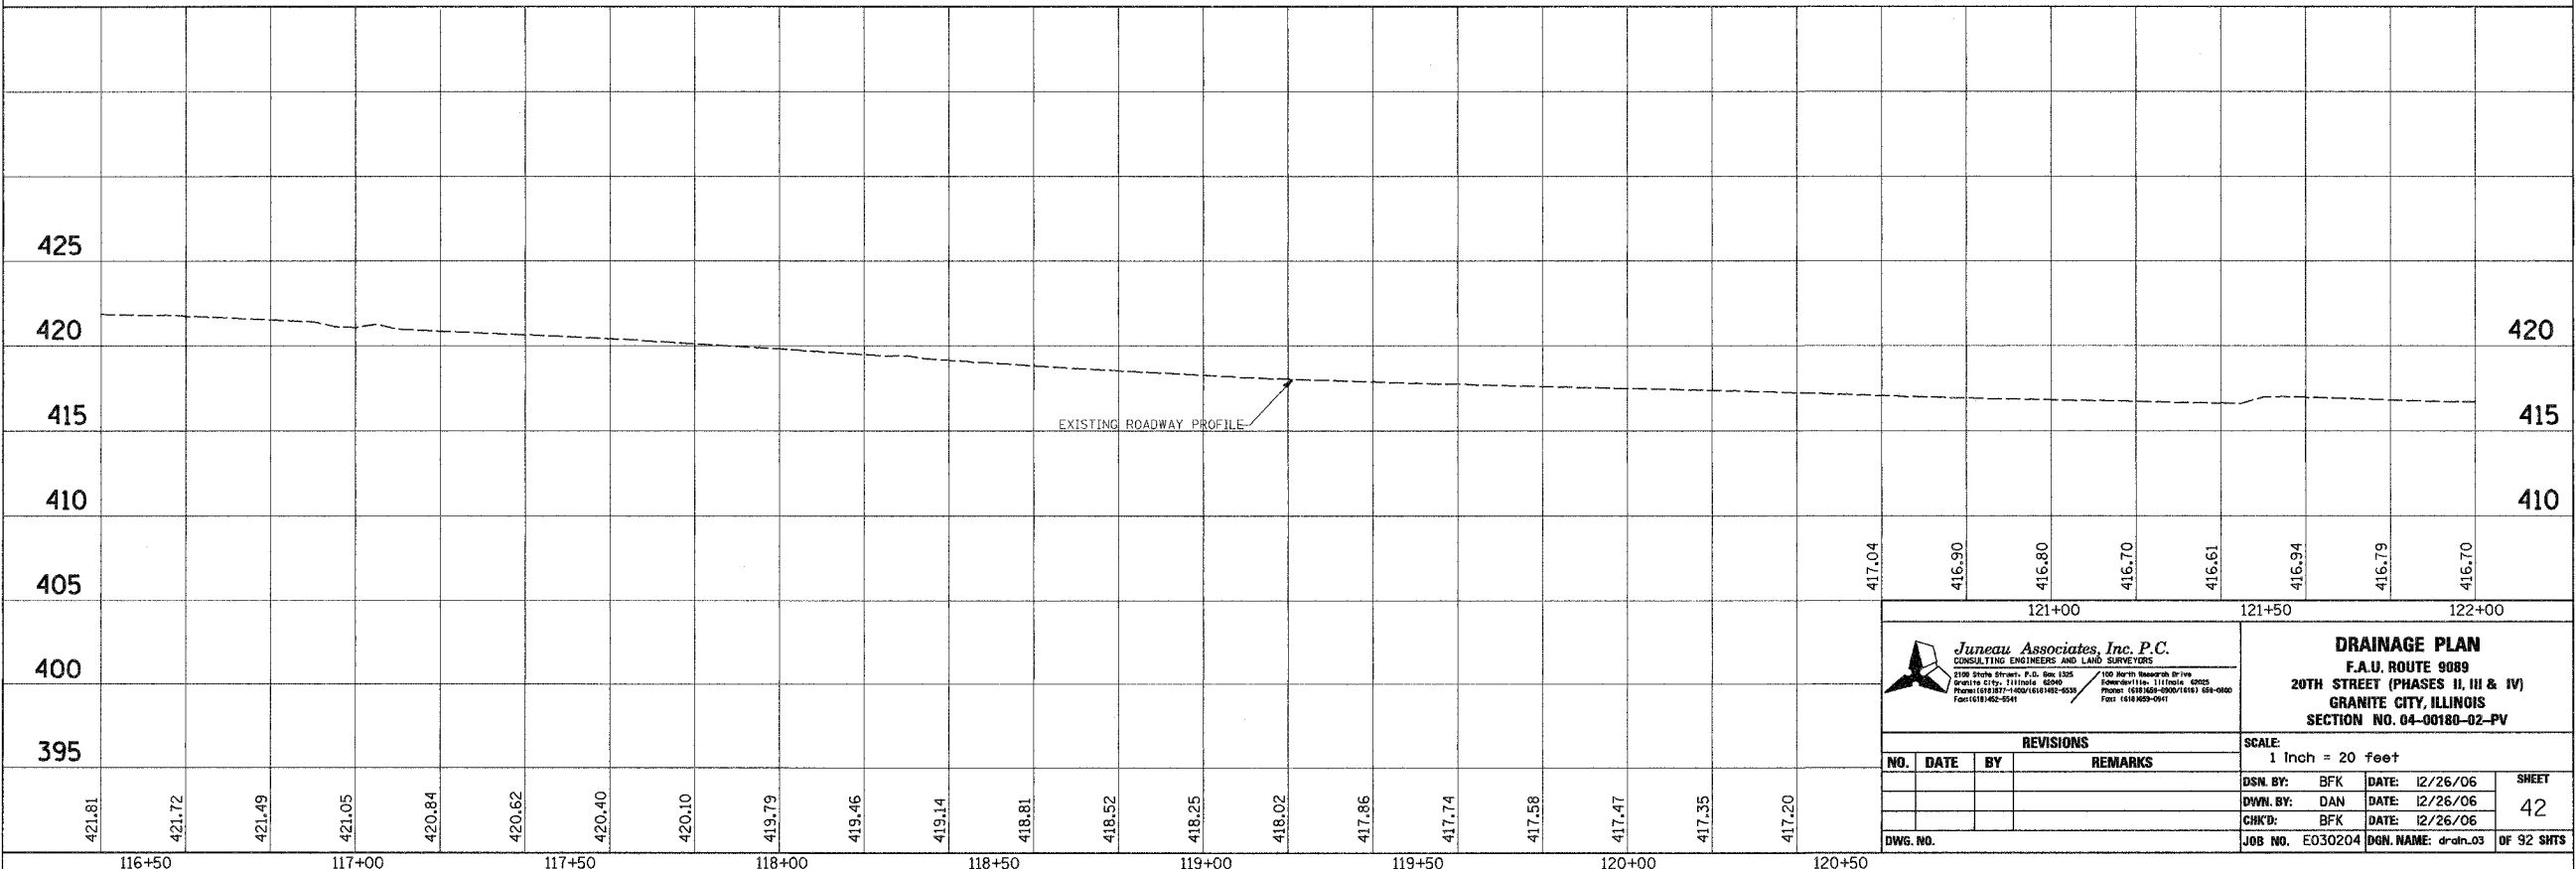

<p>Junear Associates, Inc. P.C. CONSULTING ENGINEERS AND LAND SURVEYORS 2100 State Street, P.O. Box 1305 Granite City, Illinois 62040 Phone: (618) 277-1000 / (618) 277-0035 Fax: (618) 462-9541</p>		<p>DRAINAGE PLAN F.A.U. ROUTE 9089 20TH STREET (PHASES II, III & IV) GRANITE CITY, ILLINOIS SECTION NO. 04-00180-02-PV</p>									
<p>REVISIONS</p> <table border="1"> <thead> <tr> <th>NO.</th> <th>DATE</th> <th>BY</th> <th>REMARKS</th> </tr> </thead> <tbody> <tr> <td> </td> <td> </td> <td> </td> <td> </td> </tr> </tbody> </table>		NO.	DATE	BY	REMARKS					<p>SCALE: 1 Inch = 20 feet</p>	
NO.	DATE	BY	REMARKS								
<p>DSN. BY: BFK DATE: 12/26/06</p>		<p>SHEET 42</p>									
<p>CHK'D: BFK DATE: 12/26/06</p>		<p>JOB NO. E030204 DGN. NAME: drain_03 OF 92 SHTS</p>									