



BY	DATE
FINAL SURVEY PLOTTED	
NOTE BOOK TEMPLATE	
AREAS CHECKED	
NO.	

BY	DATE
ORIGINAL SURVEY PLOTTED	
NOTE BOOK TEMPLATE	
AREAS CHECKED	
NO.	

F.A.U. ROUTE	SECTION	COUNTY	TOTAL SHEETS	SHEET NO.
9089 04-00180-02-PV	MADISON	ILLINOIS	92	44
FED. ROAD DIST. NO. ILLINOIS FED. AID PROJECT				
CONTRACT NO. 97299				

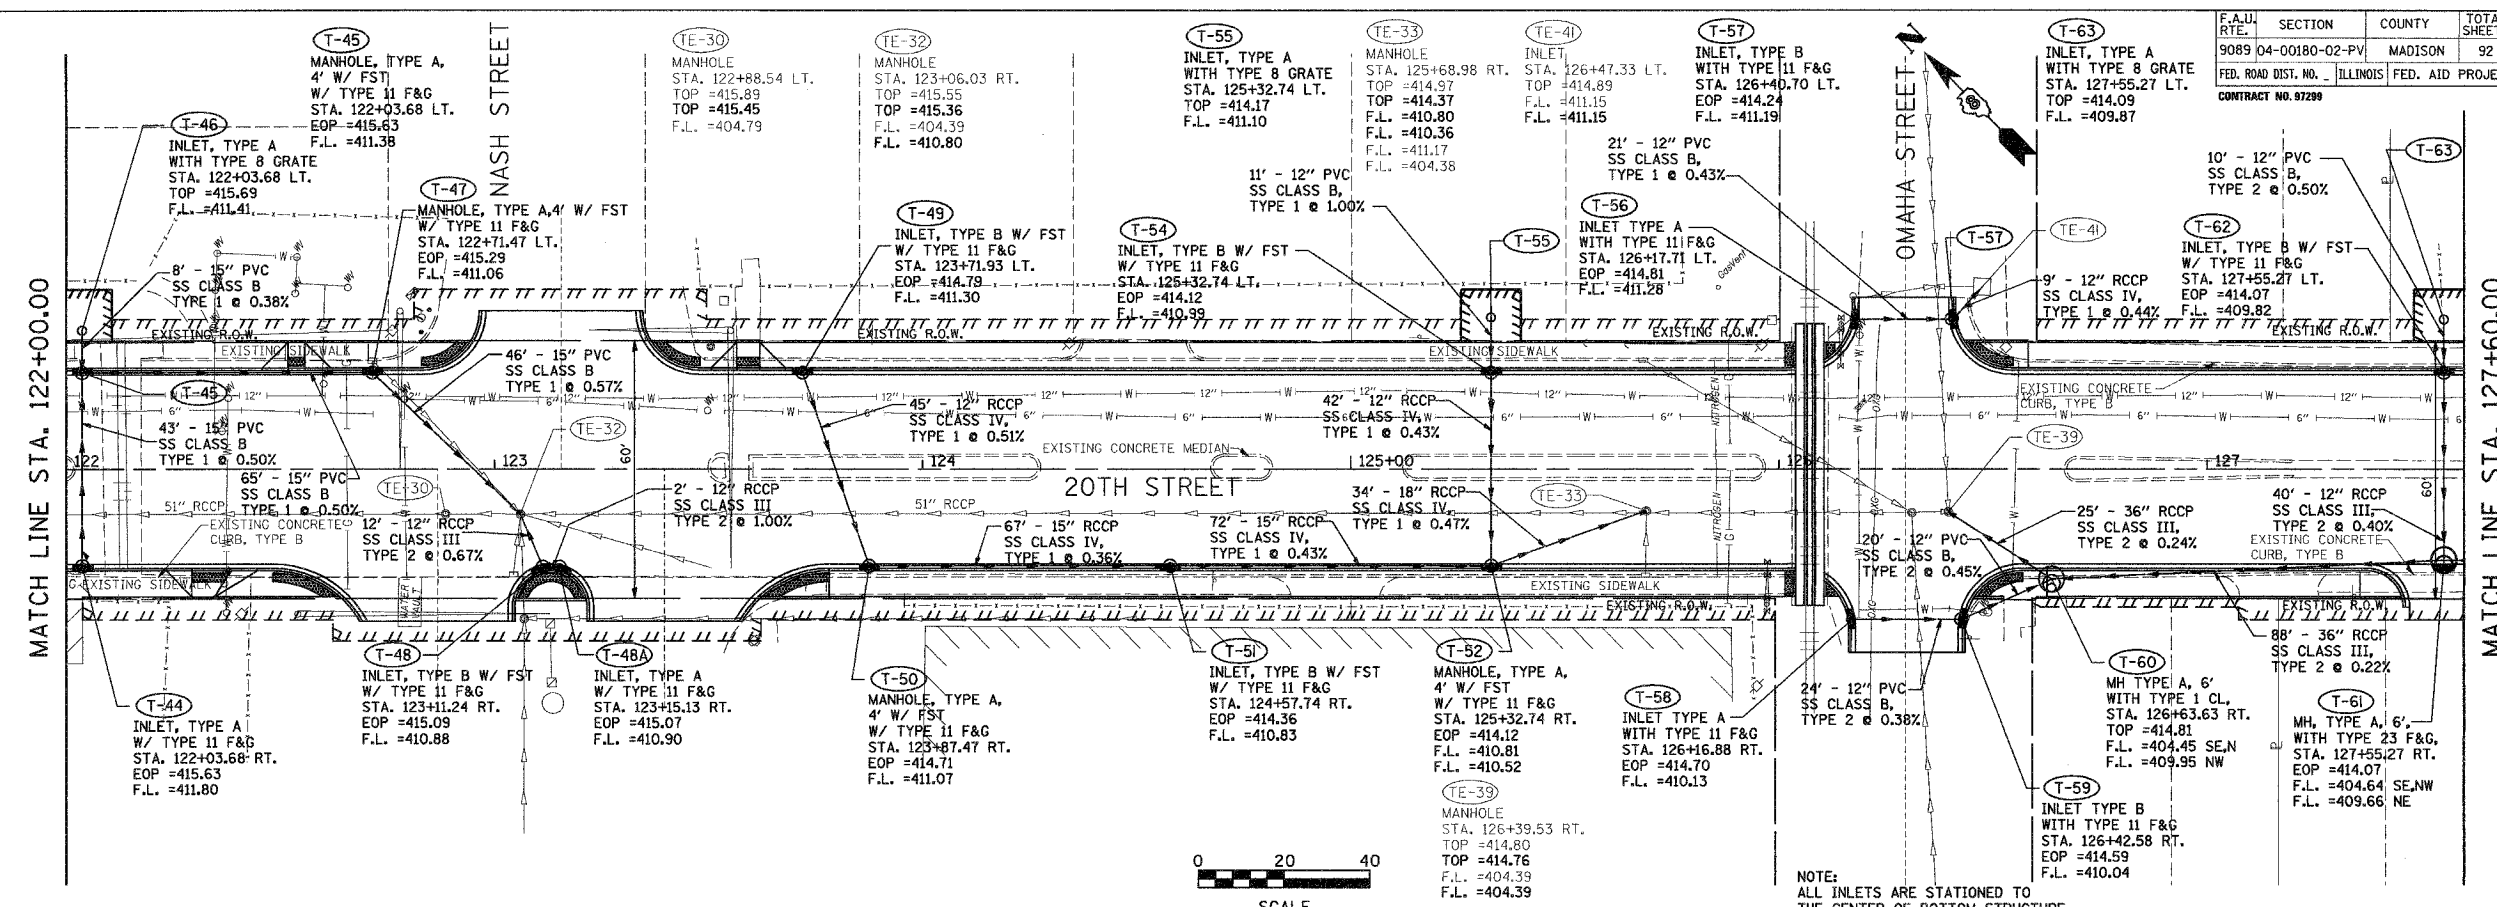

NOTE:  
ALL INLETS ARE STATIONED TO  
THE CENTER OF BOTTOM STRUCTURE.

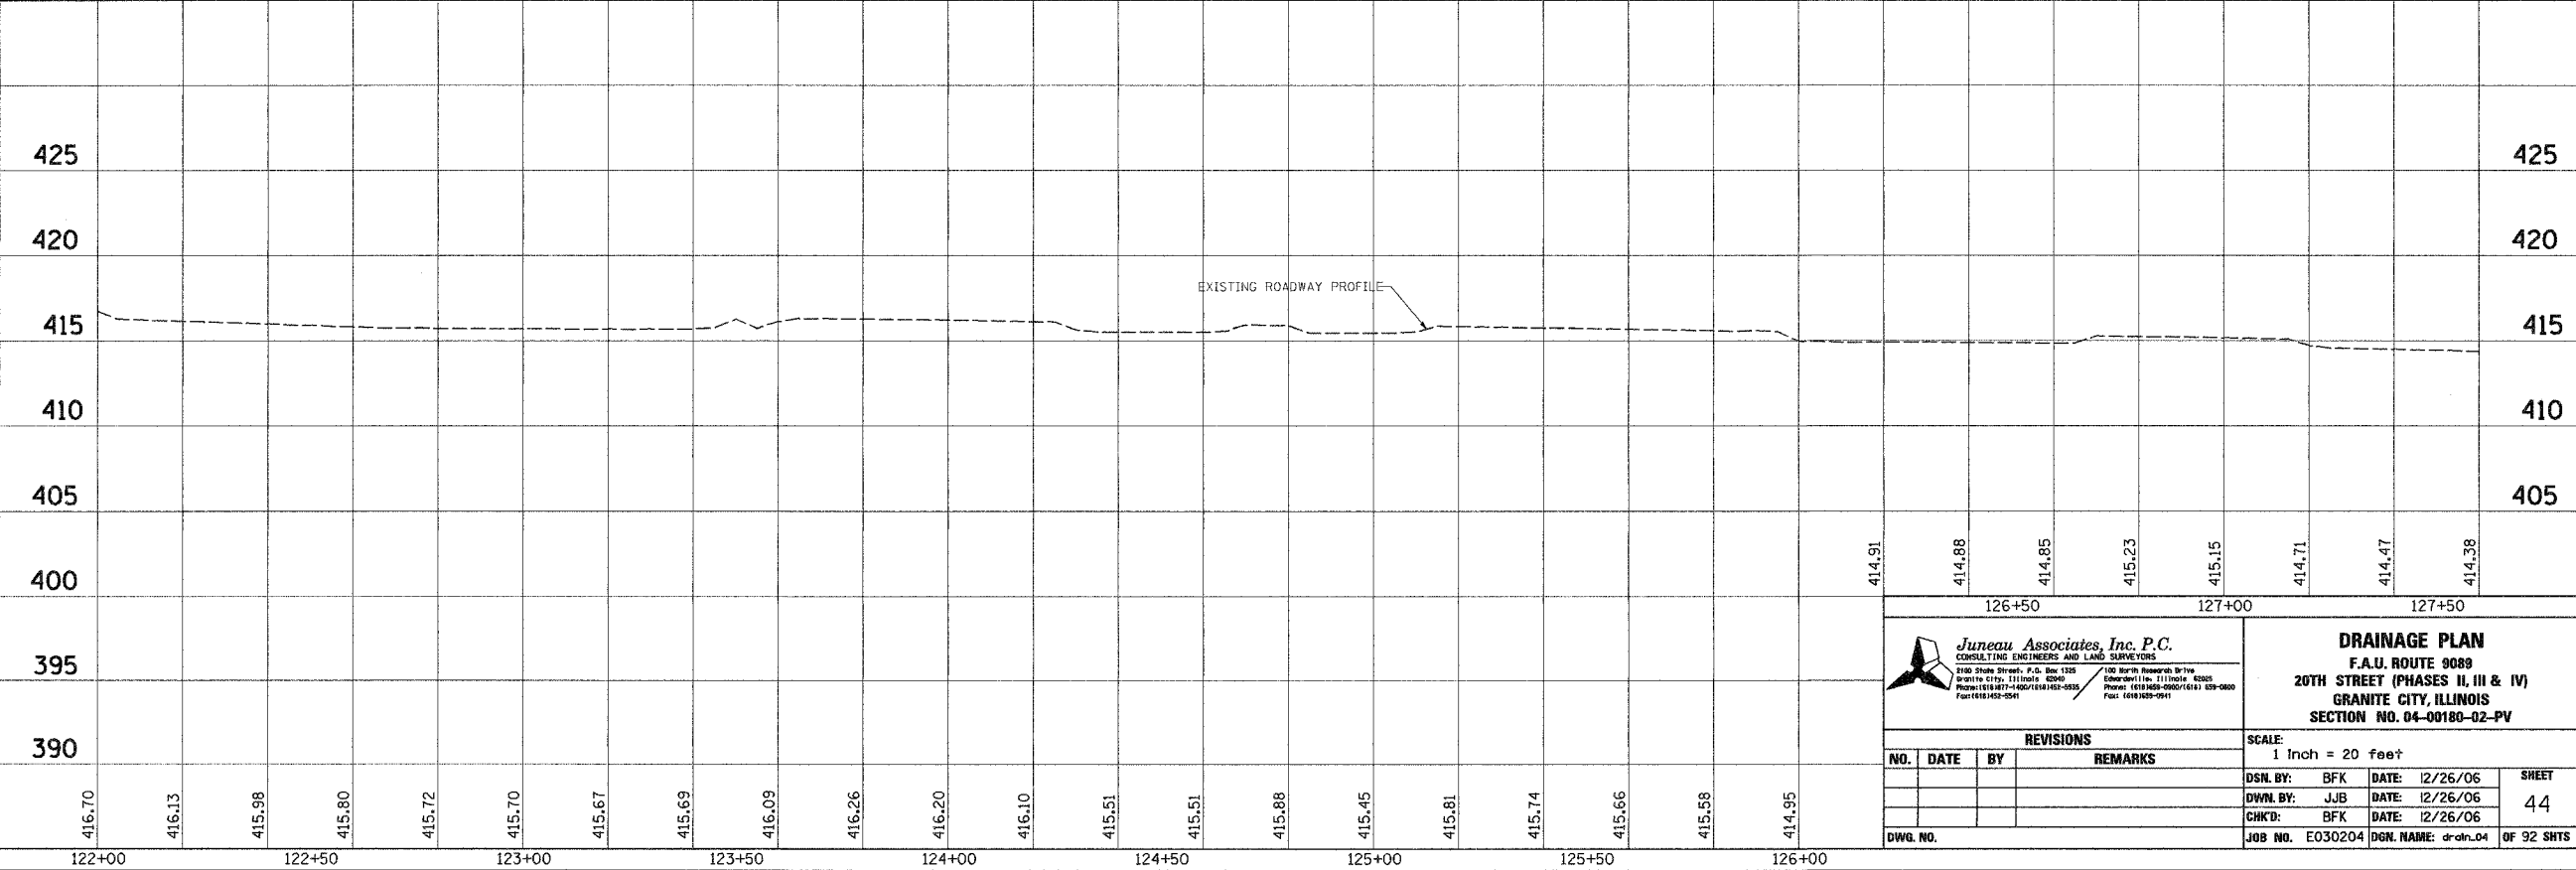

**Juneau Associates, Inc. P.C.**  
CONSULTING ENGINEERS AND LAND SURVEYORS  
2100 State Street, P.O. Box 1208  
Granite City, Illinois 62041  
Phone: (618) 467-4400 / (618) 467-4455  
Fax: (618) 467-5541

**DRAINAGE PLAN**  
F.A.U. ROUTE 9089  
20TH STREET (PHASES II, III & IV)  
GRANITE CITY, ILLINOIS  
SECTION NO. 04-00180-02-PV

REVISIONS			
NO.	DATE	BY	REMARKS

SCALE: 1 Inch = 20 feet	
DSN. BY: BFK	DATE: 12/26/06
OWN. BY: JJB	DATE: 12/26/06
CHKD: BFK	DATE: 12/26/06
DWG. NO.:	JOB NO. E030204 DGN. NAME: d-rtr_04
OF 92 SHTS	