



F.A.U. ROUTE:	SECTION:	COUNTY:	TOTAL SHEETS:	SHEET NO.:
9089 04-00180-02-PV		MADISON	92	48
FED. ROAD DIST. NO.:	ILLINOIS FED. AID PROJECT		CONTRACT NO. 97299	

DATE	BY
ORIGINAL SURVEY PLOTTED	
NOTE BOOK TEMPLATE	
AREAS CHECKED	
NO.	

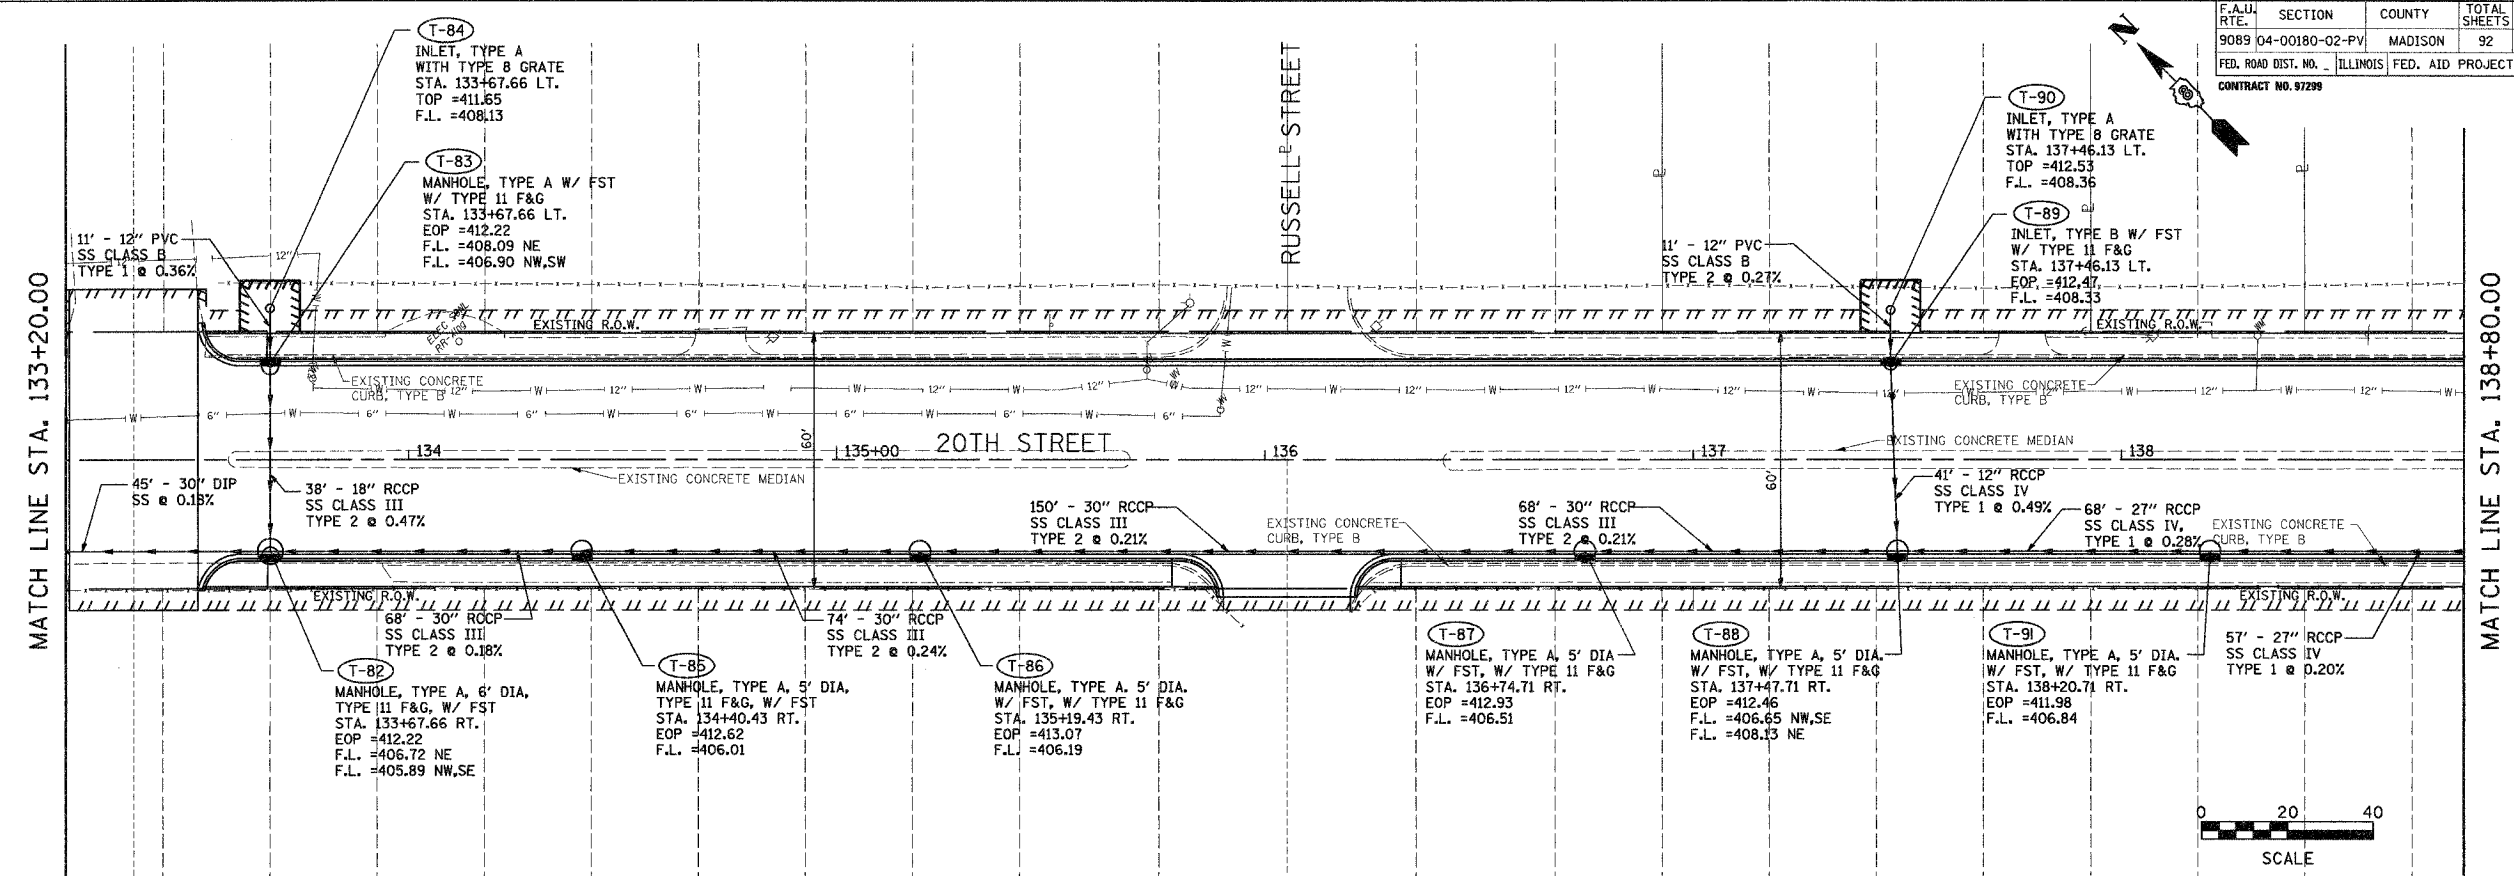

DATE	BY
ORIGINAL SURVEY PLOTTED	
NOTE BOOK TEMPLATE	
AREAS CHECKED	
NO.	

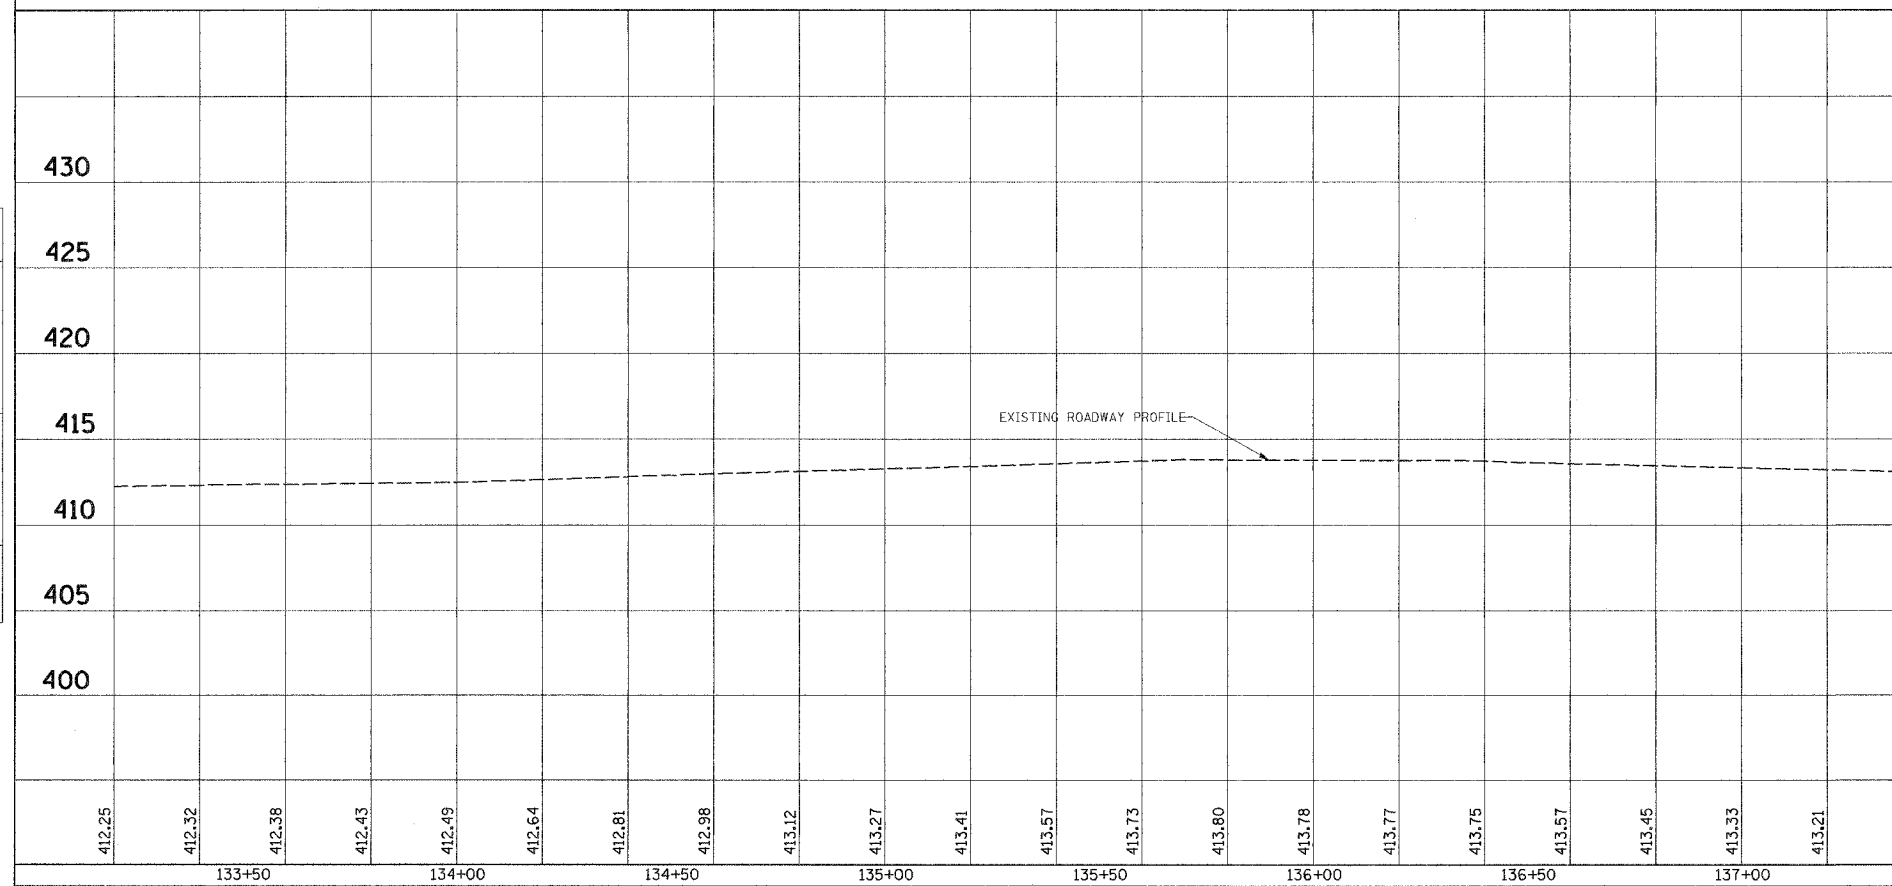

412.95	412.80	412.68	412.58	412.48	412.39	412.31								
137+50		138+00		138+50										
<p>Juneau Associates, Inc. P.C. CONSULTING ENGINEERS AND LAND SURVEYORS 209 State Street, P.O. Box 628 Granite City, Illinois 62041 Phone: (618) 957-4400 FAX: (618) 957-4401</p>				<p>DRAINAGE PLAN F.A.U. ROUTE 9089 20TH STREET (PHASES II, III & IV) GRANITE CITY, ILLINOIS SECTION NO. 04-00180-02-PV</p>										
<p>REVISIONS</p> <table border="1"> <thead> <tr> <th>NO.</th> <th>DATE</th> <th>BY</th> <th>REMARKS</th> </tr> </thead> <tbody> <tr> <td> </td> <td> </td> <td> </td> <td> </td> </tr> </tbody> </table>				NO.	DATE	BY	REMARKS					<p>SCALE: 1 Inch = 20 feet</p>		
NO.	DATE	BY	REMARKS											
<table border="1"> <tr> <td>DSN. BY: BFK</td> <td>DATE: 12/26/06</td> <td rowspan="3">SHEET 48</td> </tr> <tr> <td>DWN. BY: JJB</td> <td>DATE: 12/26/06</td> </tr> <tr> <td>CHKD: BFK</td> <td>DATE: 12/26/06</td> </tr> </table>				DSN. BY: BFK	DATE: 12/26/06	SHEET 48	DWN. BY: JJB	DATE: 12/26/06	CHKD: BFK	DATE: 12/26/06	<p>JOB NO. E030204 DGN. NAME: drain_06 OF 92 SHTS</p>			
DSN. BY: BFK	DATE: 12/26/06	SHEET 48												
DWN. BY: JJB	DATE: 12/26/06													
CHKD: BFK	DATE: 12/26/06													