



FINAL SURVEY PLOTTED	DATE
NO. _____	
NOTE BOOK	BY
NO. _____	
TEMPLATE	
AREAS CHECKED	
AREAS CHECKED	

ORIGINAL SURVEY PLOTTED	DATE
NO. _____	
NOTE BOOK	BY
NO. _____	
TEMPLATE	
AREAS CHECKED	
AREAS CHECKED	

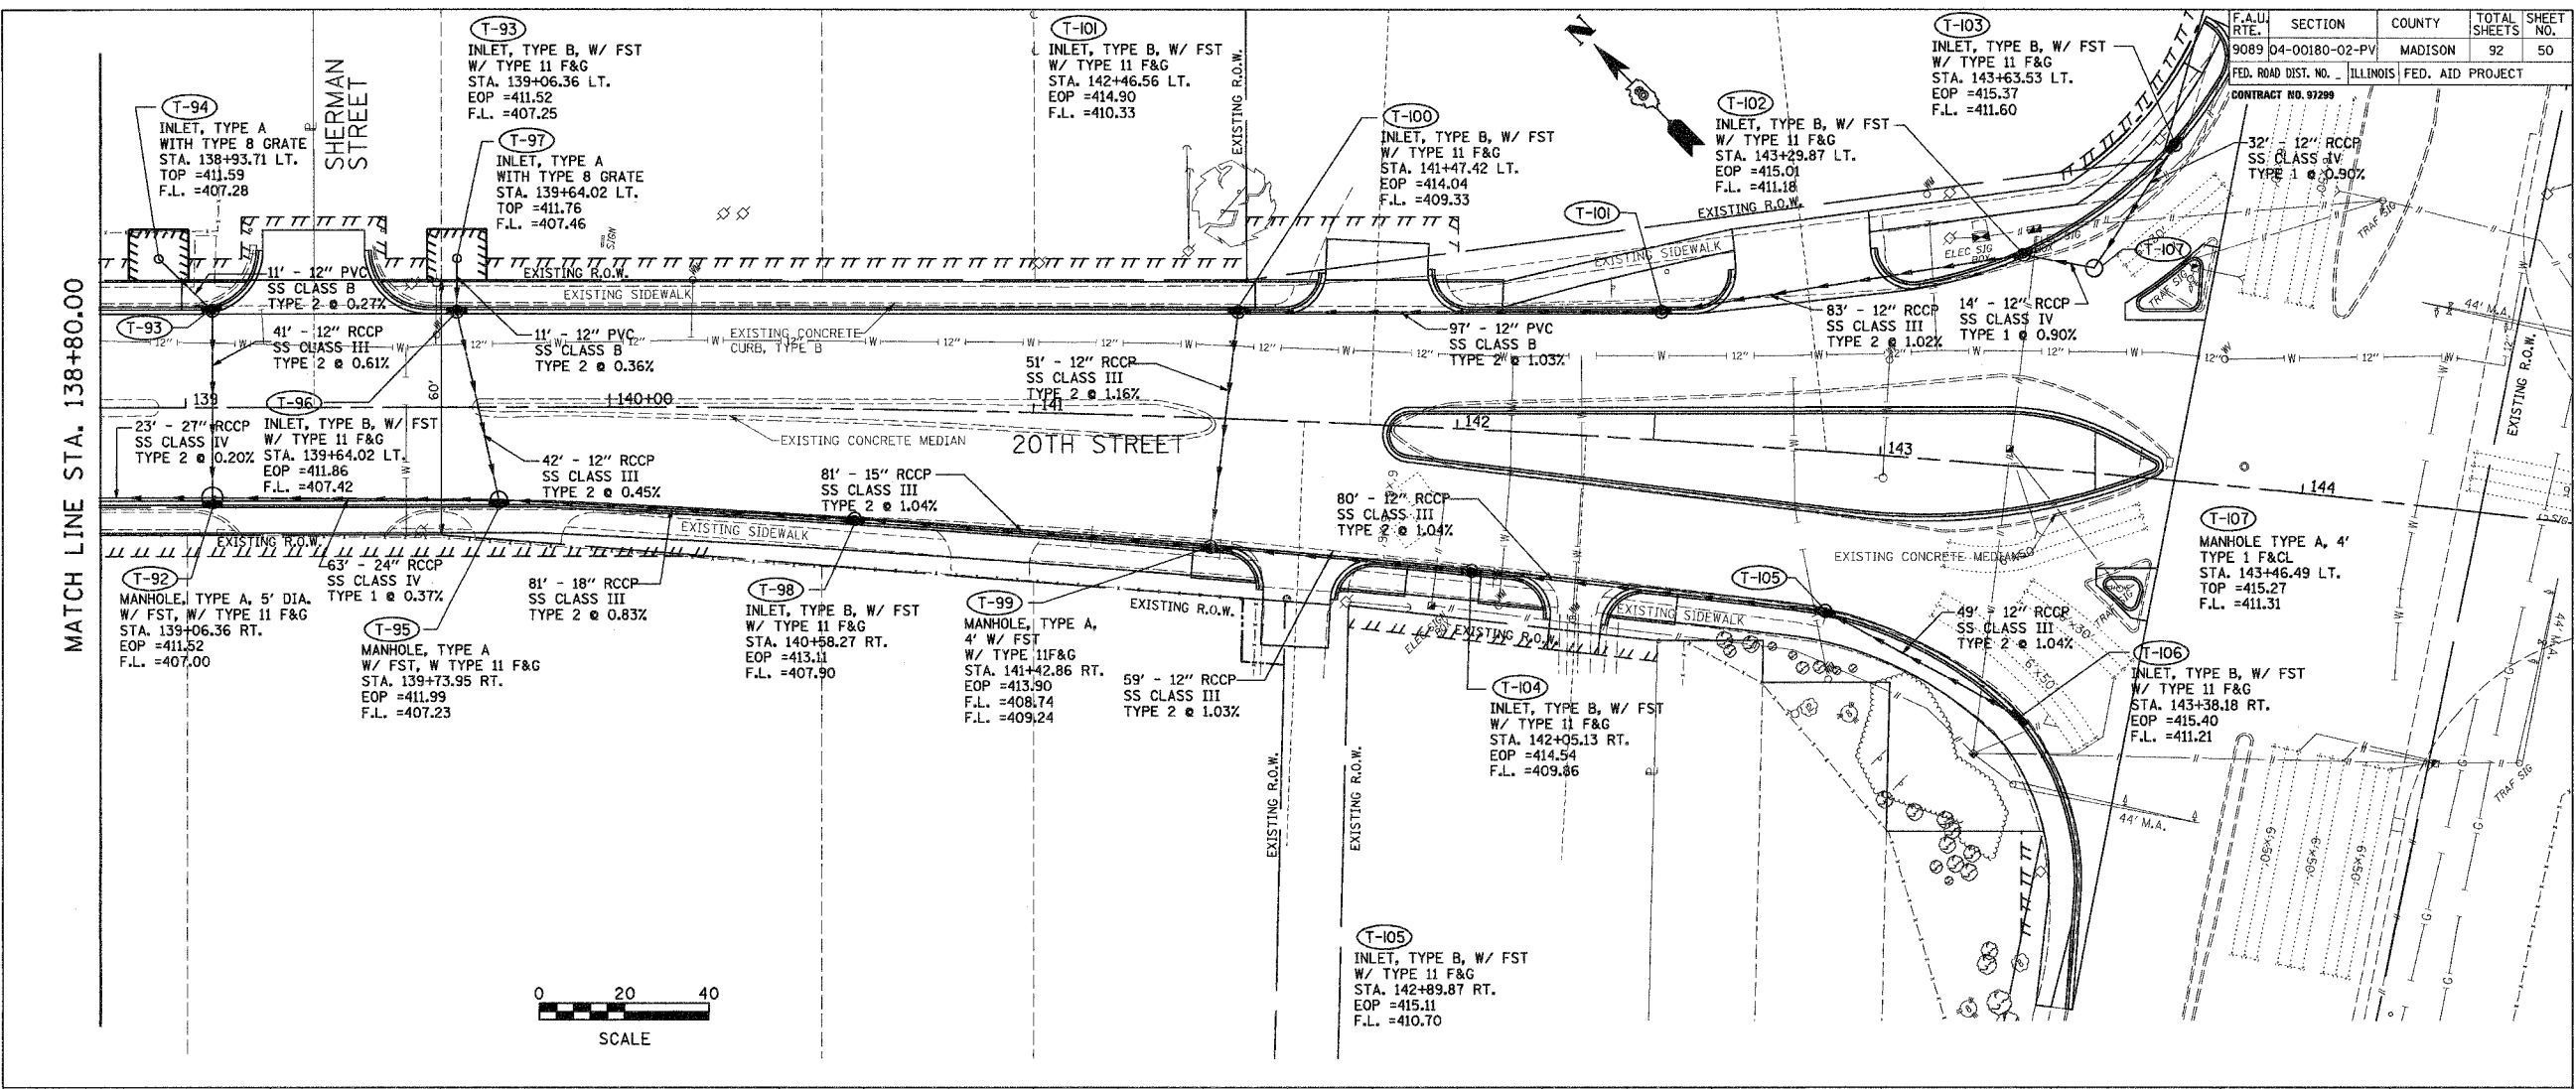

F.A.U. ROUTE	SECTION	COUNTY	TOTAL SHEETS	SHEET NO.
9089 04-00180-02-PV		MADISON	92	50
FED. ROAD DIST. NO. - ILLINOIS FED. AID PROJECT				
CONTRACT NO. 97299				

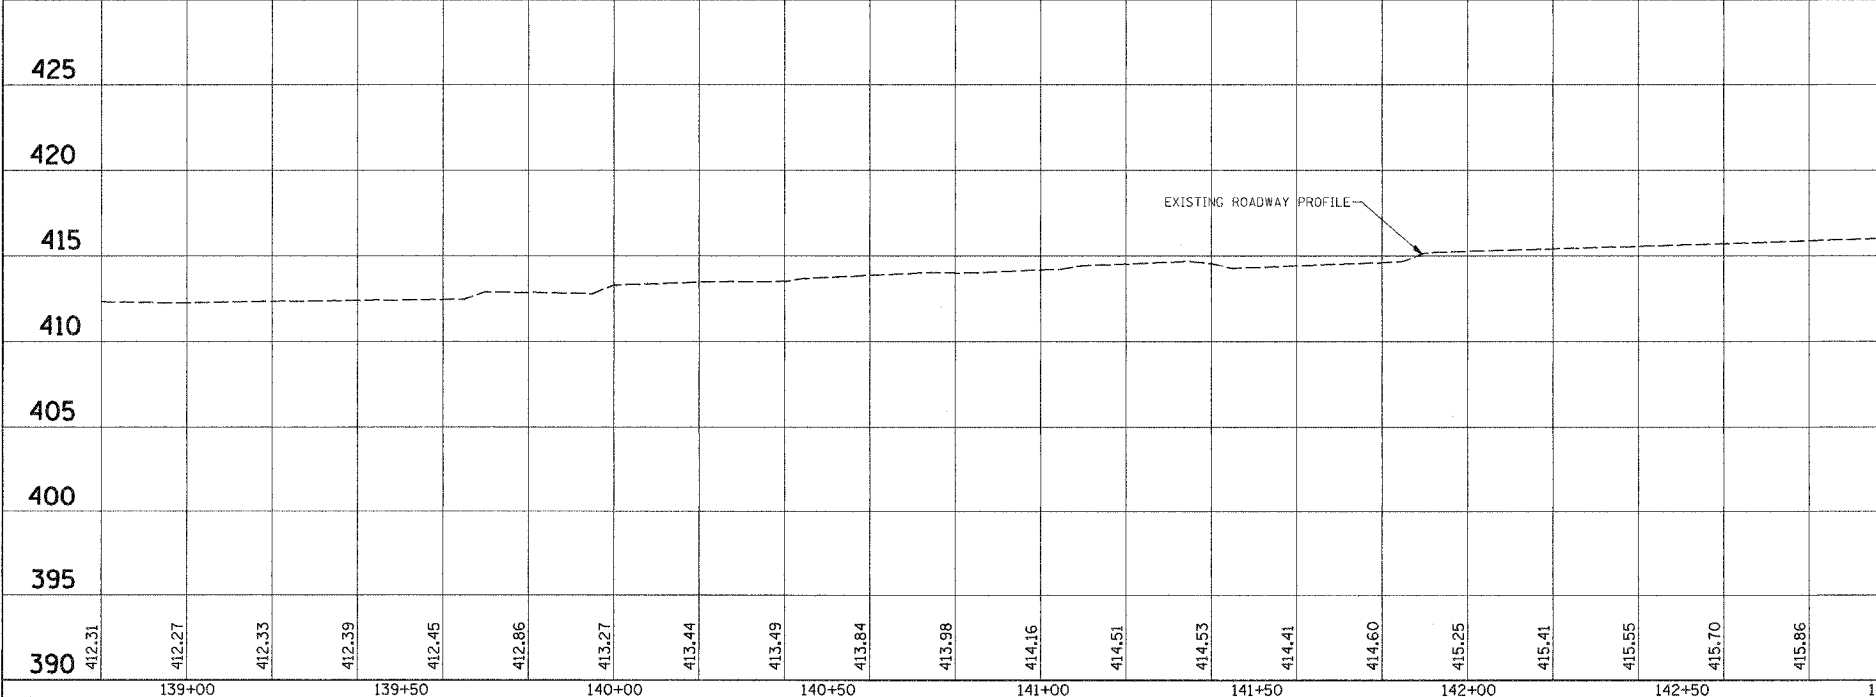

Juneau Associates, Inc. P.C.
CONSULTING ENGINEERS AND LAND SURVEYORS
2100 State Street, P.O. Box 1329
Granite City, Illinois 60140
Phone: (618) 971-4400 / (618) 971-4401
Fax: (618) 971-4401

DRAINAGE PLAN
F.A.U. ROUTE 9089
20TH STREET (PHASES II, III & IV)
GRANITE CITY, ILLINOIS
SECTION NO. 04-00180-02-PV

REVISIONS			
NO.	DATE	BY	REMARKS

SCALE: 1 Inch = 20 feet			
DSN. BY: BFK	DATE: 12/26/06	SHEET	
DWN. BY: DAN	DATE: 12/26/06	50	
CHKD: BFK	DATE: 12/26/06		
JOB NO. E030204	DGN. NAME: drain_07	OF 92 SHTS	