

VILLAGE OF STICKNEY | TOWN OF CICERO
 WEST SIDE OF CICERO AVE.

NOTE:


THE ENVIRONMENTAL FIRM IS REQUIRED TO CONTINUOUSLY MONITOR FOR WORKER PROTECTION AND SOIL CONTAMINATION AT SEVERAL AREAS. SEE SPECIAL PROVISION AND SUPPLEMENTAL SPECIFICATIONS FOR DETAILS.

IL. RTE. 50 (CICERO AVENUE)



MATCHLINE STA. 530+00

END PROJECT
 STA. 544+44.44

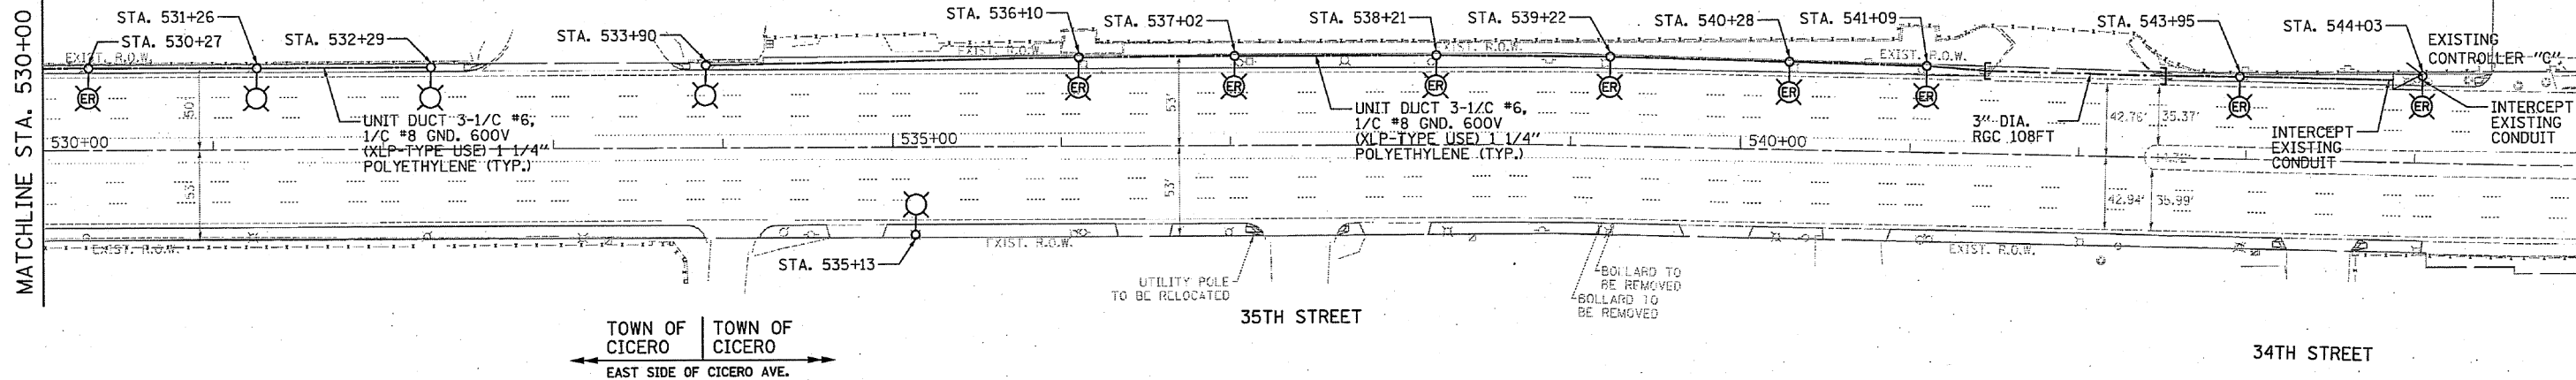

TOWN OF CICERO | TOWN OF CICERO
 EAST SIDE OF CICERO AVE.

35TH STREET

34TH STREET

FILE NAME = #FILES#	USER NAME = #USER#	DESIGNED - MK	REVISED -	STATE OF ILLINOIS DEPARTMENT OF TRANSPORTATION	IL RTE. 50 (CICERO AVE.) - (34TH STREET TO PERSHING ROAD) PROPOSED LIGHTING PLAN		F.A.P. RTE.	SECTION	COUNTY	TOTAL SHEETS	SHEET NO.
	PLOT SCALE = #SCALE#	CHECKED - GR	REVISED -				350	2010-050-1	COOK	44	20
	PLOT DATE = #DATE#	DATE - 10/14/11	REVISED -				CONTRACT NO. 60L26		ILLINOIS FED. AID PROJECT		
					SCALE: 1"= 50'	SHEET NO. OF SHEETS	STA. 530+00.00 TO STA. 545+00.00				