



HORIZ. 1"=40'
VERT. 1"=5'

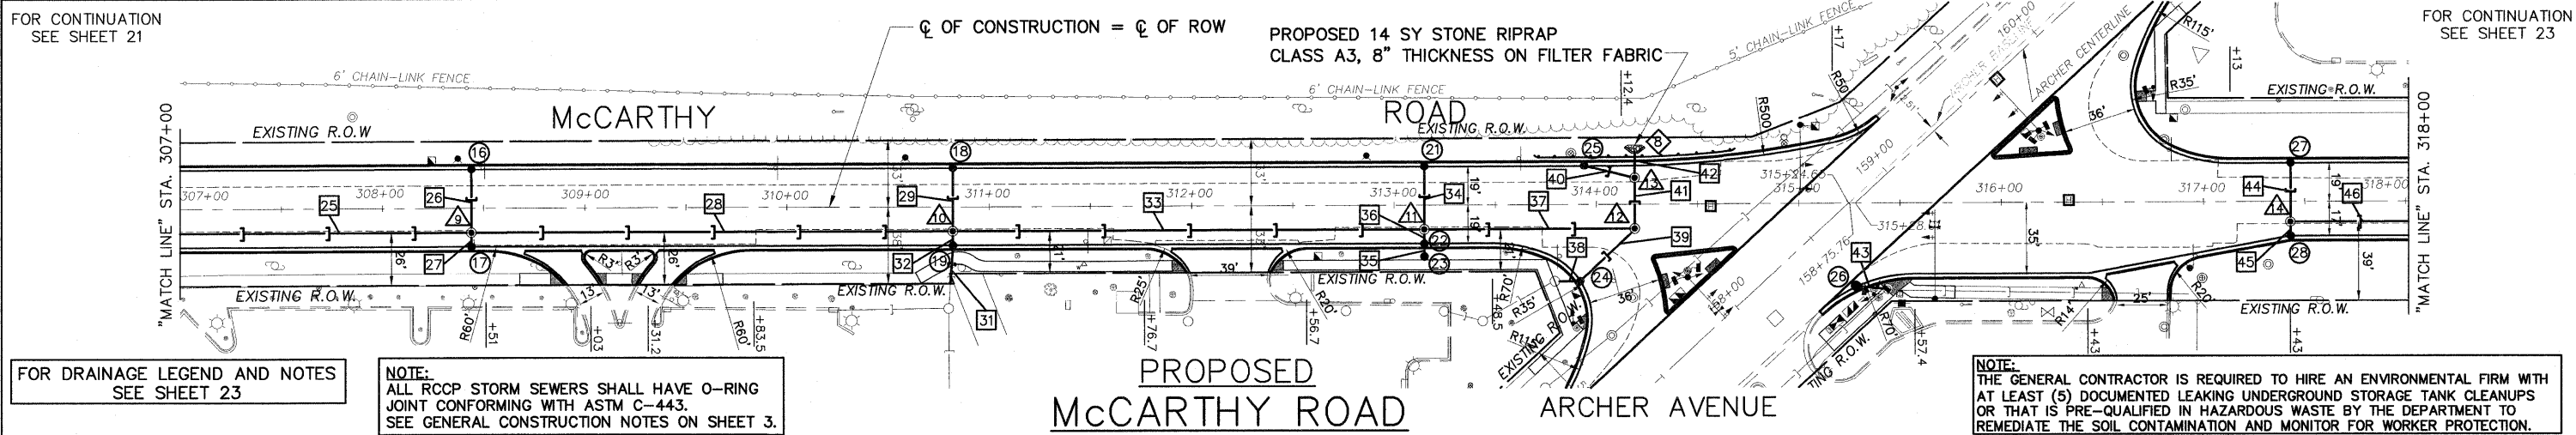

FOR DRAINAGE LEGEND AND NOTES
SEE SHEET 23

NOTE:
ALL RCCP STORM SEWERS SHALL HAVE O-RING
JOINT CONFORMING WITH ASTM C-443.
SEE GENERAL CONSTRUCTION NOTES ON SHEET 3.

NOTE:
THE GENERAL CONTRACTOR IS REQUIRED TO HIRE AN ENVIRONMENTAL FIRM WITH
AT LEAST (5) DOCUMENTED LEAKING UNDERGROUND STORAGE TANK CLEANUPS
OR THAT IS PRE-QUALIFIED IN HAZARDOUS WASTE BY THE DEPARTMENT TO
REMEDiate THE SOIL CONTAMINATION AND MONITOR FOR WORKER PROTECTION.

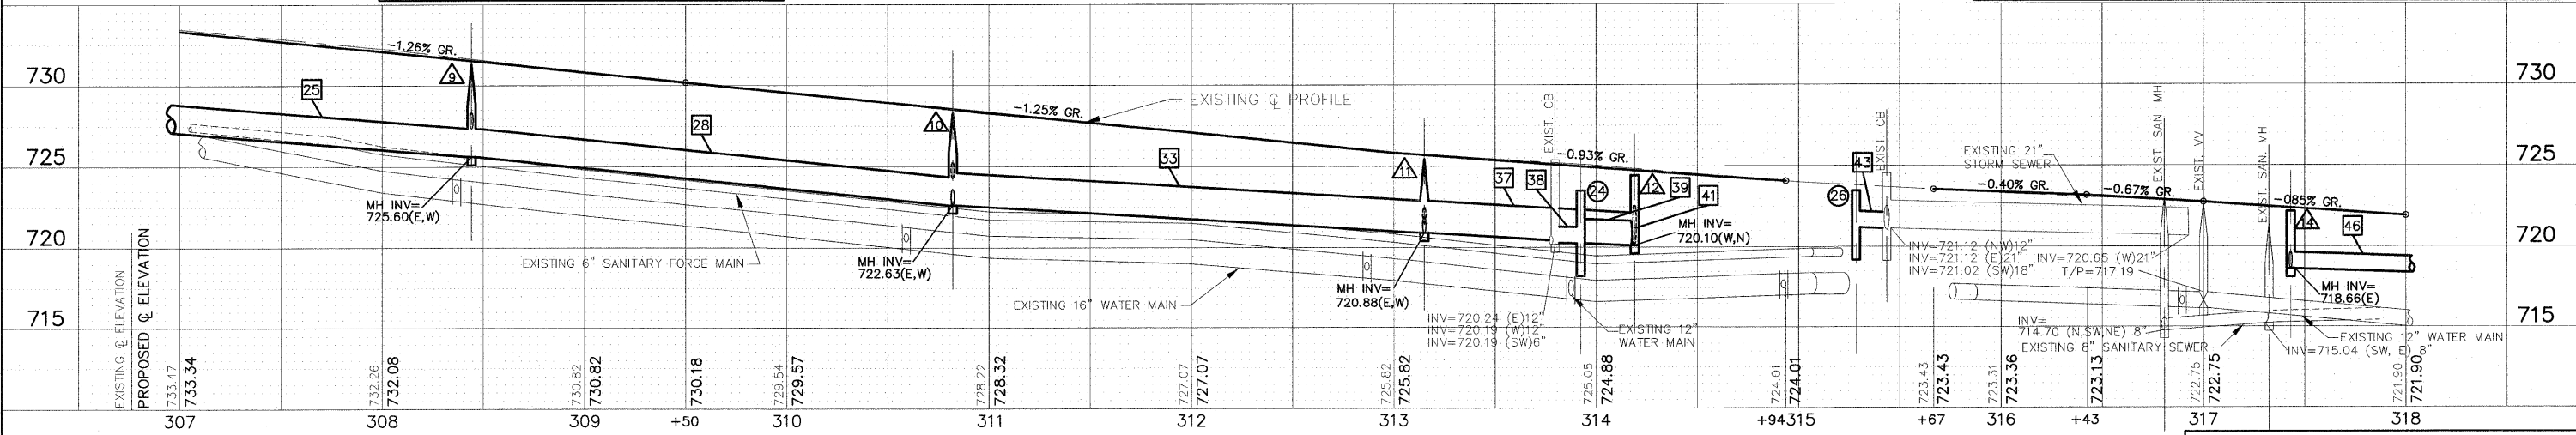

IMPORTANT!
FULL SIZE PLANS HAVE BEEN PREPARED USING STANDARD ENGINEERING SCALES.
REDUCED SIZED PLANS WILL NOT CONFORM TO STANDARD SCALES INDICATED IN TITLE BLOCK.

FOR TYPICAL CROSS SECTION
OF NEW PAVEMENT WORK
SEE SHEET 9



Frank Novotny & Associates, Inc.
Civil Engineers
Municipal Consultants
835 Midway Drive • Willowbrook, IL • 60527 • Telephone: (630) 887-9640 • Fax: (630) 887-0132
ILLINOIS PROFESSIONAL DESIGN FIRM NO. 184-00089

FILE NAME = FAU 1587 (McCARTHY ROAD) FAP 577 (ARCHER AVENUE) FAU 1024 (DERBY ROAD) CHANNELIZATION AND TRAFFIC SIGNAL INSTALLATION	USER NAME =	DESIGNED -- JLC	REVISED -- THK 3-17-11
PLOT SCALE =	CHECKED -- THK	DRAWN -- JFP-JEP	REVISED -- THK 9-21-11
PLOT DATE =	DATE -- 11/10		

STATE OF ILLINOIS
DEPARTMENT OF TRANSPORTATION

PLAN & PROFILE:
McCARTHY ROAD- (EXISTING AND PROPOSED ROADWAY DRAINAGE PLAN)
SCALE: AS NOTED | SHEET NO. OF SHEETS | STA. 307+00 TO STA. 318+00

F.A. R.T.E. VAR	SECTION	COUNTY	TOTAL SHEETS	SHEET NO.
02-00055-00-WR		COOK	84	22
CONTRACT NO. 63557				
FED. ROAD DIST. NO. ILLINOIS FED. AID PROJECT HPP-M-8003(504)				