


STATE OF ILLINOIS
DEPARTMENT OF TRANSPORTATION
DIVISION OF HIGHWAYS
PLANS FOR PROPOSED
STU AND EDP PROJECT
SECTION 10-00054-00-PV CITY OF FLORA
JOB NO. C-97-072-12
PROJECT NO. M-5023(011)
WORTHY STREET - F.A.U. 8526

ROUTE	SECTION	CITY	TOTAL SHEETS	SHEET NO.
F.A.U. 8526	10-00054-00-PV	FLORA	34	1
CONTRACT NO. 95672		ILLINOIS	PROJECT M-5023(011)	

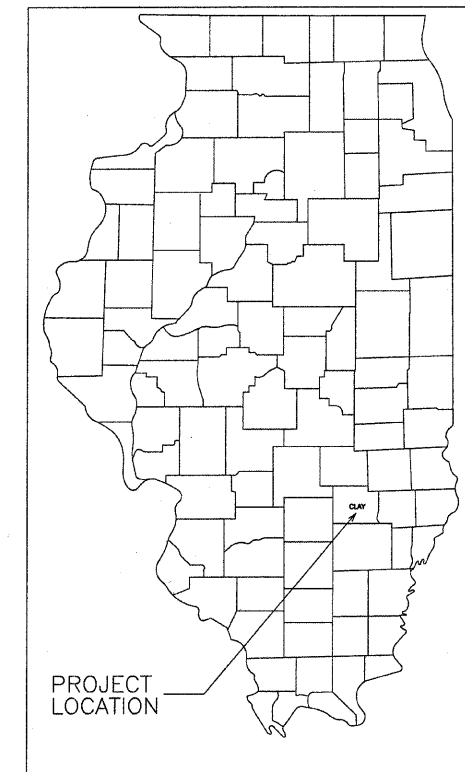


INDEX OF SHEETS

SHEET	ITEM
1	COVER SHEET
2	TYPICAL SECTIONS
3	SUMMARY OF QUANTITIES
4-6	DRAINAGE STRUCTURES / STORM SEWER
7-11	PLAN & PROFILE
12-14	INTERSECTION DETAILS
15-16	EROSION CONTROL
17	PUMP STATION DETAIL
18-34	CROSS SECTIONS
	STANDARD 000001-06
	STANDARD 280001-06
	STANDARD 420001-07
	STANDARD 424001-06
	STANDARD 424011
	STANDARD 424021
	STANDARD 424026
	STANDARD 602301-03
	STANDARD 602306-03
	STANDARD 602401-03
	STANDARD 602406-05
	STANDARD 602601-02
	STANDARD 602701-02
	STANDARD 604001-03
	STANDARD 604006-04
	STANDARD 604011-04
	STANDARD 604036-02
	STANDARD 604086-02
	STANDARD 606001-04
	STANDARD 701006-03
	STANDARD 701301-04
	STANDARD 701311-03
	STANDARD 701501-06
	STANDARD 701801-05
	STANDARD 701901-02
	STANDARD 780001-03
	STANDARD BLR 10-6
	STANDARD BLR 21-9
	STANDARD BLR 22-7

PLAN	0' 20' 40'
PROFILE HOR.	0' 20' 40'
PROFILE VERT.	0' 5' 10'
CROSS SECTIONS	
HOR.	0' 5' 10'
VERT.	0' 5' 10'

Joint Utility Locating Information for Excavators

JULIE 1-800-892-0123

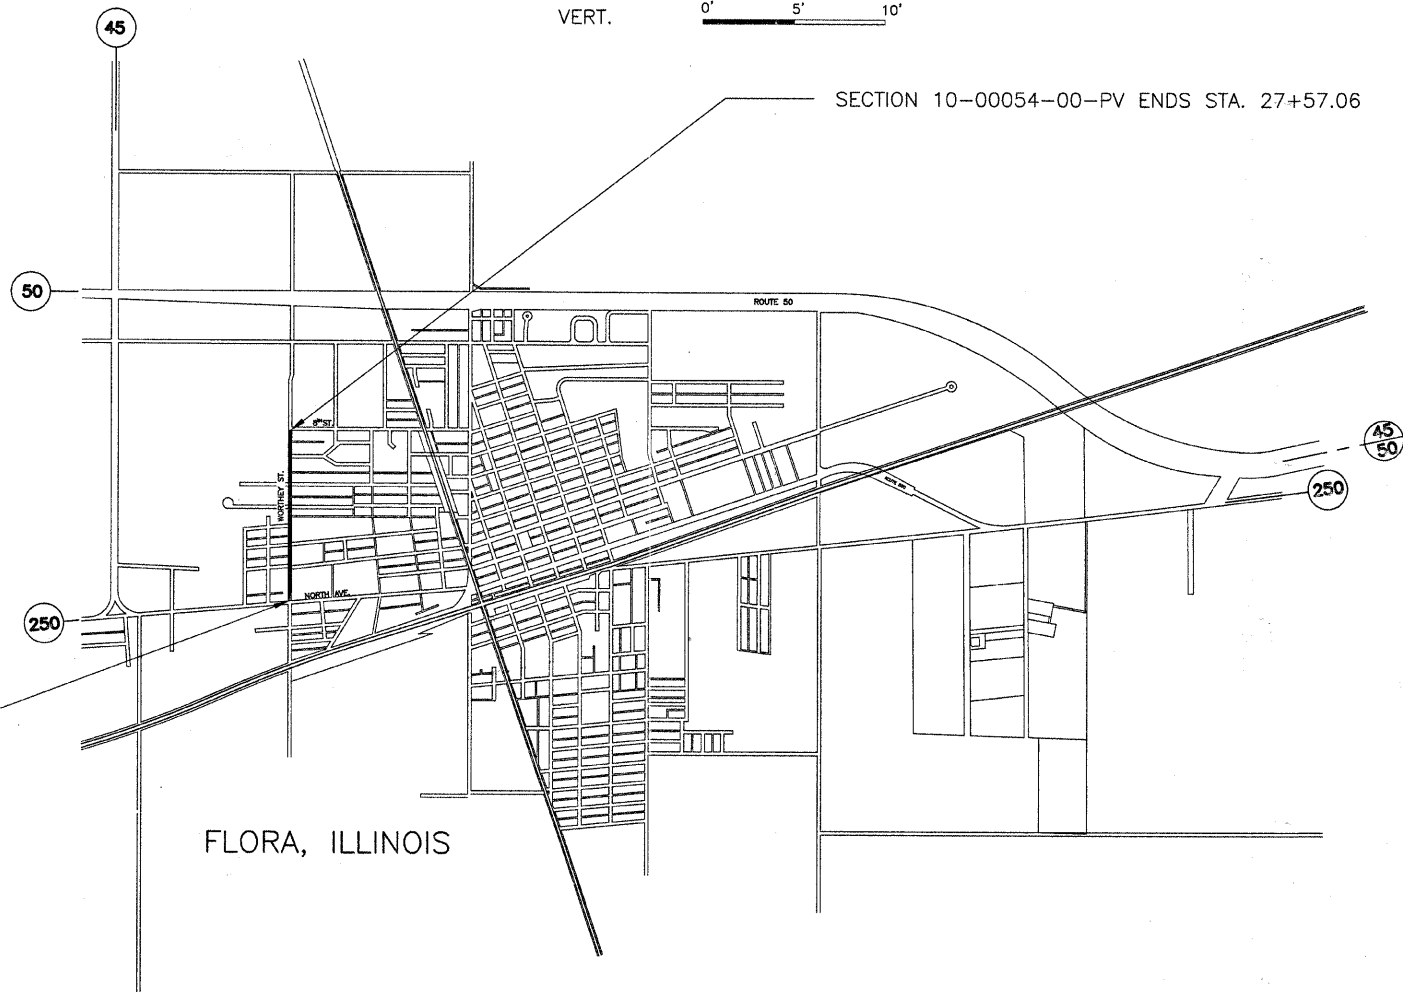

FLORA, ILLINOIS

NET LENGTH SECTION 10-00054-00-PV = 2648.33 FEET = 0.502 MILE

SECTION 10-00054-00-PV BEGINS STA. 1+08.73

CONTRACT NO. 95672

URBAN COLLECTOR
ADT = 2075
DESIGN SPEED = 30 M.P.H.

Tom A. Charleston
Ill. Reg. Prof. Eng. # 29673
1-9-2012
Lic. Expires 11/30/13



CHARLESTON ENGINEERING, INC.
CONSULTING ENGINEERS
105 NORTH KITCHELL
P.O. BOX 397
OLNEY, ILLINOIS 62450
(618) 392-0736
ILLINOIS DEPARTMENT OF PROFESSIONAL REGULATION REGISTRATION #184 003513

APPROVED 1-9 2012
Bob D'Arco
MAYOR - CITY OF FLORA

STATE OF ILLINOIS
DEPARTMENT OF TRANSPORTATION

PASSED 1-19 2012
Maureen Kaut
DISTRICT SEVEN ENGINEER OF
LOCAL ROADS AND STREETS

Releasing For
Bid Based on
Limited Review

1-19 2012
Tom R. D'Arco
DEPUTY DIRECTOR OF HIGHWAYS
REGION FOUR ENGINEER