
 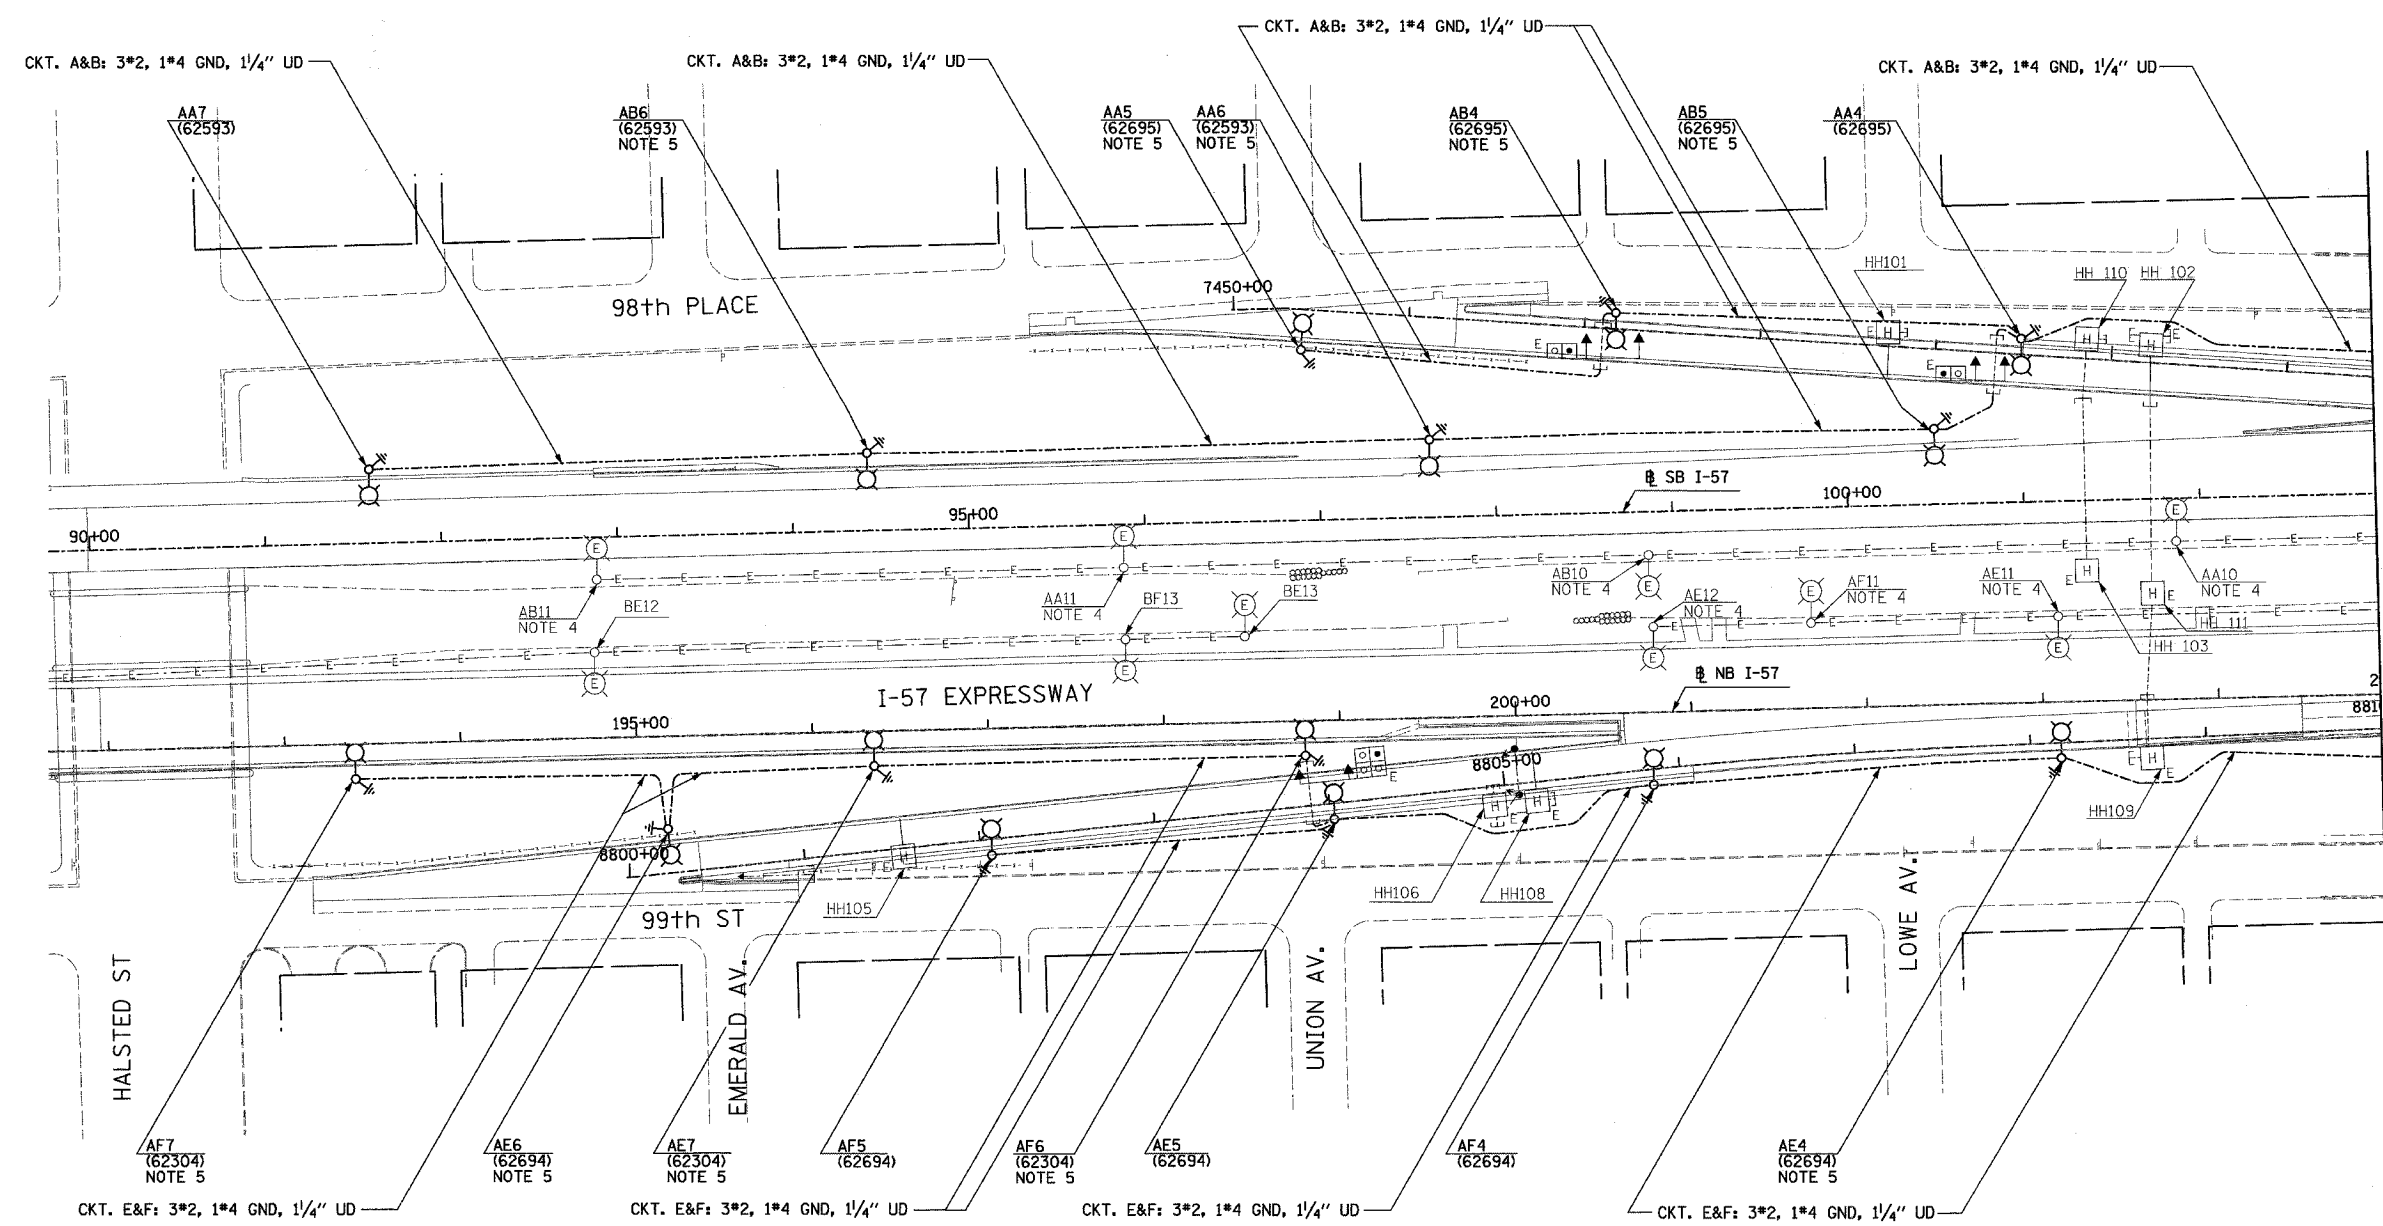



F.A.I. RTE.	SECTION	COUNTY	TOTAL SHEETS	SHEET NO.
94	*	COOK	36	25
STA. 89+90		TO STA. 103+00		
FED. ROAD DIST. NO.	ILLINOIS	FED. AID PROJECT		
• 2005-014L			62937	



- LEGEND**
- EXISTING LIGHTING UNIT TO REMAIN
 - EXISTING HANDHOLE (PROVIDED UNDER THE SEPARATE CONTRACT)
 - UNDERGROUND REINFORCED CONCRETE ENCASED CNC DUCTBANK. (PROVIDED UNDER SEPARATE CONTRACT).
 - EXISTING LIGHTING CIRCUIT
 - FOUNDATION AND GROUND ROD (PROVIDED UNDER SEPARATE CONTRACT)
 - LIGHTING UNIT: 47'-6" POLE, 15 FT. M.A. 310W HPS M-C-III LUMINAIRE.
 - DIRECT BURIAL CABLE UNDERGROUND WITHOUT ENCASUREMENT

- NOTES:**
1. UNLESS NOTED OTHERWISE ALL ITEMS AND WORK SHOWN IN HEAVY LINE WEIGHT ON THIS DRAWING ARE PROPOSED NEW ITEMS OF WORK.
 2. FOUNDATIONS AND ASSOCIATED GROUND RODS FOR CONVENTIONAL LIGHT POLES SHALL BE FURNISHED UNDER IDOT CIVIL CONTRACTS NOTED IN BRACKETS.
 3. CONTRACTOR TO PROVIDE POLE, LUMINAIRE, AND POLE WIRING AS PART OF THIS CONTRACT
 4. CONTRACTOR TO RELABEL LIGHT POLES LOCATED IN MEDIAN AS NOTED ON PLANS. THE COST TO RELABEL POLES IS CONSIDERED INCIDENTAL TO THE COST OF INSTALLING THE NEW LIGHTING SYSTEM.
 5. LIGHTING WITHOUT CONCRETE BARRIER WALL PROTECTION TO BE PROVIDED WITH BREAKAWAY TRANSFORMER BASE.

 MATCHLINE STA. 103+00
SEE SHEET RL-02



2D/RL-01

REVISIONS	
NAME	DATE

ILLINOIS DEPARTMENT OF TRANSPORTATION
F.A.I. 94 (DAN RYAN EXPRESSWAY)

ROADWAY LIGHTING PLANS
PROPOSED IMPROVEMENTS

SCALE: 1"=50' DRAWN BY: VG
DATE: JANUARY 13, 2006 CHECKED BY: TM

SINGH 300 W. ADAMS ST.
CHICAGO, IL 60606
SINGH & ASSOCIATES, INC. TEL: (312) 629-0240
CONSULTING ENGINEERS FAX: (312) 629-8449

2/14/2006 2:36:42 PM