


F.A.T. RTE.	SECTION	COUNTY	TOTAL SHEETS	SHEET NO.
80	(32, 47-4)K	KENDALL/GRUNDY	243	146
STA.		TO STA.		
FED. ROAD DIST. NO.	ILLINOIS	FED. AID PROJECT		
CONTRACT NO. 66294				

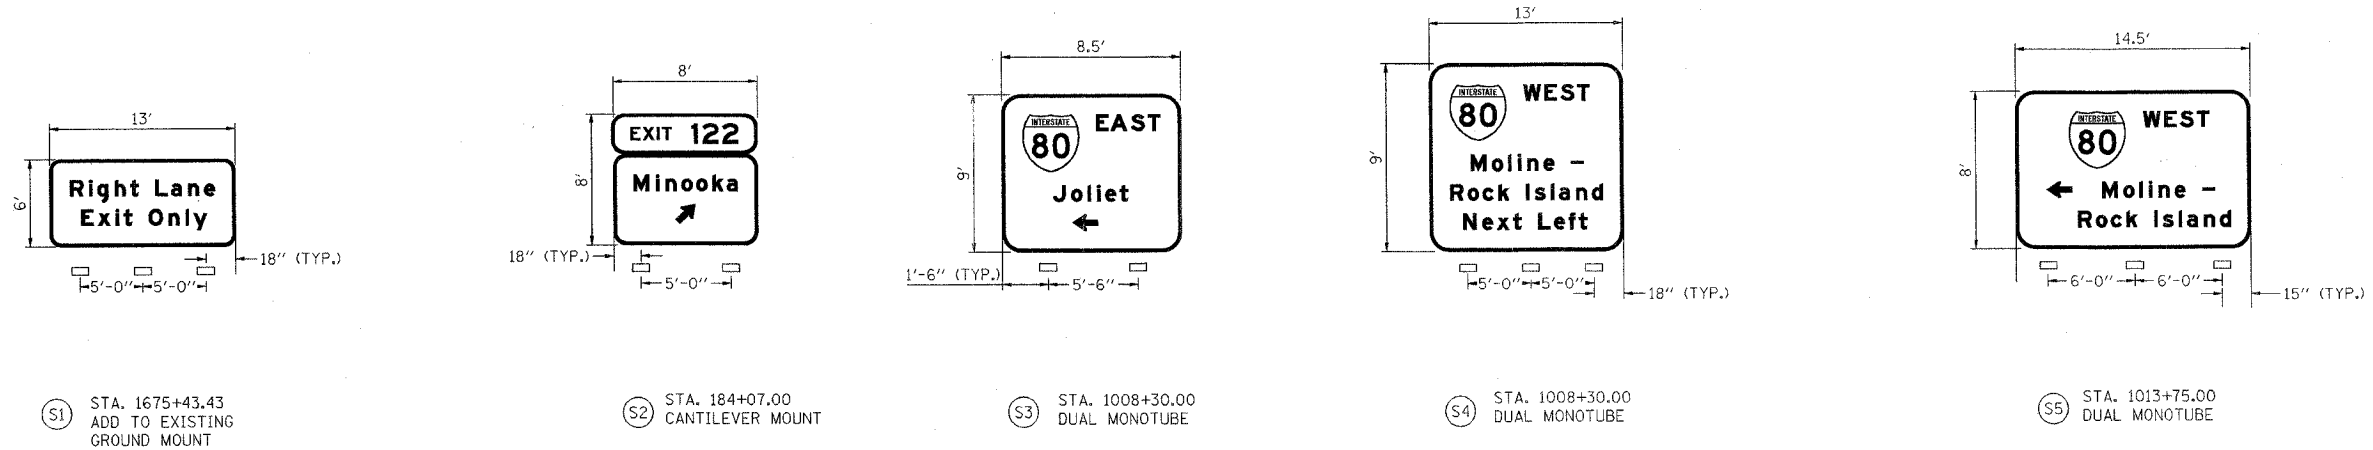


S1 STA. 1675+43.43
ADD TO EXISTING
GROUND MOUNT

S2 STA. 184+07.00
CANTILEVER MOUNT

S3 STA. 1008+30.00
DUAL MONOTUBE

S4 STA. 1008+30.00
DUAL MONOTUBE

S5 STA. 1013+75.00
DUAL MONOTUBE

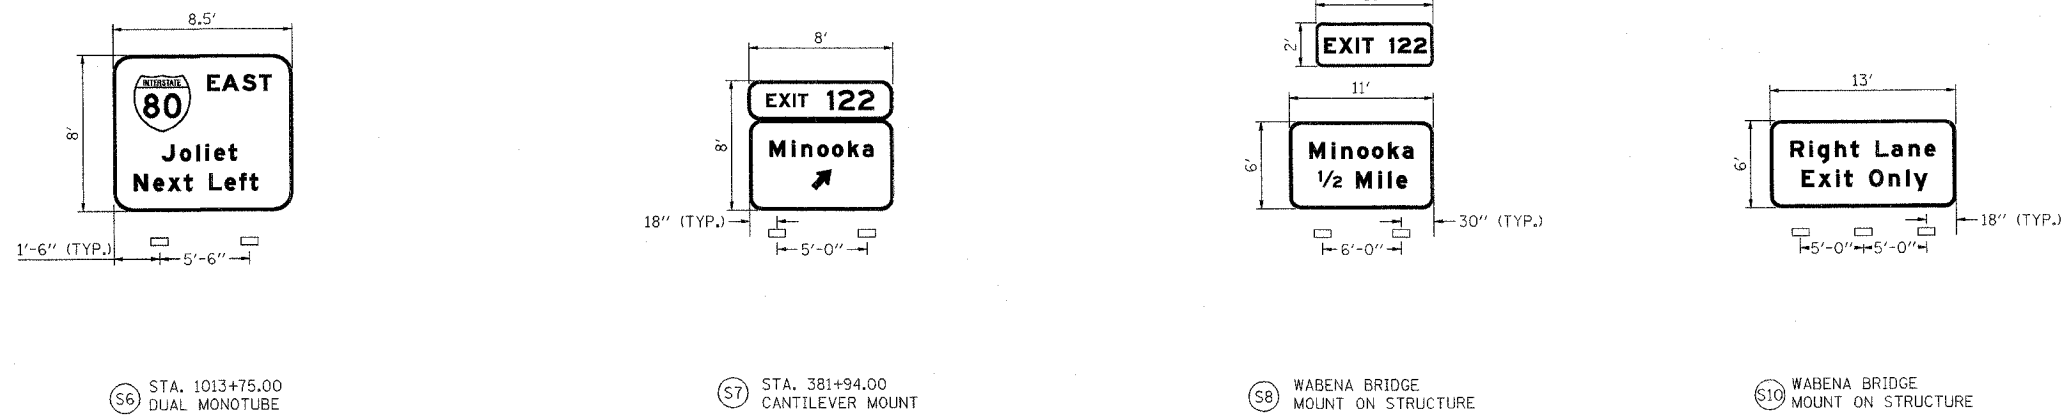

S6 STA. 1013+75.00
DUAL MONOTUBE

S7 STA. 381+94.00
CANTILEVER MOUNT

S8 WABENA BRIDGE
MOUNT ON STRUCTURE

S9 WABENA BRIDGE
MOUNT ON STRUCTURE
ON TOP OF SIGN S8

S10 WABENA BRIDGE
MOUNT ON STRUCTURE

□ SIGN LIGHTING LUMINAIRE MOUNTED ON THE SIGN WALKWAY STRUCTURE.

REVISIONS	
NAME	DATE

ILLINOIS DEPARTMENT OF TRANSPORTATION
FAI ROUTE 80 (I-80 AT MINOOKA INTERCHANGE)

PROPOSED SIGN LIGHTING PLAN

SCALE: NONE
DATE: 2/10/06
DRAWN BY: KGP/MAE
CHECKED BY: MAE/PKG

GO GANDHI AND ASSOCIATES, INC.
ENGINEERS AND PLANNERS
6035 N. NORTHWEST HIGHWAY
SUITE 306
CHICAGO, ILLINOIS 60631 TEL. (773) 774-6900

PATRICK
ENGINEERING INC.
LISLE, ILLINOIS