
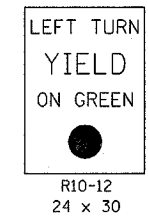
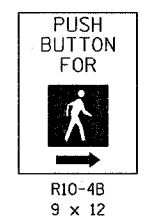
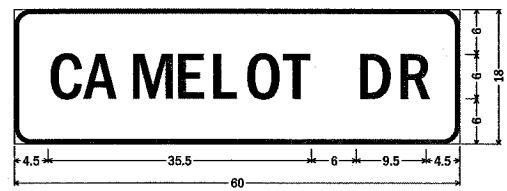



F.A.P. RTE.	SECTION	COUNTY	TOTAL SHEETS	SHEET NO.
600	31-1TS-1	MADISON	12	14
STA. _____		TO STA. _____		
FED. ROAD DIST. NO. _____ ILLINOIS FED. AID PROJECT				

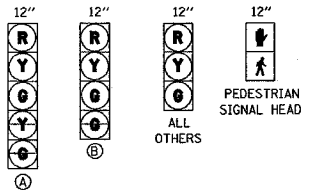

DETAIL D NOT TO SCALE

DETAIL E NOT TO SCALE



STREET NAME SIGN  
DETAIL C  
NOT TO SCALE

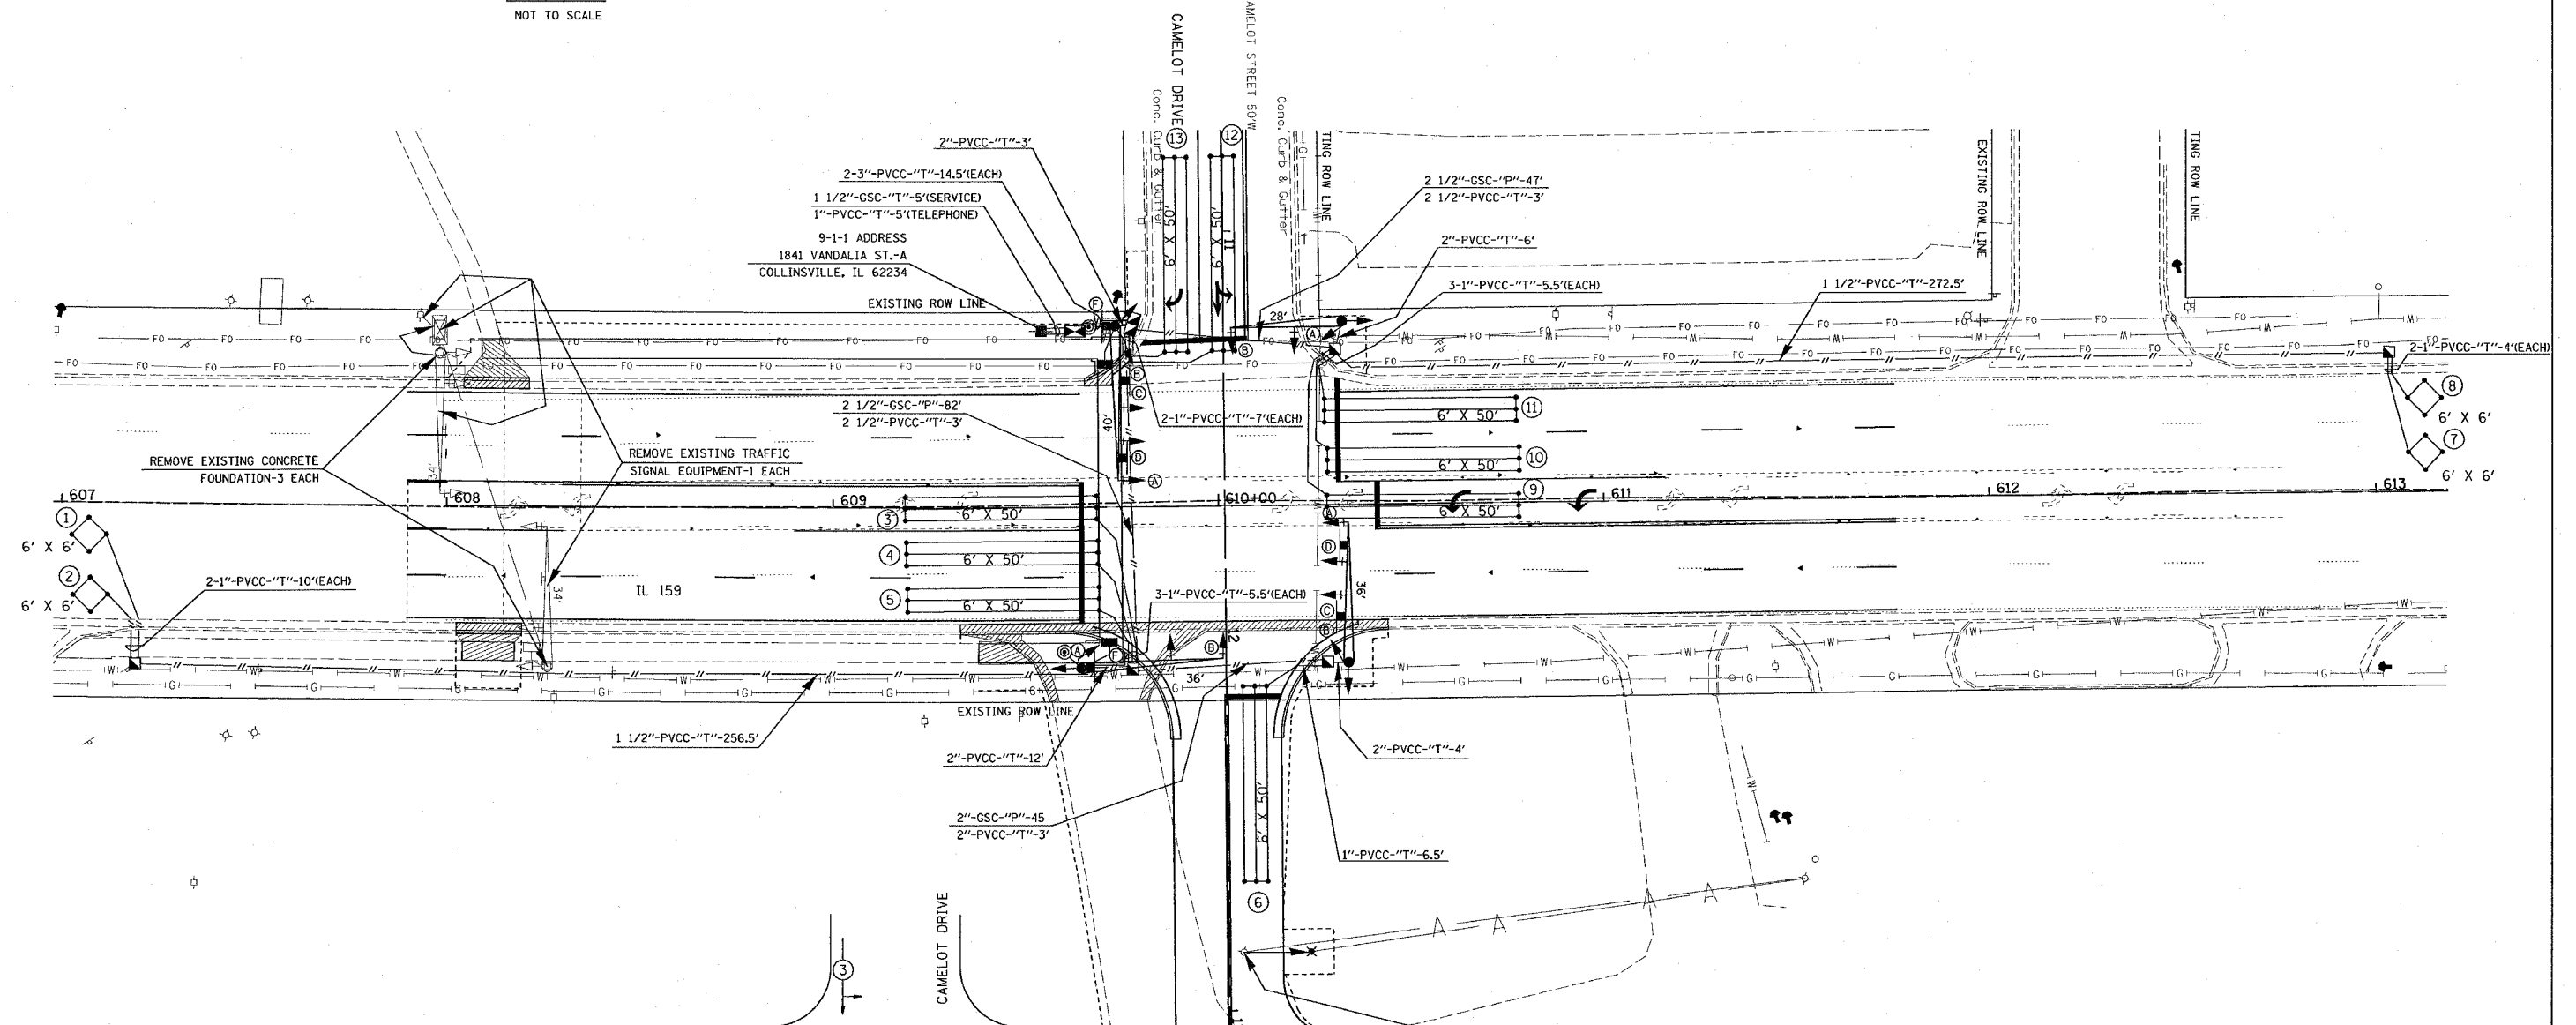

FULL-ACTUATED CONTROLLER, IN TYPE IV CABINET

PROPOSED SEQUENCE OF OPERATION								
PHASE	1	2	3	4	5	6	7	8
MOVEMENT	→	←	↕	↔	↔	→	←	NOT
CONCURRENT MOVEMENT PERMITTED	5 OR 6	5 OR 6	NONE	NONE	1 OR 2	1 OR 2	USED	USED

 • PERMITTED UPON PEDESTRIAN ACTUATION, ONLY.

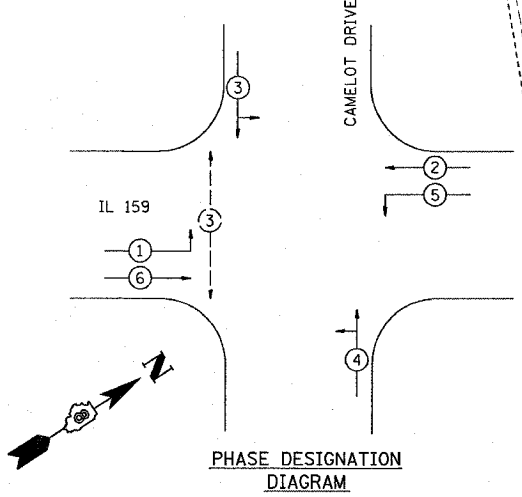

REVISIONS	
NAME	DATE

ILLINOIS DEPARTMENT OF TRANSPORTATION  
 IL 159 AND CAMELOT DRIVE  
 TRAFFIC SIGNAL PLAN  
 FAP 600  
 SECTION 30-1TS-1  
 MADISON COUNTY  
 SCALE: VERT. \_\_\_\_\_  
 DATE \_\_\_\_\_  
 DRAWN BY \_\_\_\_\_  
 CHECKED BY \_\_\_\_\_

PLOT DATE = 04/15/14  
 PLOT SCALE = AS SHOWN  
 REFERENCE = REF#