



FAH ROUTE	SECTION	COUNTY	TOTAL SHEETS	SHEET NO.
0306	*	WILL	118	58A
FHWA REGION NO.	ILLINOIS	PROJECT M-8003(200)	CONTRACT NO. 83825	
* 01-00029-00-FP				

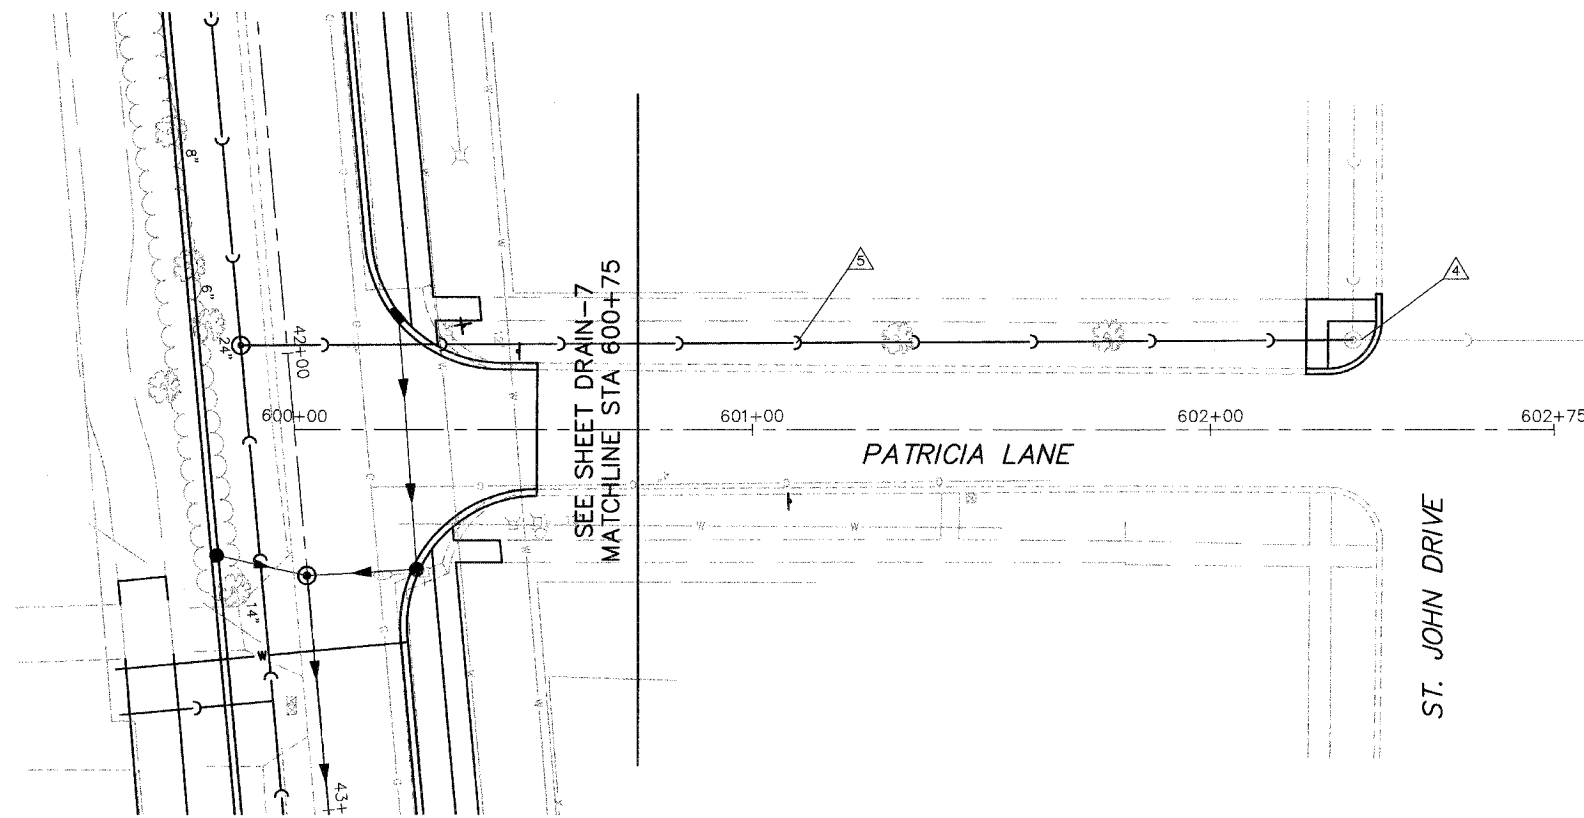

- △ STA 42+18, 232 FT. LT.
CONNECT TO EXISTING SANITARY MANHOLE
T/F=726.81
INV.=718.73(EXISTING)(N)
INV.=718.83(S)
- △ SANITARY SEWER, PVC SDR 26
240'-8" @ 0.4%
TBF=408.6 CY



DRAIN-11A

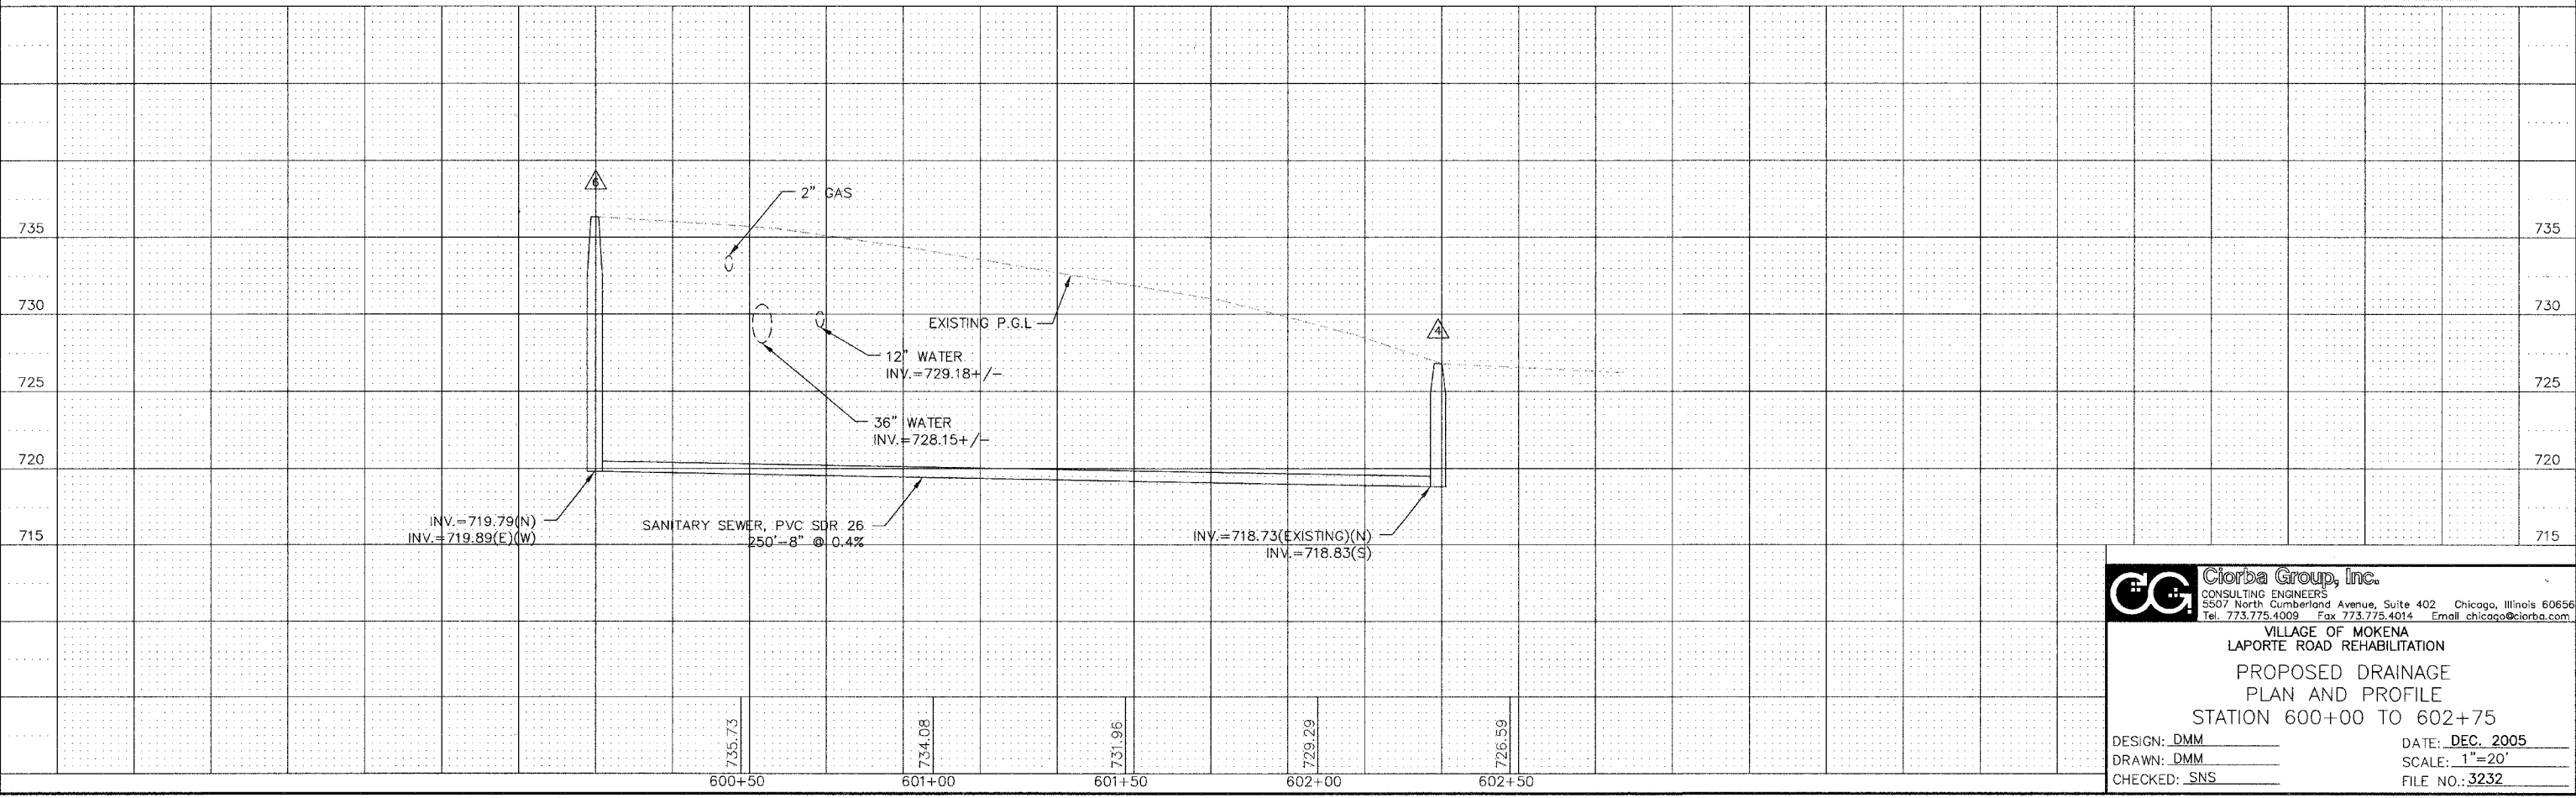

CGI Ciorba Group, Inc.
CONSULTING ENGINEERS
5507 North Cumberland Avenue, Suite 402 Chicago, Illinois 60656
Tel. 773.775.4009 Fax 773.775.4014 Email chicagoc@ciorga.com

VILLAGE OF MOKENA
LAPORTE ROAD REHABILITATION
PROPOSED DRAINAGE
PLAN AND PROFILE
STATION 600+00 TO 602+75
DESIGN: DMM
DRAWN: DMM
CHECKED: SNS
DATE: DEC. 2005
SCALE: 1"=20'
FILE NO.: 3232

PLOT DATE: 12/10/05 11:00 AM
 FILENAME: N:\PROJ\3232\Design\Drawings\3232-UTIL\11A.dwg