


STATE ROUTE 0306	SECTION *	COUNTY WILL	TOTAL SHEETS 118	SHEET NO. 75
FHWA REGION NO.		ILLINOIS	PROJECT M-8003(200)	
* 01-00029-00-FP			CONTRACT NO. 83825	

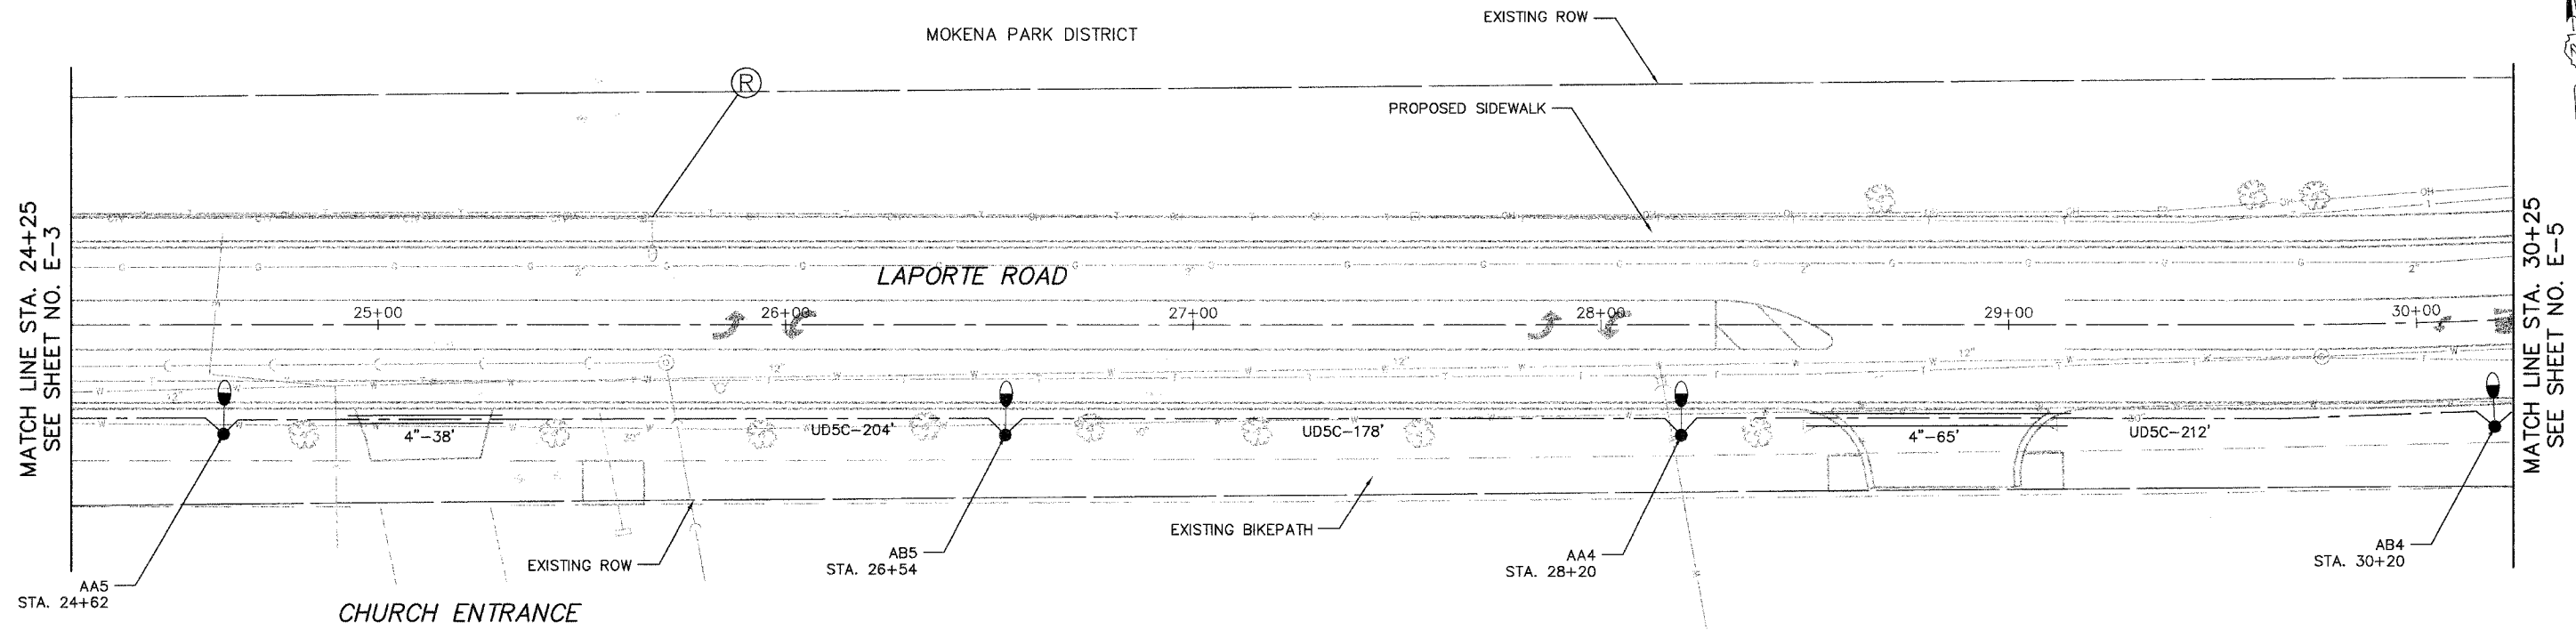

LEGEND

- LIGHT POLE, 35' M.H., 10' MAST ARM, AND LUMINAIRE, 200W, UNLESS OTHERWISE NOTED
- UTILITY POLE MOUNTED MAST ARM, LUMINAIRE TO BE REMOVED BY OTHERS
- EXISTING LIGHT POLE, SIZE AS NOTED
- UD5C-10' UNIT DUCT WITH 4-1/C NO. 4 AND 1/C NO. 6 GROUND 600V (EPR-TYPE RHW) 1-1/2" POLYTHYLENE AND LENGTH AS NOTED
- 4"-10' GALVANIZED STEEL CONDUIT, PUSHED, DIAMETER AND LENGTH AS NOTED
- PROPOSED LIGHTING CONTROLLER, 120/240V, 100A
- PROPOSED SERVICE CONNECTION
- OFFSET FOUNDATION

NOTES

1. ALL POLES SHALL BE OFFSET 8' FROM EDGE OF PAVEMENT TO CENTER OF POLE, UNLESS OTHERWISE NOTED.
2. EXISTING UTILITY POLE MOUNTED LUMINAIRES SHALL REMAIN IN USE DURING CONSTRUCTION.

E-4

Clorba Group, Inc.
 CONSULTING ENGINEERS
 5507 North Cumberland Avenue, Suite 402 Chicago, Illinois 60666
 Tel. 773.775.4008 Fax 773.775.4014 Email clorba@clorba.com

VILLAGE OF MOKENA
 LAPORTE ROAD REHABILITATION
 LAPORTE ROAD IMPROVEMENTS
 LIGHTING PLAN
 STATION 24+25 TO 30+25

DESIGN: KDM
 DRAWN: KDM
 CHECKED: JMV

DATE: DEC. 2005
 SCALE: 1"=20'
 FILE NO.: 3232

P:\L1\DATA\DEC 2005\2005-014\pm\FILENAME: MAPROJ\3232\Design\Lighting\2005-014.dwg