


LEGEND


- △ STRUCTURE NUMBER
- PIPE NUMBER

SEE THE FOLLOWING SHEET FOR
STRUCTURE AND PIPE SCHEDULES

F.A. RTE.	SECTION	COUNTY	CONTRACT NO.
FAU 6579	02-00065-00-PV	PEORIA	89358
FED. RD. DIST. NO.	ILLINOIS	PROJECT NO. M 503 102	

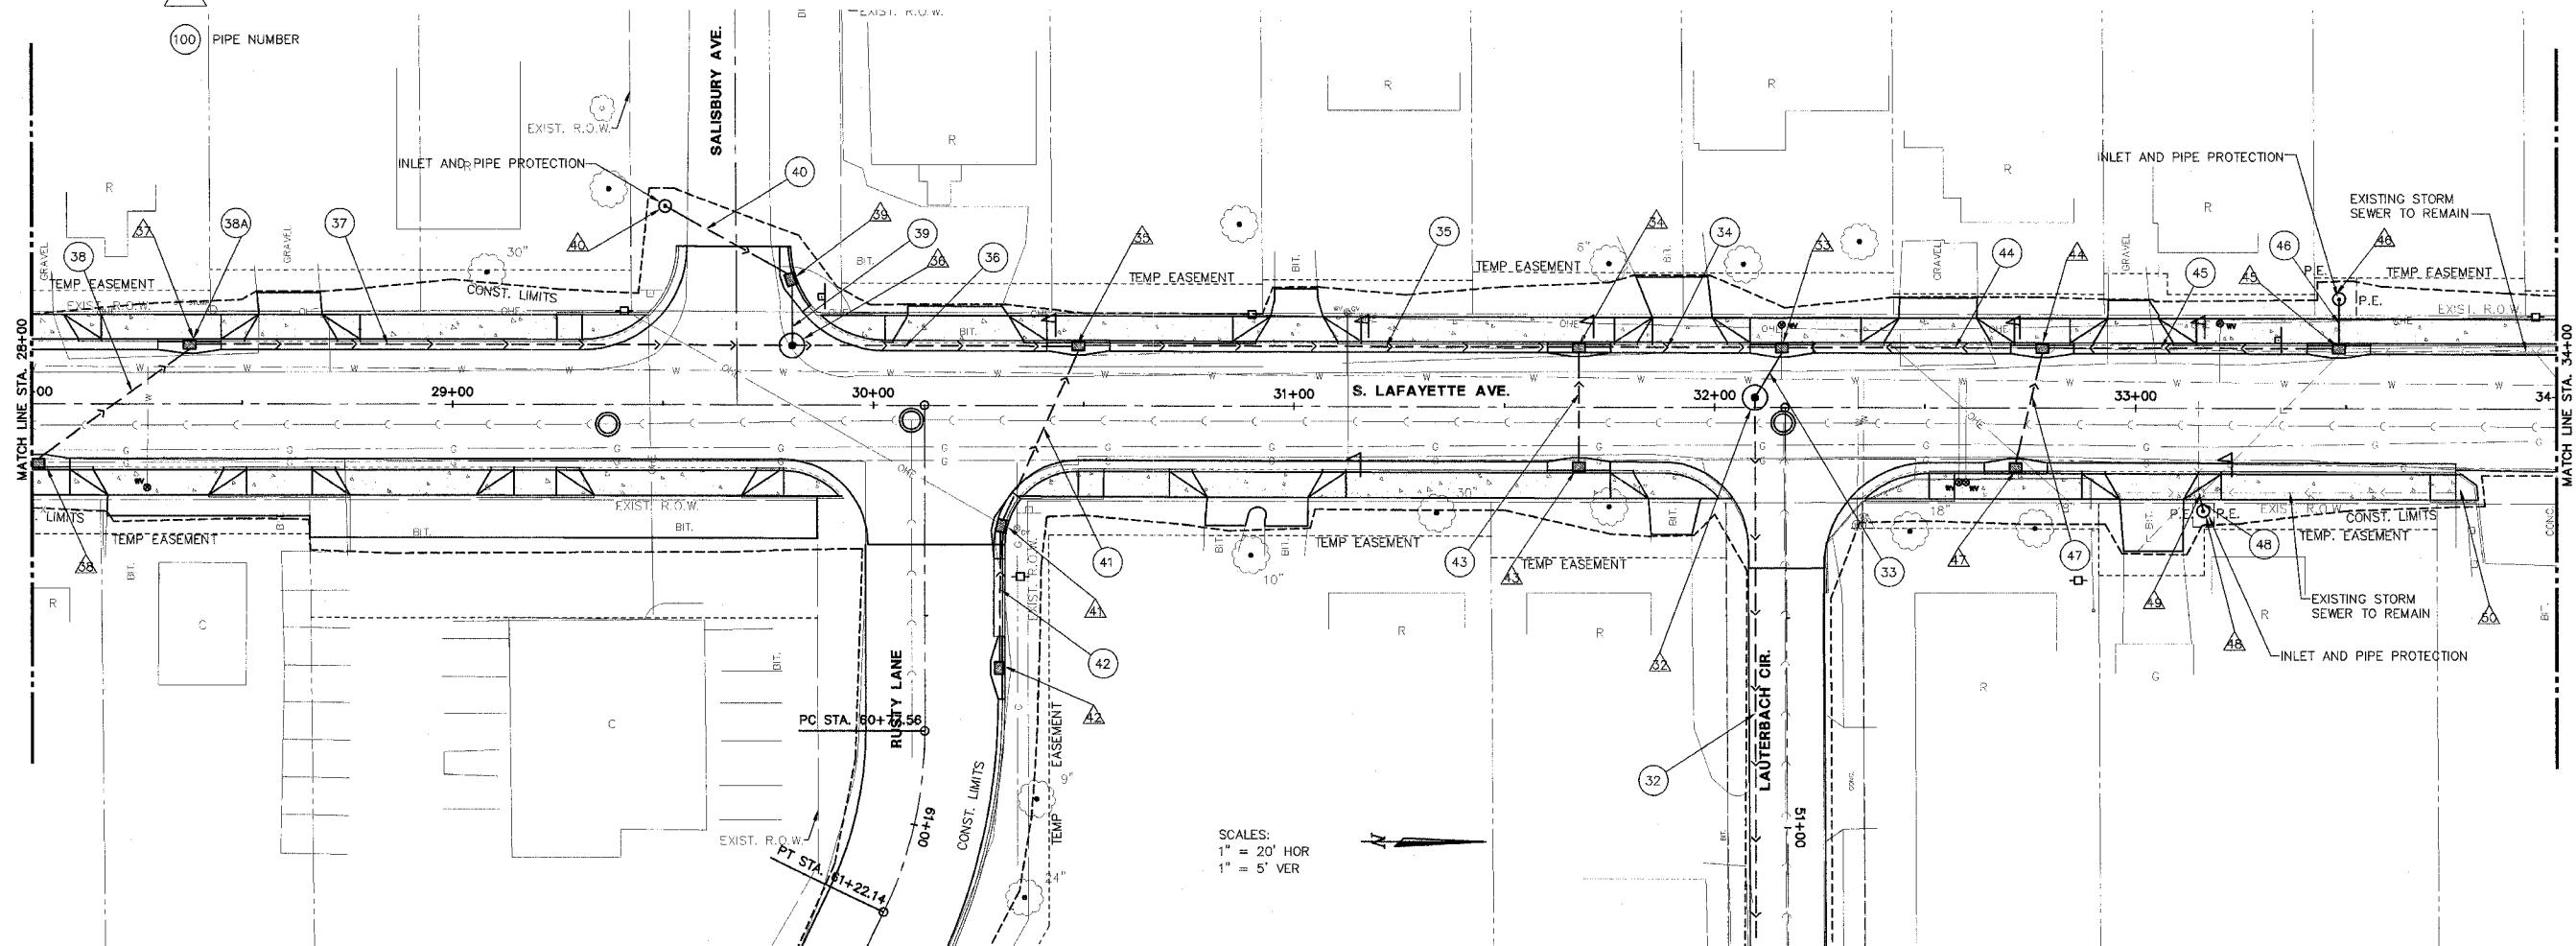

SCALES:
1" = 20' HOR
1" = 5' VER

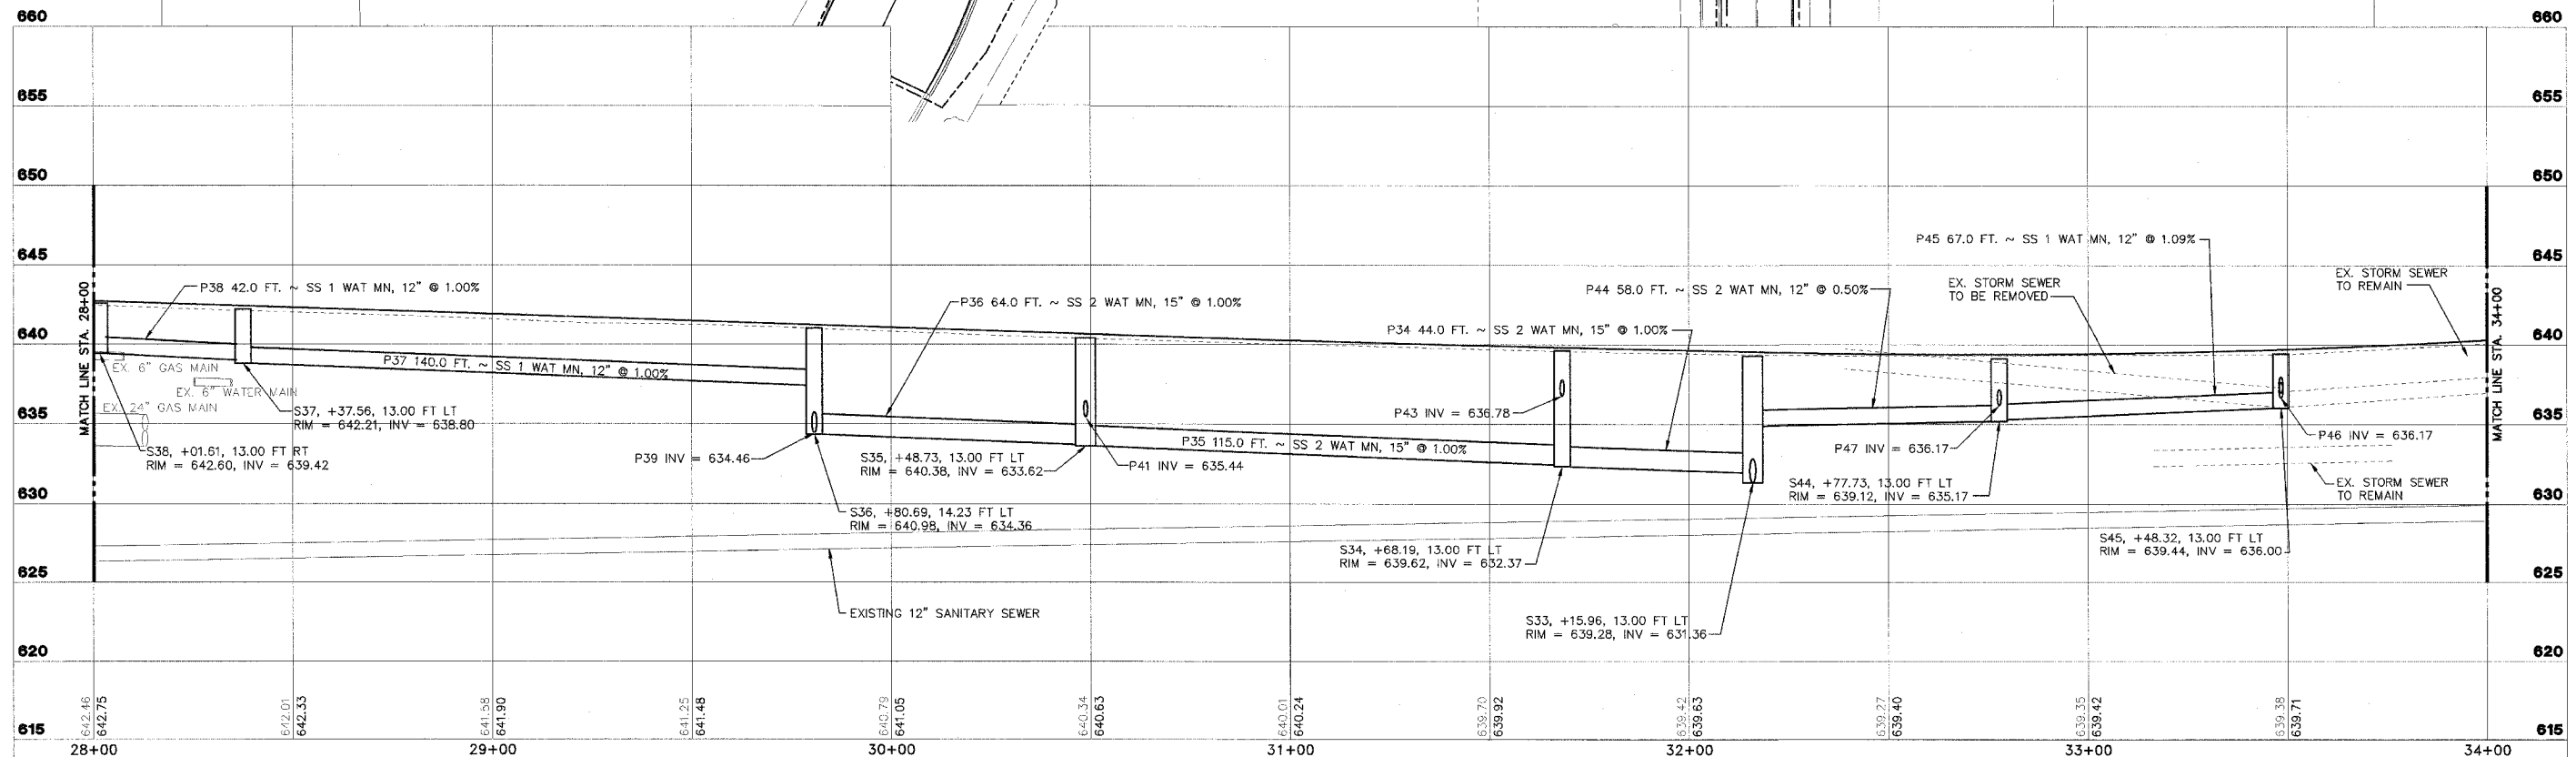

LAFAYETTE AVE.
BARTONVILLE IL.

**DRAINAGE
PLAN AND PROFILE**
STA. 28+00 TO STA. 34+00

SURVEY	CHECKED	ISSUE DATE
DESIGN	APPROVED	PRELIM. DATE
DRAWN	CSA	PROJECT NO.

SHEET
34
OF
83

L:\194410001\DWG\DR04.DWG, LAYOUT 1.dwg