




F.A. RTE.	SECTION	COUNTY	CONTRACT NO.
FAU 6579	02-00065-00-PV	PEORIA	89358
FED. RD. DIST. NO.	ILLINOIS PROJECT NO. M 503 102		

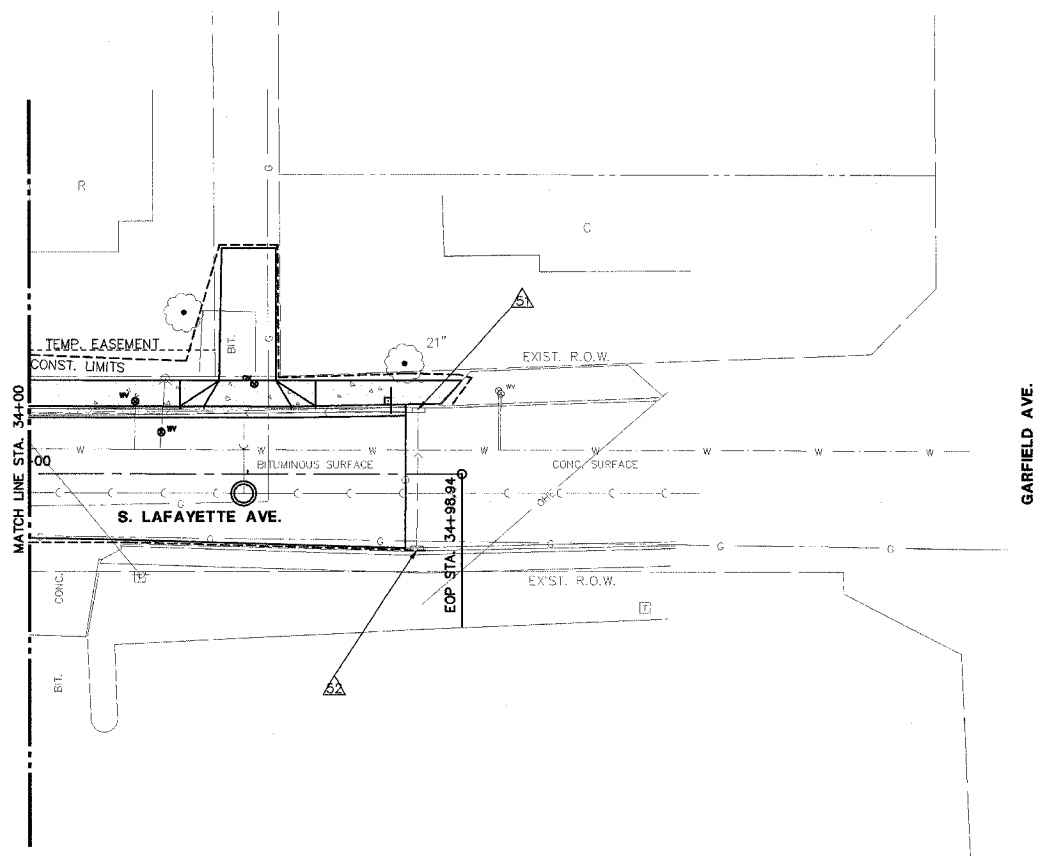

STR. NO.	STATION	OFFSET	RT/LT	TYPE	F&G	RM. BL.	INV. N.	INV. S.	INV. E.	INV. W.	REMARKS
51	STA. 34+88.89	14.74	LT	INLET ADJUST WITH NEW TG1 F&G	DIAGONAL	640.91					
52	STA. 34+88.89	17.02	RT	INLET ADJUST WITH NEW TG1 F&G	DIAGONAL	641.04					

SCALES:
 1" = 20' HOR
 1" = 5' VER

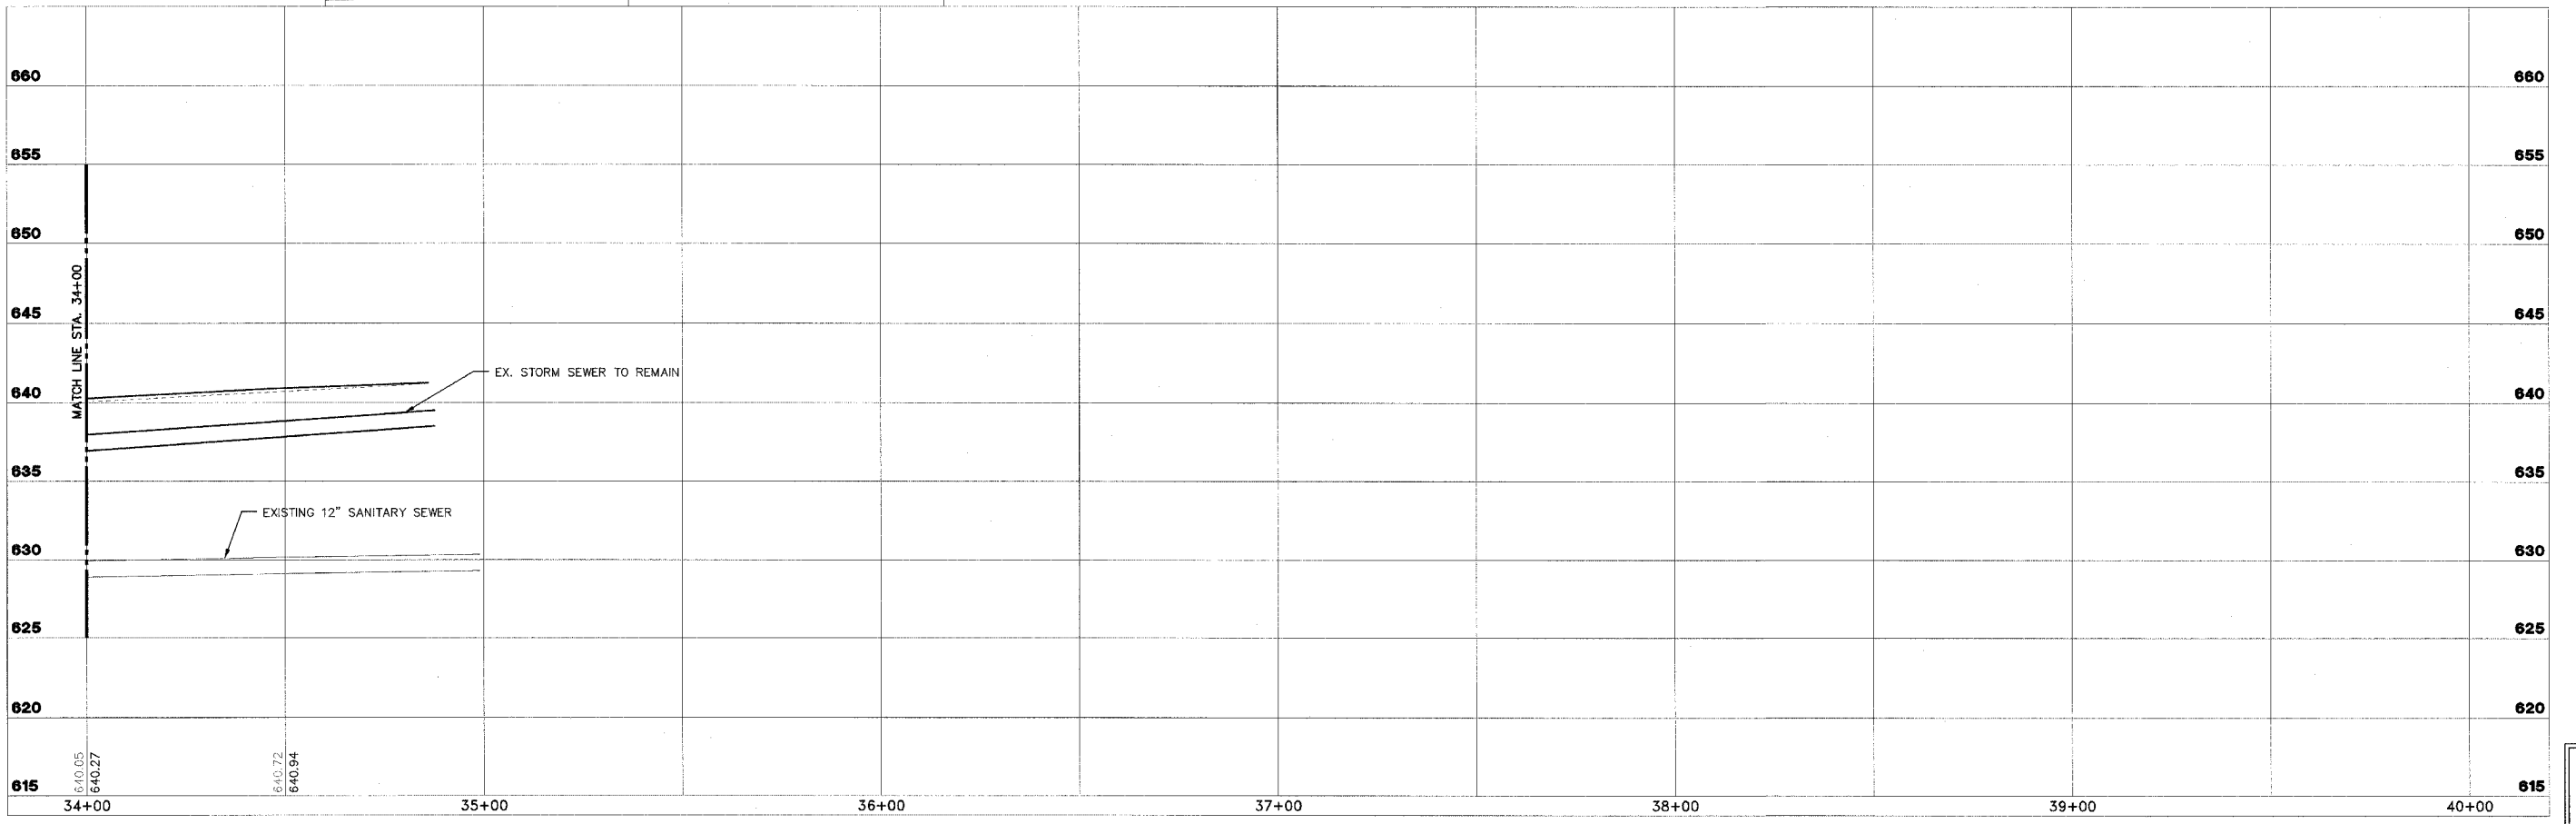



STS CONSULTANTS
 111 NE Jefferson Ave.
 Peoria, Illinois 61602
 PH: (309) 676-8464
 FAX: (309) 676-3445
 IL Design Firm Reg. No. 184-001518

**LAFAYETTE AVE.
 BARTONVILLE IL.**

**DRAINAGE
 PLAN AND PROFILE
 STA. 34+00 TO STA. 34+86.02**

SURVEY	CHECKED
DESIGN	APPROVED
DRAWN	CSA

ISSUE DATE: 01/06/06
 PRELIM. DATE: 11/21/05
 PROJECT NO.: BART0001

SHEET
36
 OF
83