

SECTION	COUNTY	TOTAL SHEETS	SHEET NO.
01-00088-00-WR	CHAMPAIGN	21	1
STA.	TO STA.		
F.H.W.A. REG.	ILLINOIS	PROJECT	

INDEX OF SHEETS



SHEET NO.	DESCRIPTION
1	COVER SHEET
2	SUMMARY OF QUANTITIES
3	GENERAL NOTES AND LEGEND
4	TYPICAL SECTIONS
5-6	SCHEDULES OF QUANTITIES
7-8	REMOVAL SHEETS
9-10	PLAN SHEETS
11-12	PROFILE SHEETS
14-16	DETAIL SHEETS
17-21	CROSS SECTIONS

# STATE OF ILLINOIS DEPARTMENT OF TRANSPORTATION PLANS FOR PROPOSED FEDERAL AID STREET IMPROVEMENT

VILLAGE OF RANTOUL  
LON DRIVE. - F.A.U. 7082  
SECTION: 01-00088-00-WR  
CHAMPAIGN COUNTY  
PROJECT NO. M-5059(011)  
C-95-056-01

ILLINOIS DEPT. OF TRANSPORTATION  
STANDARD DRAWINGS


STANDARD NO.	DESCRIPTION
280001-02	TEMPORARY EROSION CONTROL SYSTEMS
424001-04	CURB RAMPS FOR SIDEWALKS
442201-01	CLASS C AND D PATCHES
602301-01	INLET, TYPE A
602306-01	INLET, TYPE B
602401-01	MANHOLE, TYPE A
602406-02	MANHOLE, TYPE A, 72" DIAMETER
602601	PRC FLAT SLAB TOP
602701-01	MANHOLE STEPS
604001-02	FRAME AND LIDS, TYPE 1
604006-02	FRAME AND GRATE, TYPE 3
604036-01	GRATE, TYPE 8
606001-02	CONC. CURB TYPE B AND COMB. CONCRETE CURB AND GUTTER
701501-03	URBAN LANE CLOSURE, 2L, 2W, UNDIVIDED
701801-03	LANE CLOSURE, MULTILANE 1W OR 2W CROSSWALK OR SIDEWALK CLOSURE
702001-06	TRAFFIC CONTROL DEVICES
878001-04	CONCRETE FOUNDATION DETAILS
880006	TRAFFIC SIGNAL MOUNTING DETAILS
886001	DETECTOR LOOP INSTALLATIONS
886006	TYPICAL LAYOUT FOR DETECTION LOOPS
BLR 25	TYPE 1A BARRICADE FOR NON-NHS ROUTES

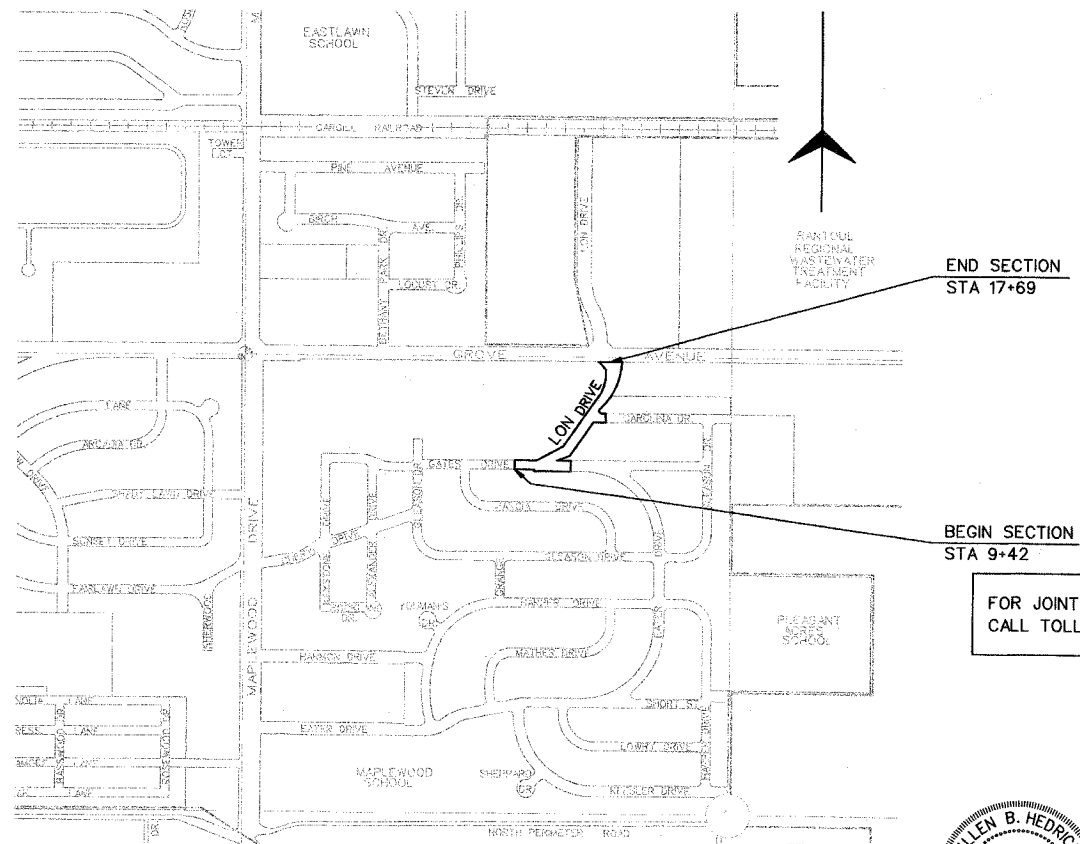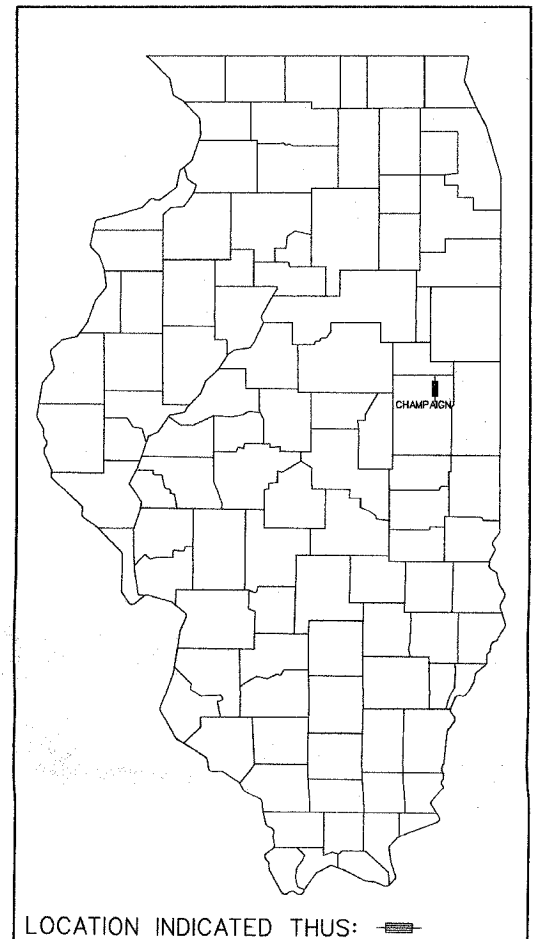

END SECTION  
STA 17+69

BEGIN SECTION  
STA 9+42

FOR JOINT UTILITY INFORMATION  
CALL TOLL FREE 1-800-892-0123

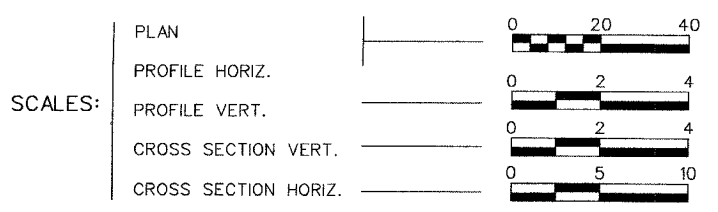

FUNCTIONAL CLASSIFICATION - LOCAL ROAD ADT = 1150

SCALE: 1" = 500'

LENGTH OF PROJECT - LON DRIVE = 827 FEET (0.16 MILES)


APPROVED 12-12-2005  
*Greg Hazel*  
GREG HAZEL, DIRECTOR OF PUBLIC WORKS, VILLAGE OF RANTOUL

APPROVED 12-12-2005  
*Neal Williams*  
NEAL WILLIAMS, MAYOR, VILLAGE OF RANTOUL

PASSED 11/27-2005  
*John A. Se...*  
DISTRICT FIVE ENGINEER OF LOCAL ROADS & STREETS

RELEASING FOR BID BASED ON LIMITED REVIEW DEC 27-2005  
*John A. Se...*  
DEPUTY DIRECTOR OF HIGHWAYS, REGION THREE ENGINEER

STATE OF ILLINOIS  
DEPARTMENT OF TRANSPORTATION

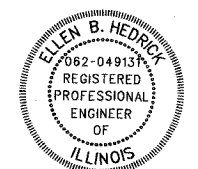

*Ellen B. Hedrick 12-9-05*  
ELLEN B. HEDRICK, PROJECT ENGINEER  
ILLINOIS REGISTERED PROFESSIONAL ENGINEER NUMBER 062-049131  
LICENSE EXPIRES 11-30-07

Sodemann and Associates, Inc.  
340 NORTH NEIL STREET  
POST OFFICE BOX 557  
CHAMPAIGN, ILLINOIS 61824-0557  
TEL 217 352-7688 FAX 217 352-7922  
ENGINEERING / ANALYSIS / MANAGEMENT

