


F.A.I. RTE.	SECTION	COUNTY	TOTAL SHEETS	SHEET NO.
90/94	2003-0311	COOK	976	54
STA.	TO STA.			
FED. ROAD DIST. NO. 1 ILLINOIS FED. AID PROJECT				


62583

**NOTES:**


1. SEE DRAWINGS ME-01 AND ME-02 FOR ELECTRICAL SYMBOLS AND ABBREVIATIONS.
2. SEE ROADWAY LIGHTING PLANS FOR PROPOSED INSTALLATION LOCATIONS OF THE WOOD POLES.
3. GROUND RODS SHALL BE INSTALLED FOR ALL WOOD POLES USED FOR TEMPORARY LIGHTING UNITS AND ALL TEMPORARY WOOD POLES AT THE END OF AN AERIAL RUN THAT CONNECT TO LIGHTING CONTROLLERS AS SHOWN IN DETAIL ME-16B.

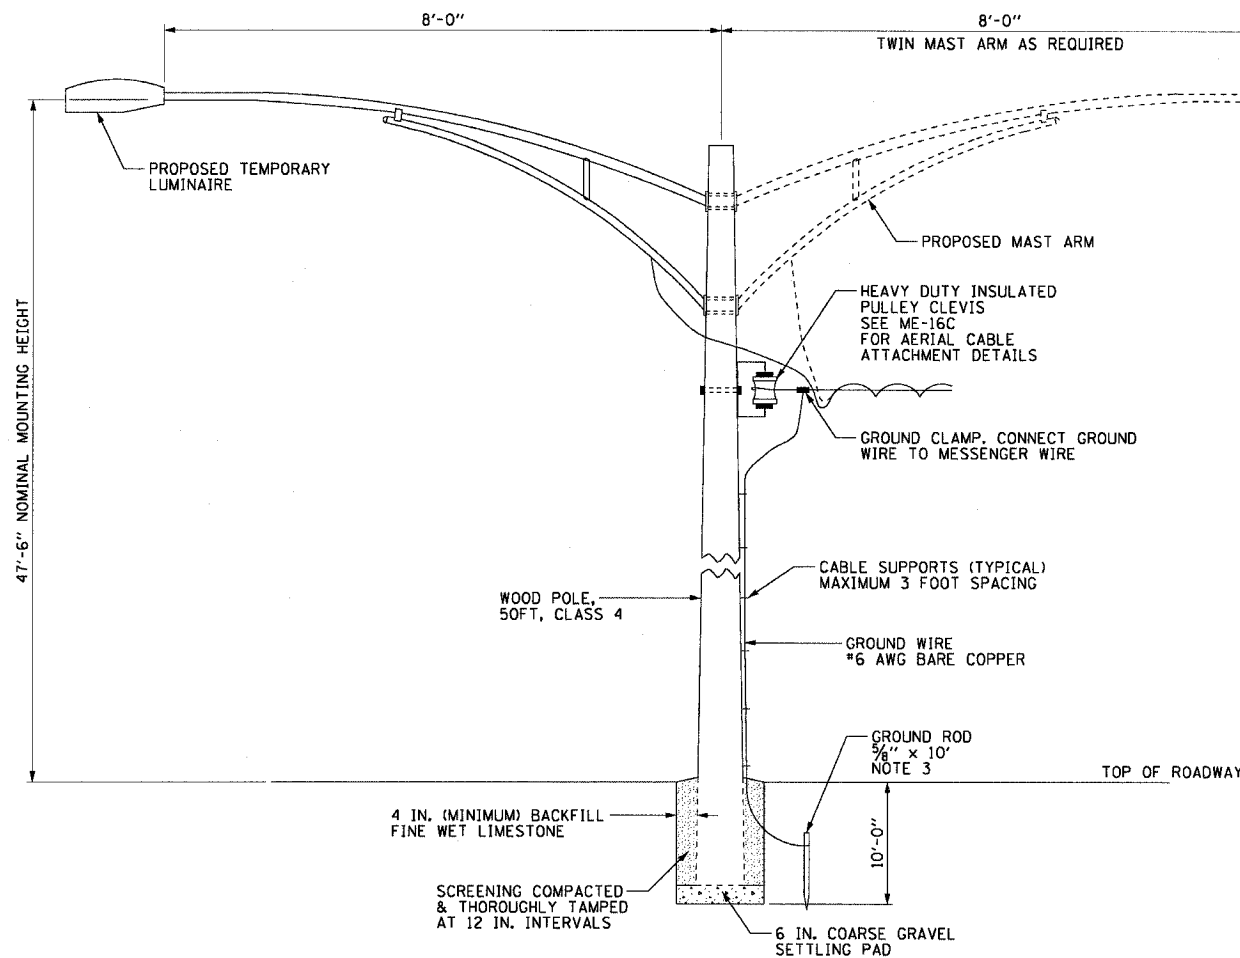


**ME-16A** TEMPORARY LIGHTING UNIT INSTALLATION DETAIL  
WOOD POLE INSTALLATION IS SIMILAR  
NOT TO SCALE

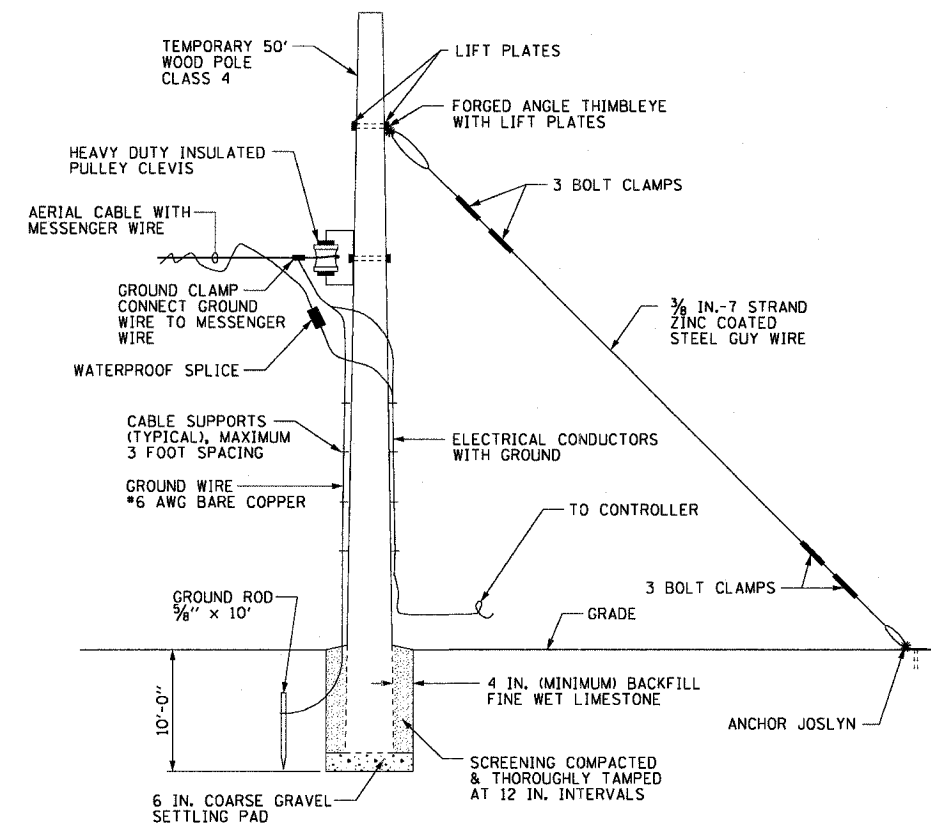

**ME-16B** TEMPORARY WOOD END POLE INSTALLATION DETAILS  
NOT TO SCALE

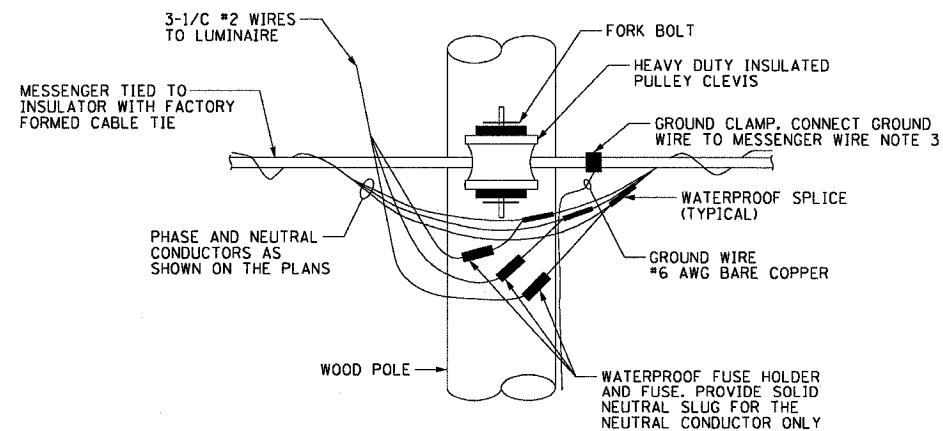

**ME-16C** TEMPORARY WOOD POLE  
AERIAL CABLE ATTACHMENT DETAIL  
NOT TO SCALE

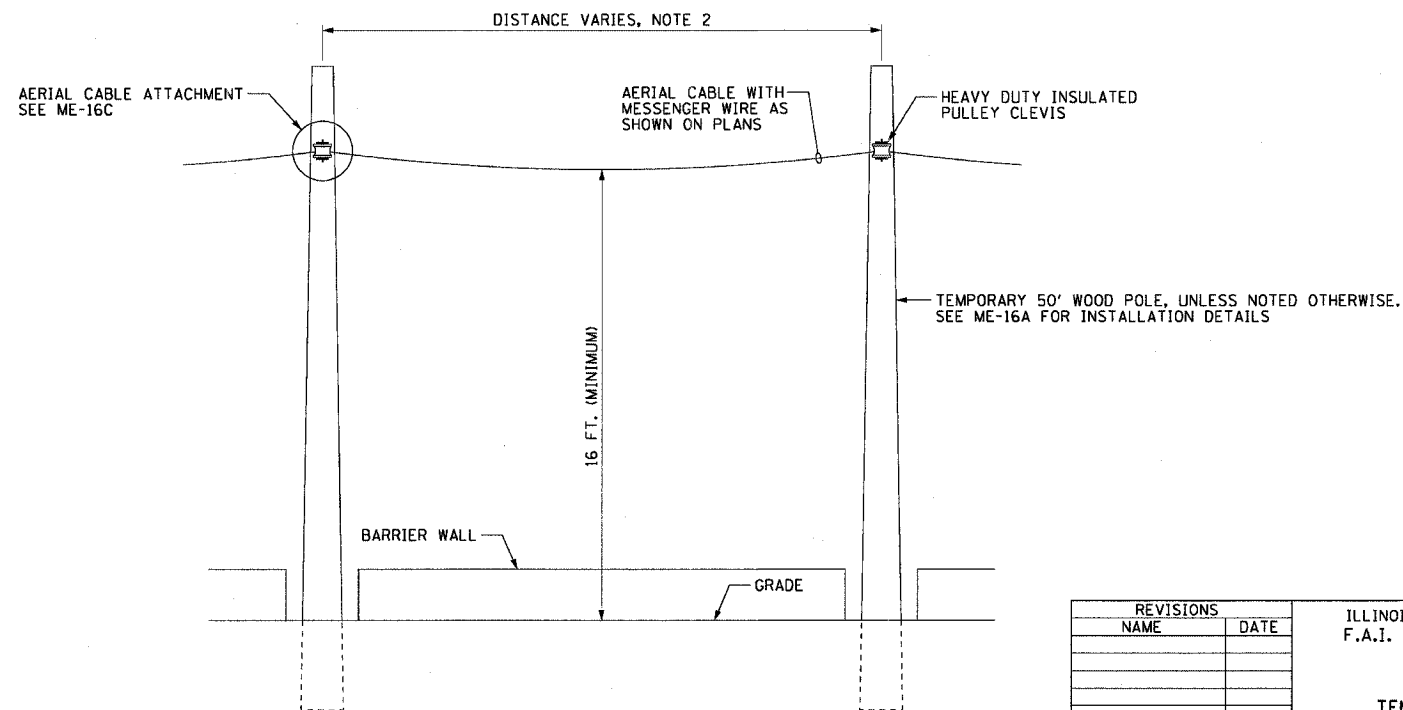

**ME-16D** AERIAL CABLE INSTALLATION DETAIL  
NOT TO SCALE

REVISIONS	
NAME	DATE

ILLINOIS DEPARTMENT OF TRANSPORTATION  
F.A.I. 90/94 (DAN RYAN EXPRESSWAY)  
31st STREET TO I-57  
**TEMPORARY ROADWAY LIGHTING  
WOOD POLE DETAILS**

SCALE: NOT TO SCALE DRAWN BY: CJM  
DATE: October 29, 2004 CHECKED BY: WDS

REVISED 11/23/2004 11:42:36 AM