
 


F.A.I. SECTION	COUNTY	TOTAL SHEETS	SHEET NO.
90/94 2003-0311	COOK	976	79
STA. 2024+00 TO STA. 2011+00			
FED. ROAD DIST. NO.	ILLINOIS	FED. AID PROJECT	

62583

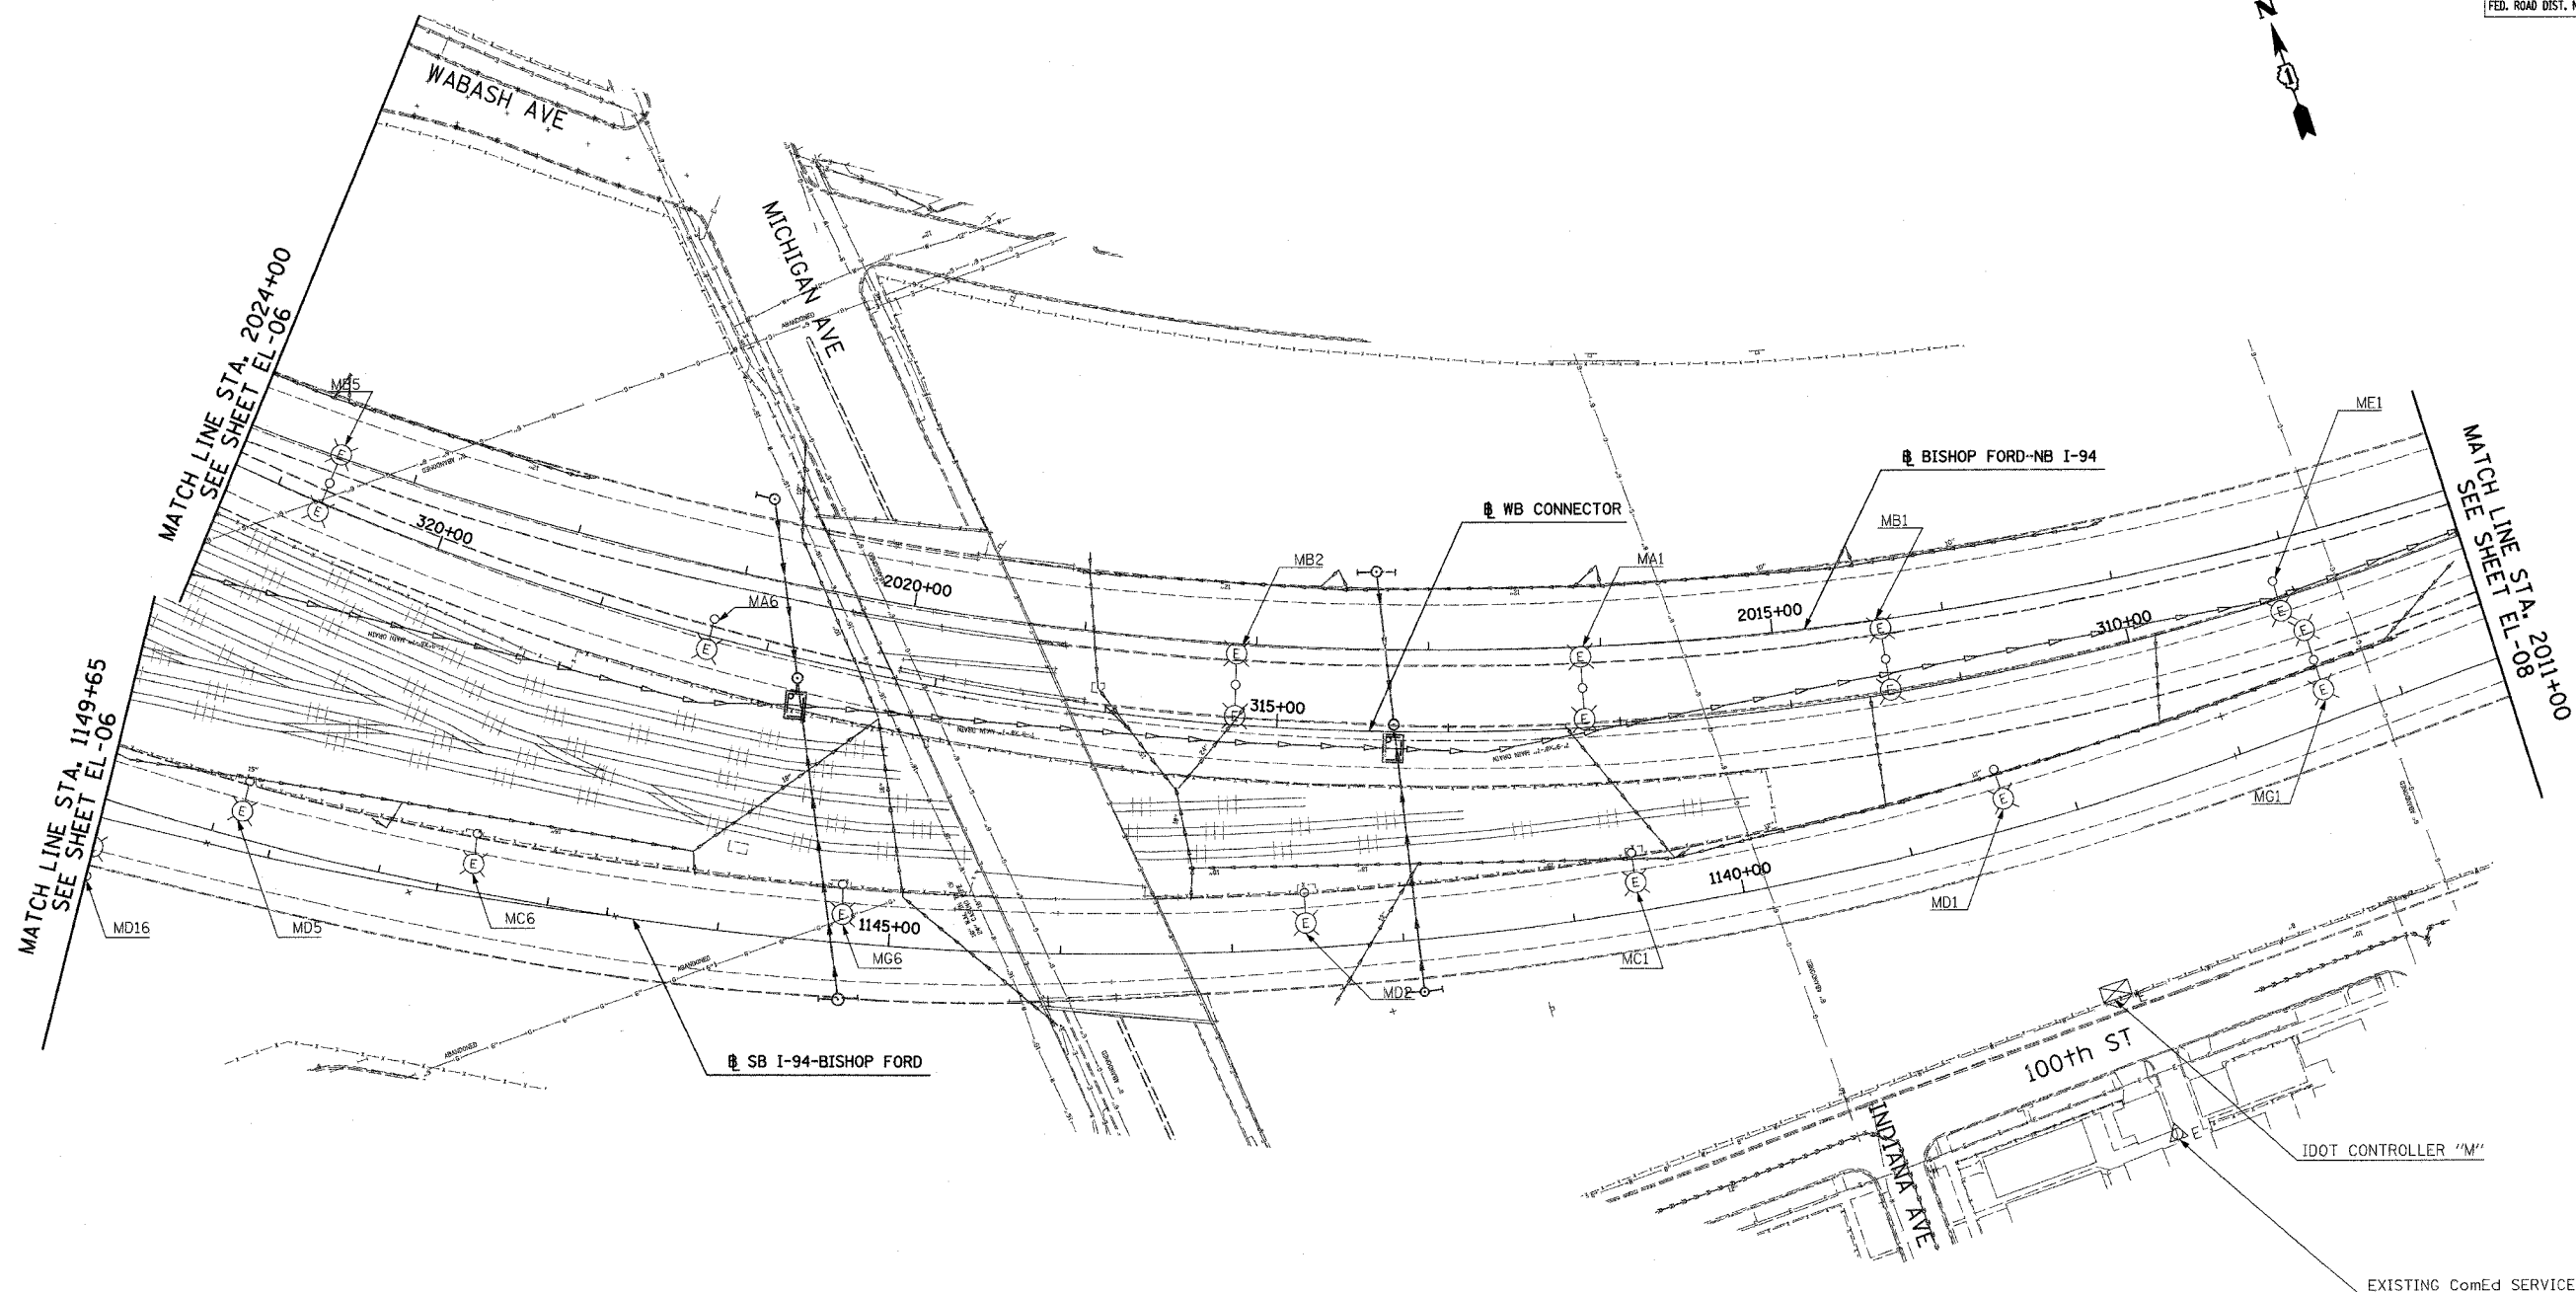

NO ELECTRICAL WORK THIS SHEET  
FOR REFERENCE ONLY



EL-07

REVISIONS	
NAME	DATE

ILLINOIS DEPARTMENT OF TRANSPORTATION  
F.A.I. 90/94 (DAN RYAN EXPRESSWAY)  
31st STREET TO I-57  
ROADWAY LIGHTING PLANS EXISTING  
CONDITIONS, TEMPORARY AND REMOVAL  
SCALE: 1"=50'  
DATE: OCTOBER 29, 2004  
DRAWN BY: SP  
CHECKED BY: TM

**SINGH**  
SINGH & ASSOCIATES, INC.  
CONSULTING ENGINEERS  
300 W. ADAMS ST.  
CHICAGO, IL 60608  
TEL: (312) 628-0240  
FAX: (312) 628-8448

10/20/2004 6:03:28 PM