
 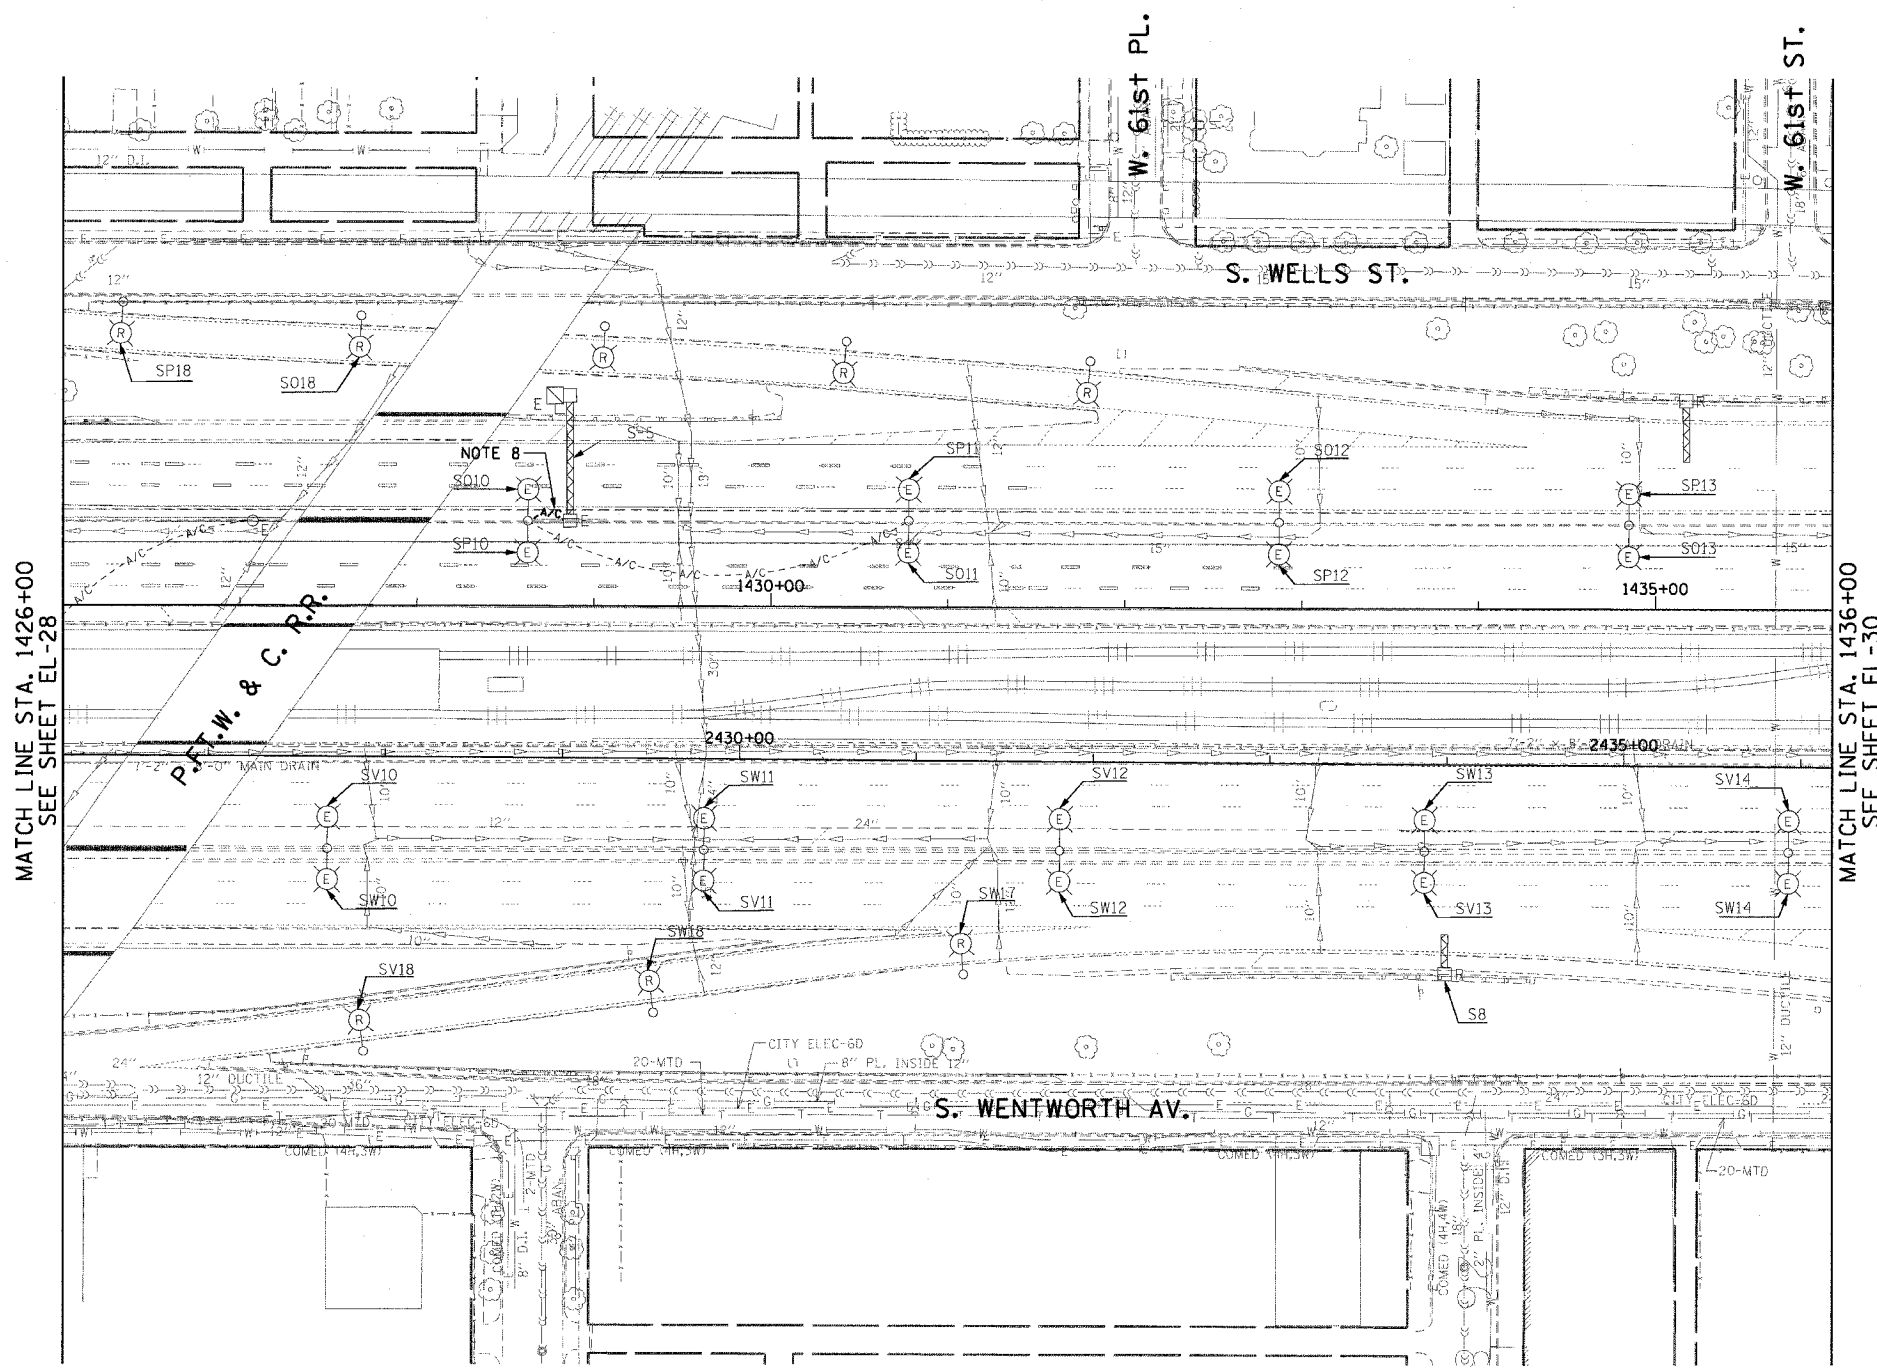


F.A.I. RTE.	SECTION	COUNTY	TOTAL SHEETS	SHEET NO.
90/94	2003-0311	COOK	976	101
STA. 1426+00.00		TO STA. 1436+00.00		
FED. ROAD DIST. NO. 1		ILLINOIS FED. AID PROJECT		

 
62583

NOTES:

- SEE DRAWINGS ME-01 AND ME-02 FOR ELECTRICAL SYMBOLS AND ABBREVIATIONS.
- NOT USED.
- UNLESS NOTED OTHERWISE, ALL ITEMS AND WORK SHOWN IN HEAVY LINE WEIGHT ON THIS DRAWING ARE PROPOSED ITEMS AND WORK.
- NOT USED.
- NOT USED.
- NOT USED.
- THE EXISTING ROADWAY LIGHTING MOUNTED ON THE MEDIAN BARRIER WALL NORTH OF 63rd ST. TO 59th ST. MUST REMAIN IN OPERATION UNTIL THE PROPOSED ROADWAY LIGHTING SYSTEM HAS BEEN INSTALLED, ENERGIZED, TESTED, AND ACCEPTED BY THE ENGINEER, UNLESS OTHERWISE DIRECTED.
- DISCONNECT THE EXISTING TEMPORARY AERIAL CABLE FROM SIGN STRUCTURE "S-5" AND COIL AT THE NEAREST LIGHTING UNIT TO REMAIN. THE TEMPORARY AERIAL CABLE SHALL NOT BE DISCONNECTED UNTIL THE PERMANENT FEED TO THE SIGN STRUCTURE HAS BEEN INSTALLED, TESTED, AND ACCEPTED BY THE ENGINEER.



EXISTING RAMP LIGHTING AND LIGHTED SIGN LIGHTING ARE REMOVED IN IDOT CONTRACT NO. 62733.



EL-29

REVISIONS		ILLINOIS DEPARTMENT OF TRANSPORTATION F.A.I. 90/94 (DAN RYAN EXPRESSWAY) 31st STREET TO I-57
NAME	DATE	
REVISED		ROADWAY LIGHTING PLANS EXISTING CONDITIONS AND DEMOLITION
	1/21/05	
SCALE: 1"=50'		DRAWN BY: CJM
DATE: October 29, 2004		CHECKED BY: WDS

CTE ENGINEERS
 CONSOER TOWNSEND ENVIRONMENTAL ENGINEERS, INC.
 303 EAST WACKER DRIVE, SUITE 600
 CHICAGO, ILLINOIS 60601-5202, PHONE: 1312 938-0300

01/24/2005 11:59:34 AM