


F.A.I. RTE.	SECTION	COUNTY	TOTAL SHEETS	SHEET NO.
94/90	2003-03II	COOK	976	209
STA. 1572+00		TO STA. 1584+00		
FED. ROAD DIST. NO.	ILLINOIS	FED. AID PROJECT		
62583				

 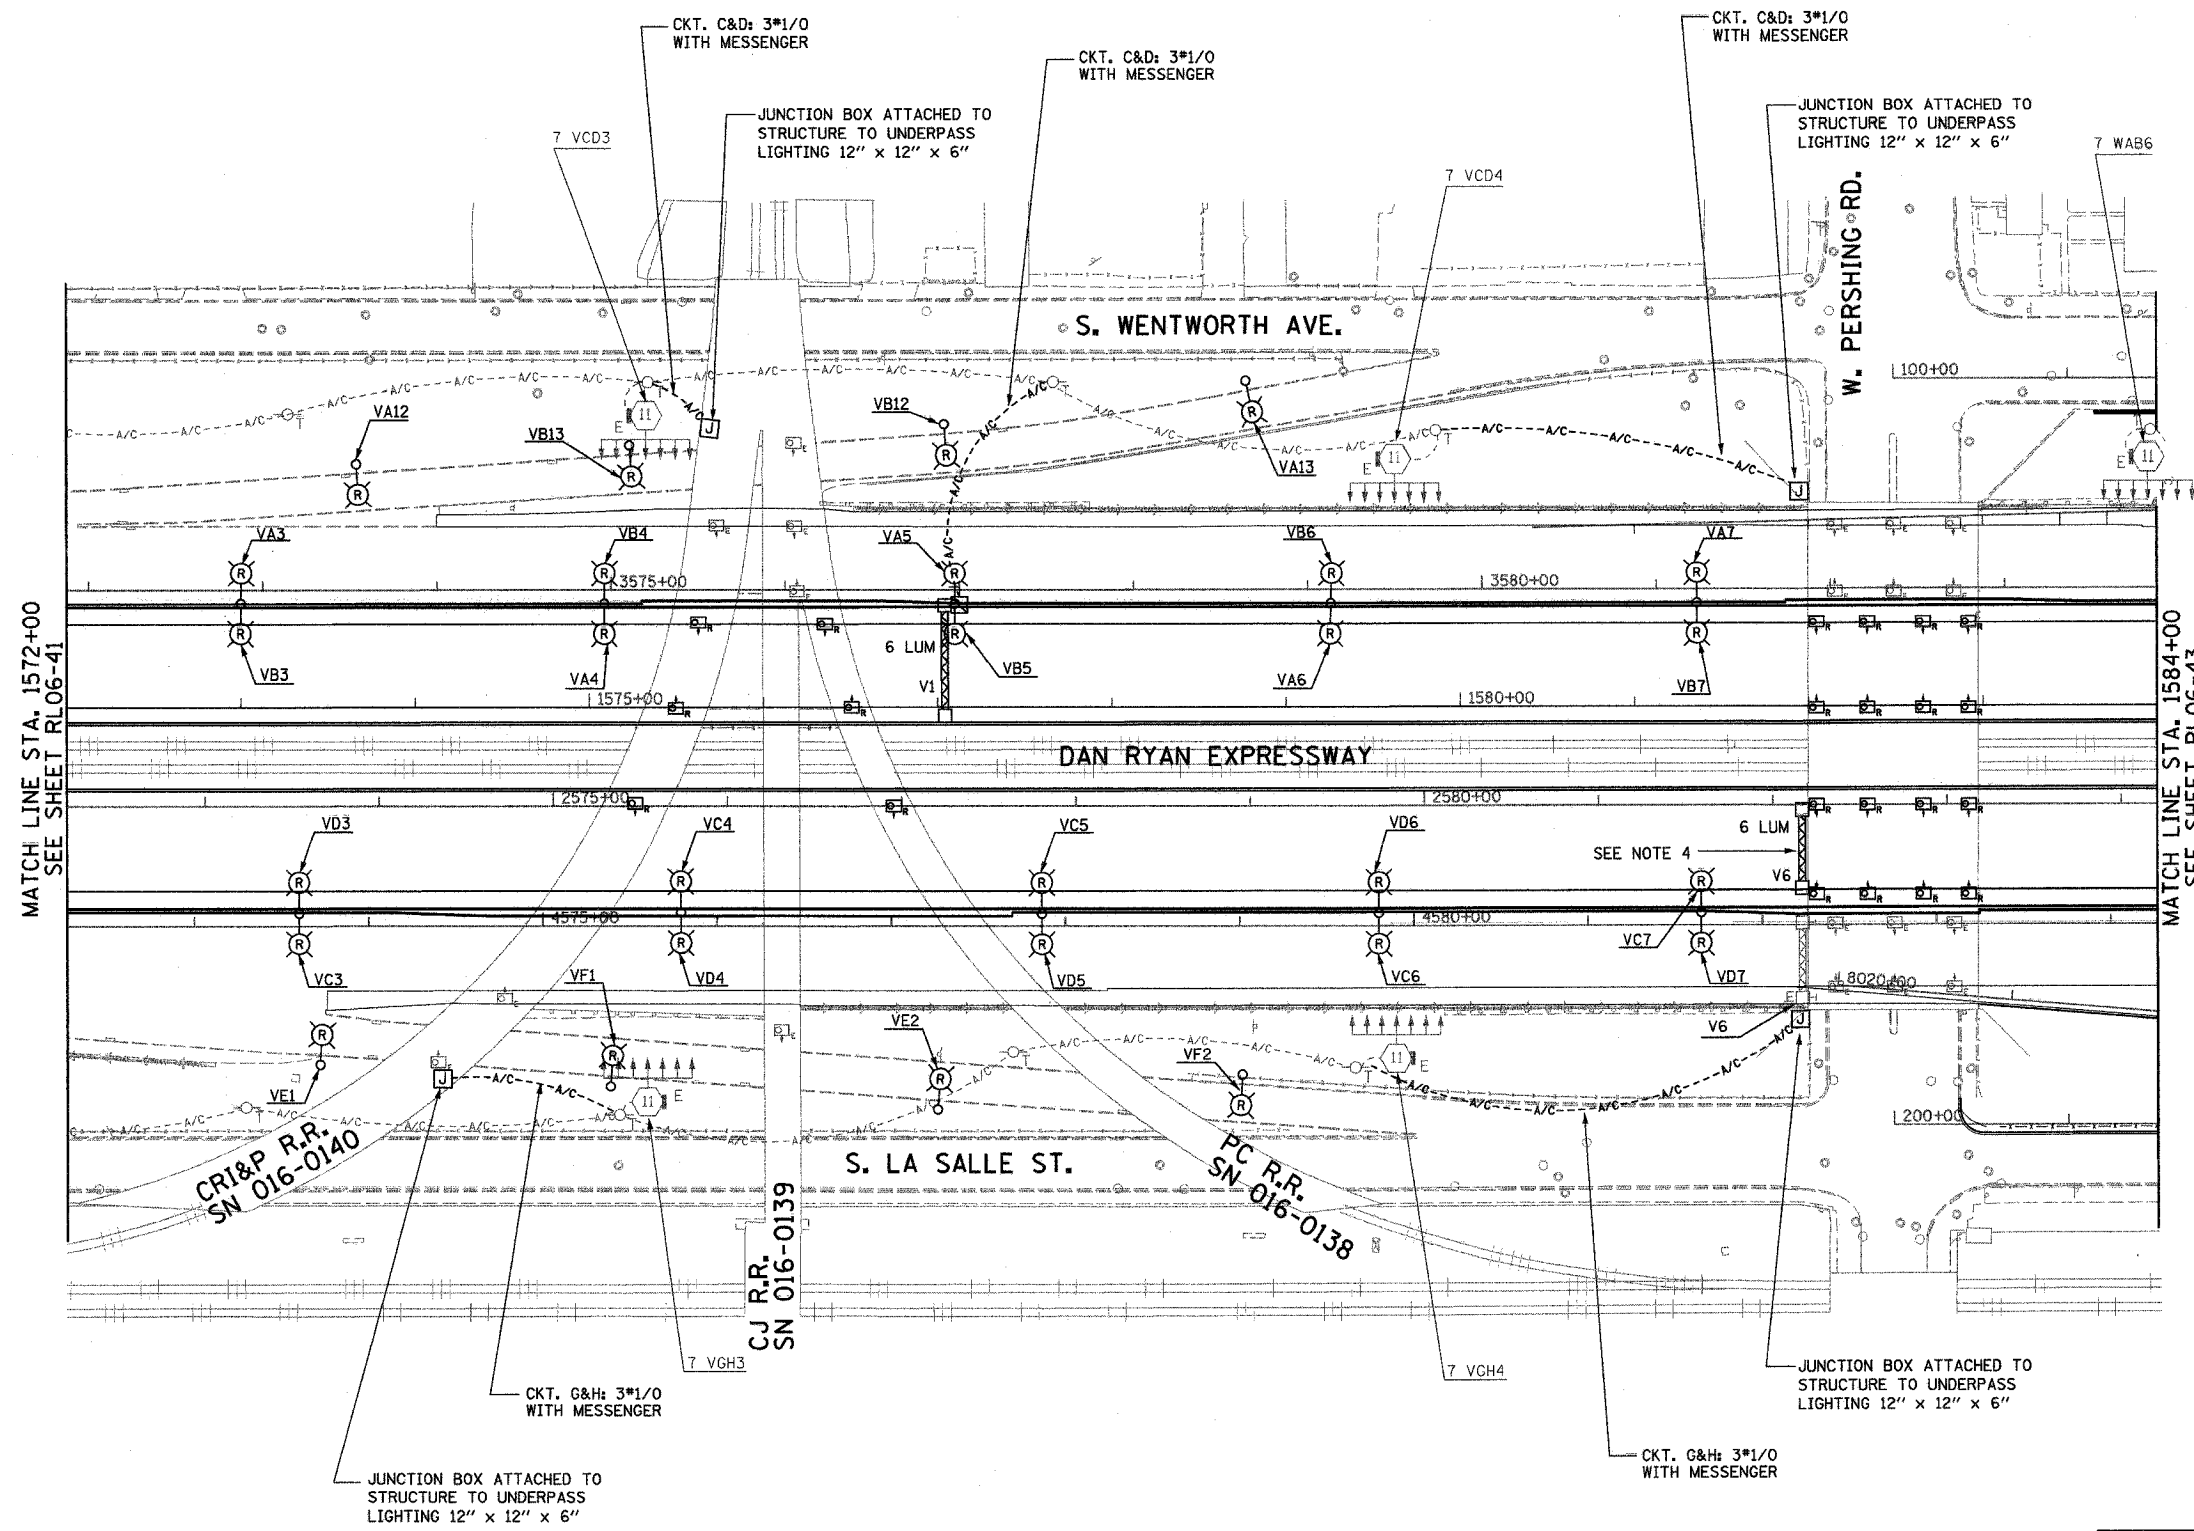


- NOTES:**
- SEE DRAWINGS ME-01 AND ME-02 FOR ELECTRICAL SYMBOLS AND ABBREVIATIONS.
  - UNLESS NOTED OTHERWISE, ALL ITEMS AND WORK SHOWN IN HEAVY LINE WEIGHT ON THIS DRAWING ARE PROPOSED NEW ITEMS AND WORK.
  - ALL JUNCTION BOXES MOUNTED ON AN OVERPASS STRUCTURE SHALL BE INSTALLED AS SHOWN ON DRAWING ME-06 FOR PERSHING RD. AND ME-07 FOR THE RAILROAD STRUCTURE.
  - EXISTING SIGN SHALL BE REMOVED PRIOR TO INSTALLATION OF PROPOSED SIGN.

MATCH LINE STA. 1572+00  
SEE SHEET RL06-41

MATCH LINE STA. 1584+00  
SEE SHEET RL06-43

**K&E** KAM ENGINEERING, INC.  
CONSULTING ENGINEERS  
707A Davis Road, Suite 205  
Egin, Illinois 60123-1369



REVISIONS	
NAME	DATE

ILLINOIS DEPARTMENT OF TRANSPORTATION  
F.A.I. 94/90 (DAN RYAN EXPRESSWAY)  
31st STREET TO I-57

**ROADWAY LIGHTING PLANS  
PROPOSED IMPROVEMENTS 2006**

SCALE: 1"=50'      DRAWN BY: BL  
DATE: OCTOBER 29, 2004      CHECKED BY: SM

RL06-42

06/15/2004 10:21:01 PM C:\p0\text\94-329\shft\lighting\RL06-42.dwg