
 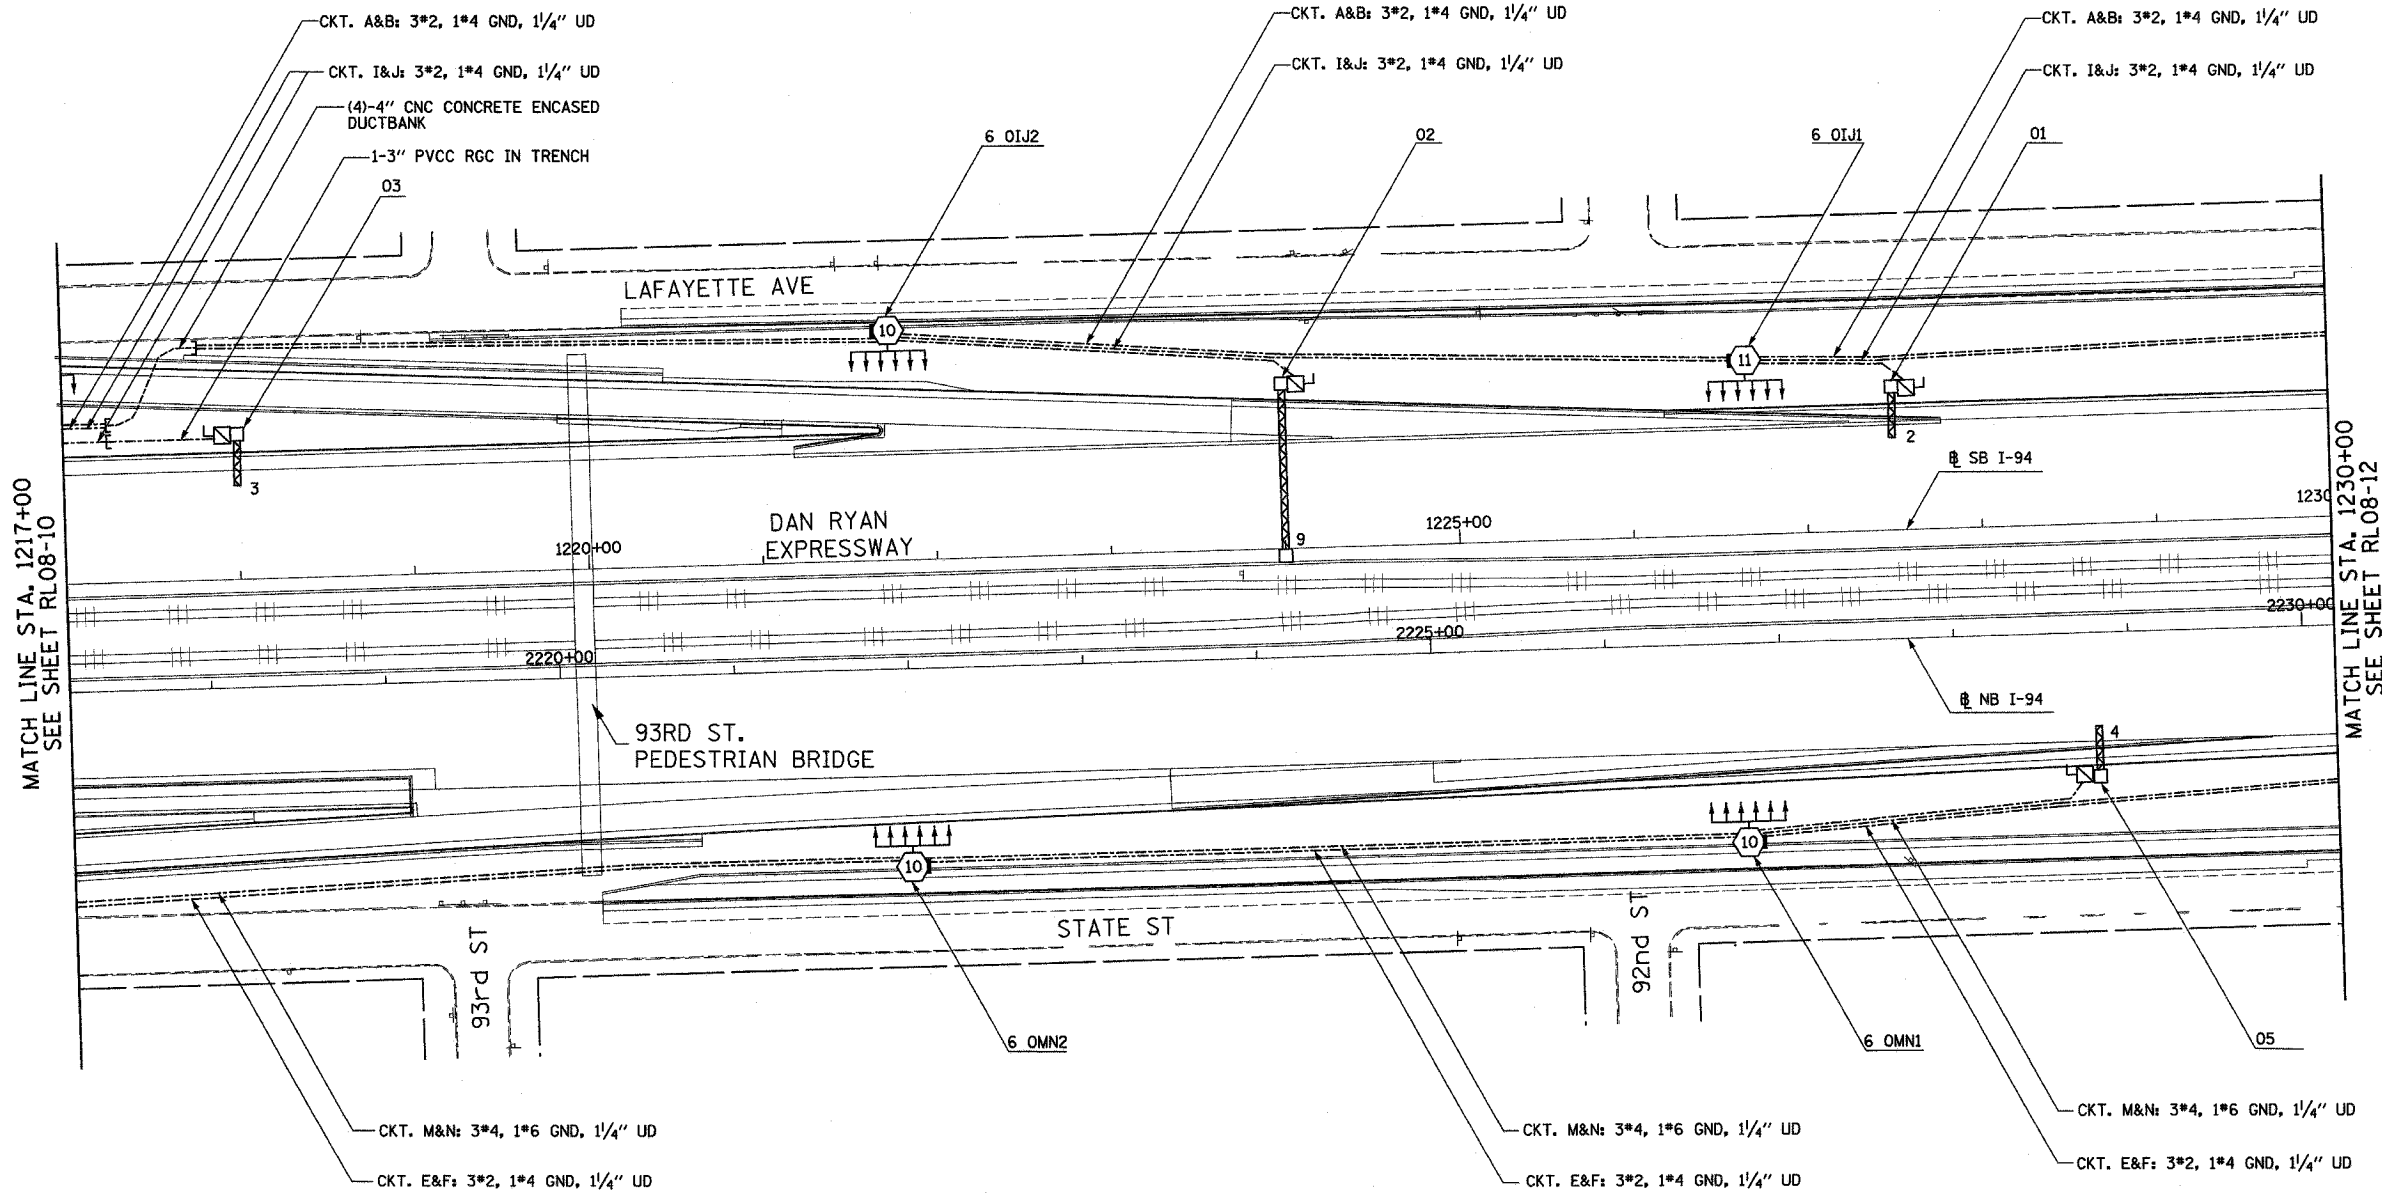


F.A.I. RTE.	SECTION	COUNTY	TOTAL SHEETS	SHEET NO.
90/94	2003-0311	COOK	976	247
STA. 1217+00	TO STA. 1230+00			
FED. ROAD DIST. NO.	ILLINOIS	FED. AID PROJECT		

 
62583

NOTES:  
 1. SEE DRAWINGS ME-01 AND ME-02 FOR ELECTRICAL SYMBOLS AND ABBREVIATIONS.



MATCH LINE STA. 1217+00  
SEE SHEET RL08-10

MATCH LINE STA. 1230+00  
SEE SHEET RL08-12



RL08-11

**SINGH**  
 SINGH & ASSOCIATES, INC.  
 CONSULTING ENGINEERS

300 W. ADAMS ST.  
 CHICAGO, IL 60606  
 TEL: (312) 629-0240  
 FAX: (312) 629-8449

REVISIONS	
NAME	DATE

ILLINOIS DEPARTMENT OF TRANSPORTATION  
 F.A.I. 90/94 (DAN RYAN EXPRESSWAY)  
 31st STREET TO I-57

ROADWAY LIGHTING PLANS  
 PROPOSED IMPROVEMENTS 2008

SCALE: 1"=50'  
 DATE: OCTOBER 29, 2004

DRAWN BY: VG  
 CHECKED BY: TM

D:\15\2004 8:35:10 AM