
 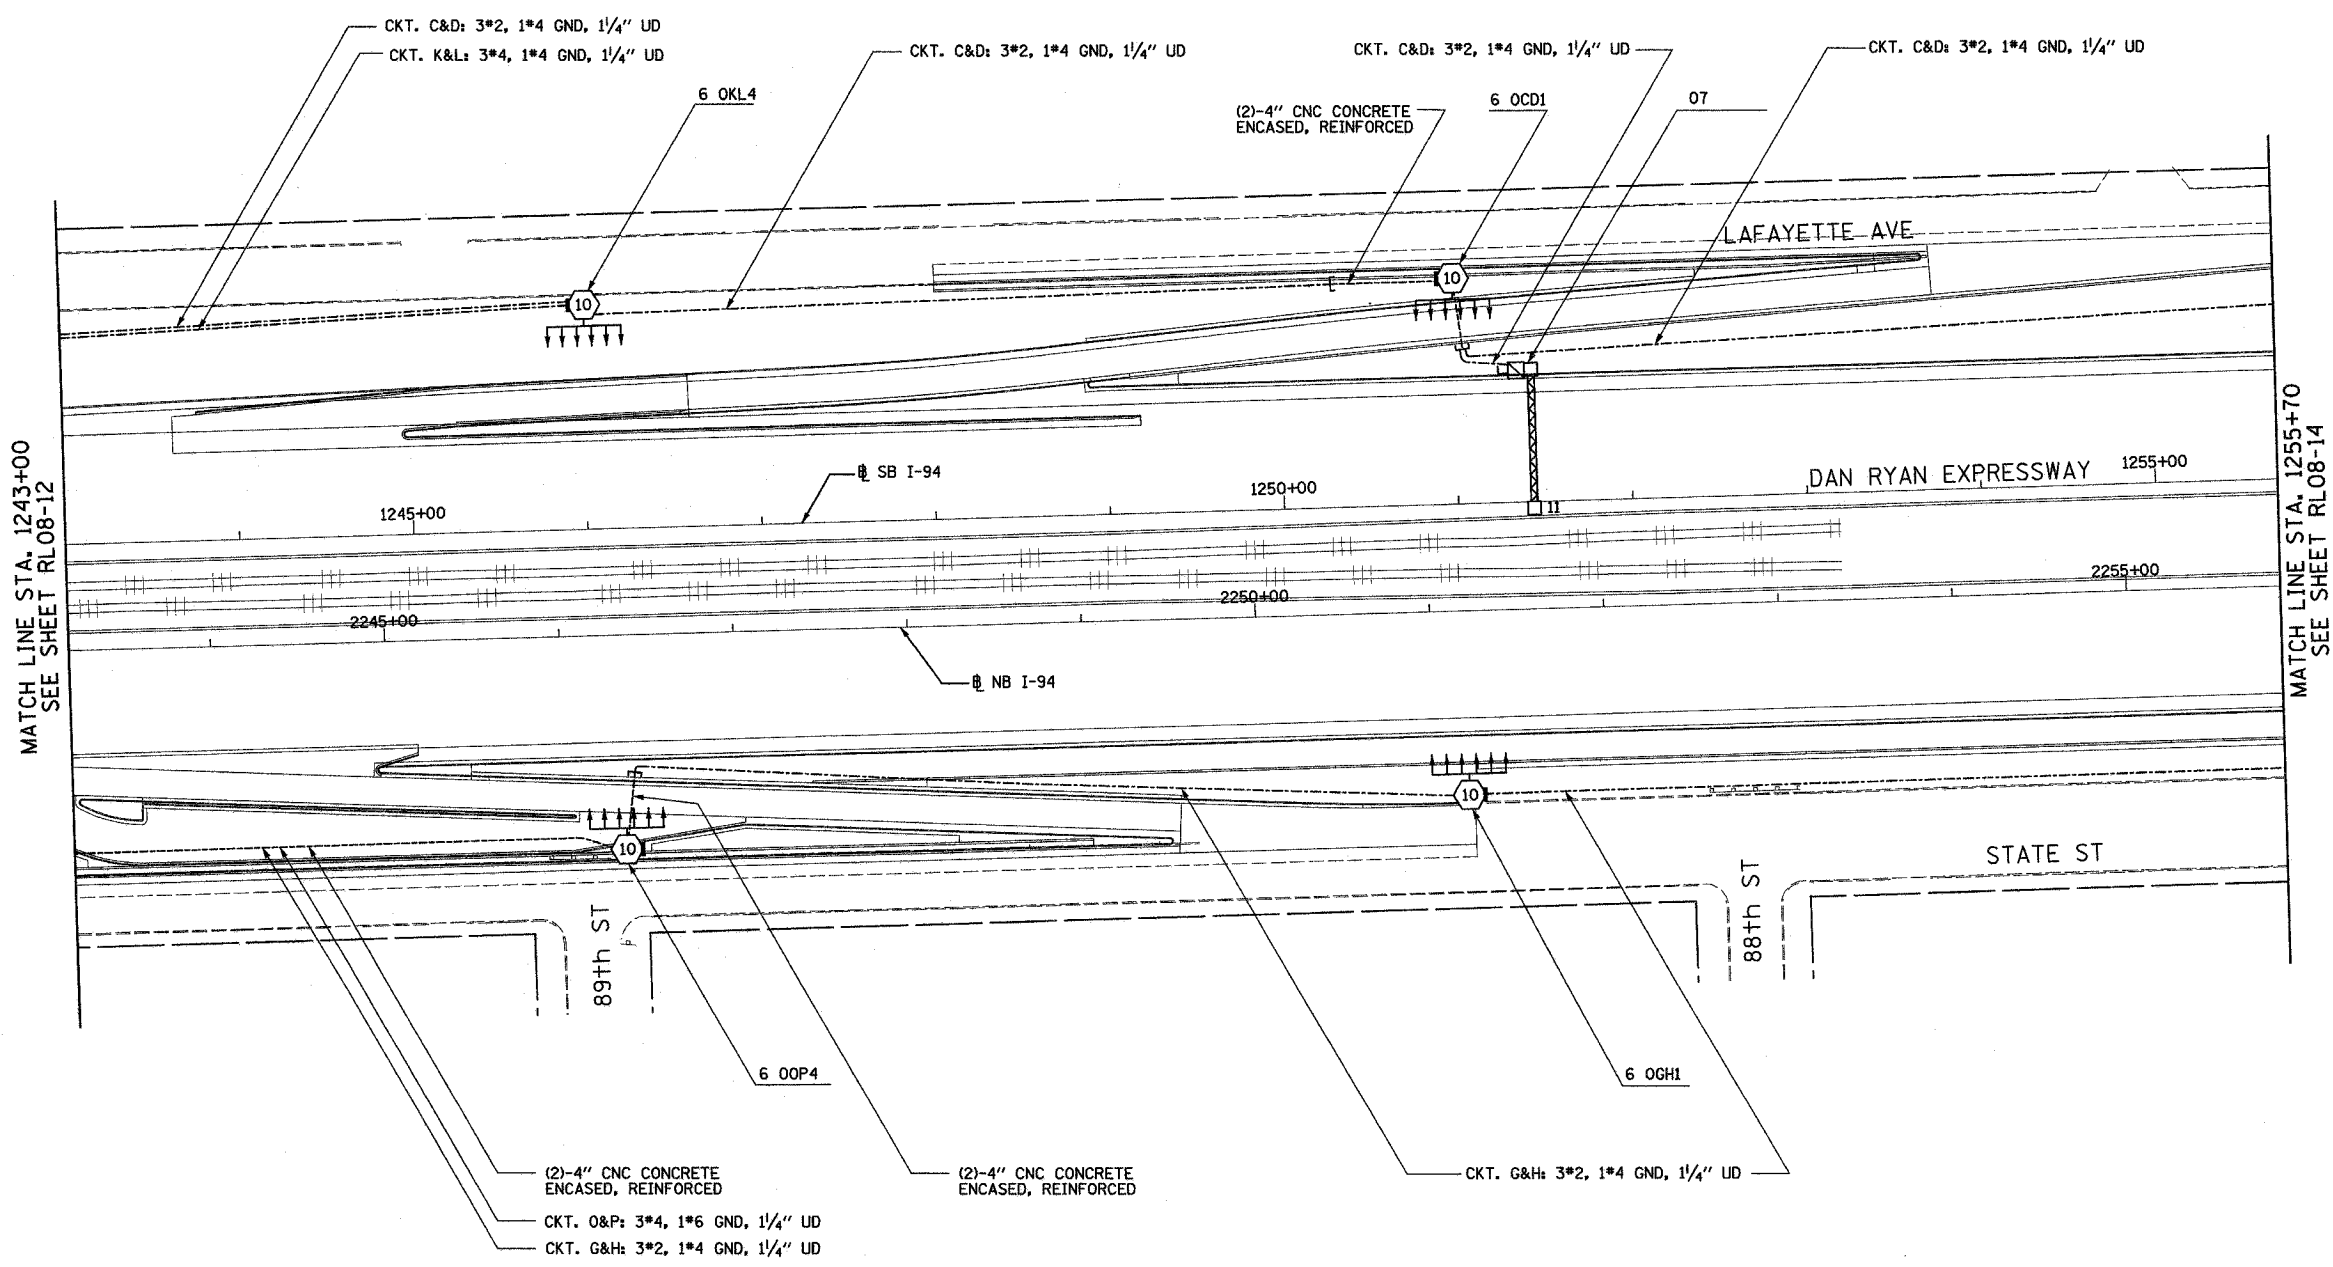


F.A.I. RTE:	SECTION	COUNTY	TOTAL SHEETS	SHEET NO.
90/94	2003-03II	COOK	976	269
STA. 1243+00		TO STA. 1255+70		
FED. ROAD DIST. NO.	ILLINOIS FED. AID PROJECT		62583	

NOTES:  
 1. SEE DRAWINGS ME-01 AND ME-02 FOR ELECTRICAL SYMBOLS AND ABBREVIATIONS.



MATCH LINE STA. 1243+00  
SEE SHEET RL08-12

MATCH LINE STA. 1255+70  
SEE SHEET RL08-14



RL08-13

REVISIONS	
NAME	DATE

ILLINOIS DEPARTMENT OF TRANSPORTATION  
 F.A.I. 90/94 (DAN RYAN EXPRESSWAY)  
 31st STREET TO I-57  
 ROADWAY LIGHTING PLANS  
 PROPOSED IMPROVEMENTS 2008  
 SCALE: 1"=50'  
 DATE: OCTOBER 29, 2004  
 DRAWN BY: VG  
 CHECKED BY: TM

**SINGH**  
 300 W. ADAMS ST.  
 CHICAGO, IL 60606  
 SINGH & ASSOCIATES, INC.  
 CONSULTING ENGINEERS  
 TEL: (312) 629-0240  
 FAX: (312) 629-8449

10/14/2004 2:55:14 PM