 



F.A.I. RTE.	SECTION	COUNTY	TOTAL SHEETS	SHEET NO.
90/94	2003-0311	COOK	976	248
STA. 1458+50.00		TO STA. 1471+00.00		
FED. ROAD DIST. NO. 1 ILLINOIS FED. AID PROJECT				

62583

**NOTES:**

1. SEE DRAWINGS ME-01 AND ME-02 FOR ELECTRICAL SYMBOLS AND ABBREVIATIONS.
2. SEE DRAWING ES-05 FOR HIGH MAST LIGHT TOWER SCHEDULE.
3. SEE DRAWING UL-28 FOR 57th STREET UNDERPASS LIGHTING PLANS.

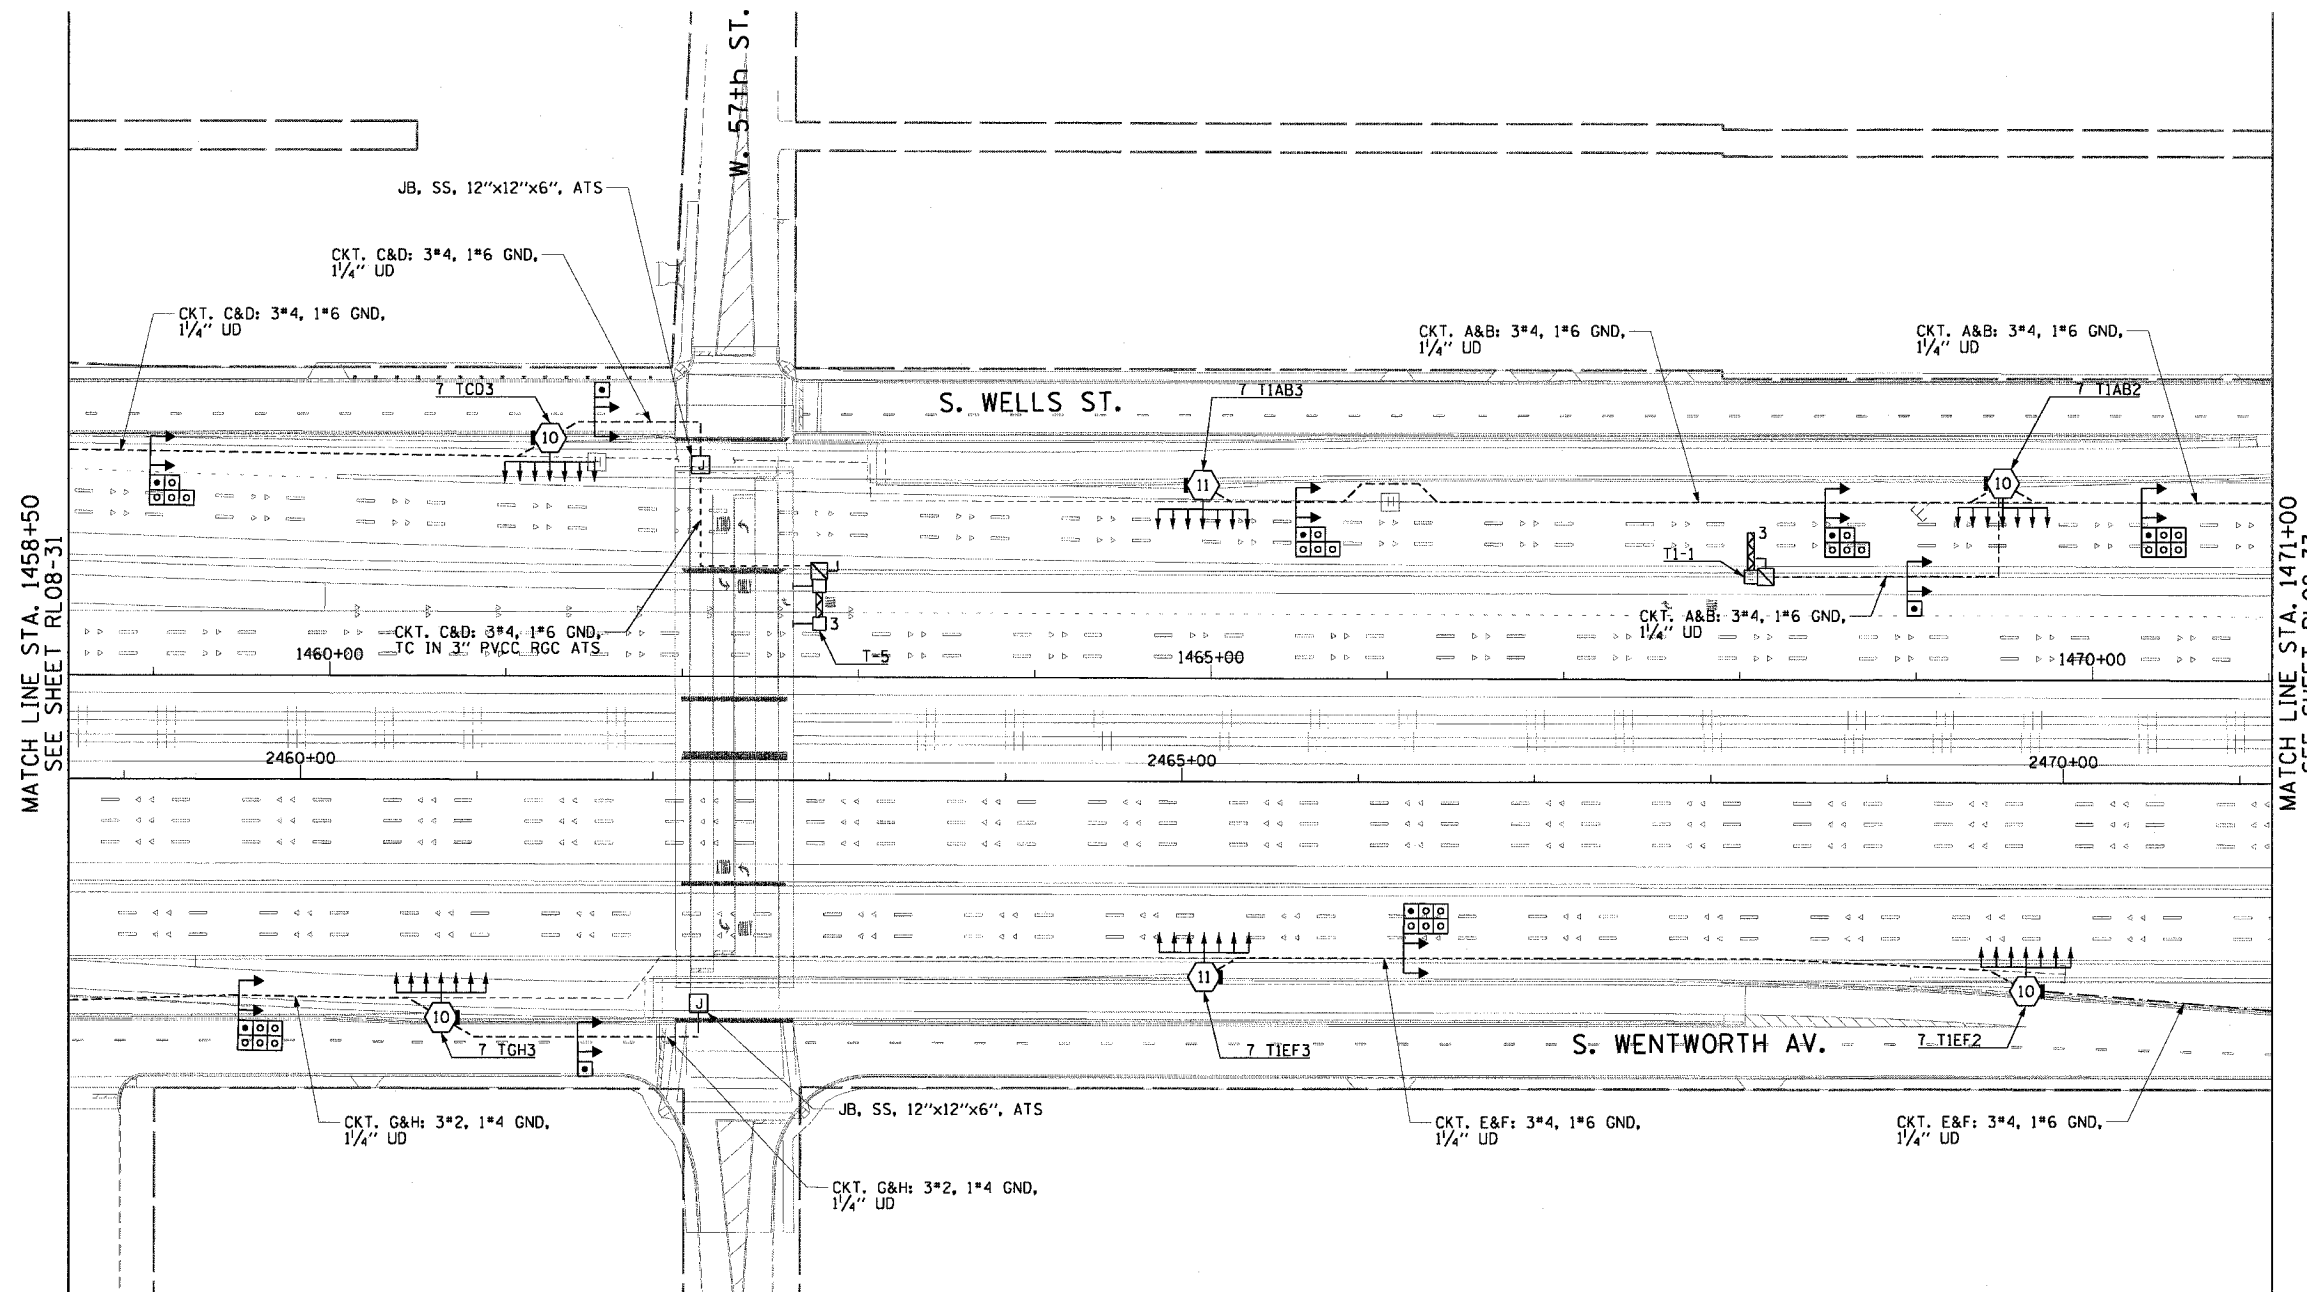

RL08-32

REVISIONS	
NAME	DATE

ILLINOIS DEPARTMENT OF TRANSPORTATION  
 F.A.I. 90/94 (DAN RYAN EXPRESSWAY)  
 31st STREET TO I-57  
**ROADWAY LIGHTING PLANS  
 FINAL CONDITIONS**

SCALE: 1"=50'  
 DATE: October 29, 2004

DRAWN BY: CJM  
 CHECKED BY: WDS

m:\p40465\elect\16-entr\2b\slr\contract 2\2008-Final\1020322a\_08.sht  
 11/19/2004 01:05:10 PM