


F.A.I. RTE.	SECTION	COUNTY	TOTAL SHEETS	SHEET NO.
94/90	2003-0311	COOK	976	327
STA.	TO STA.			
FED. ROAD DIST. NO.	ILLINOIS	FED. AID PROJECT		

62583

LEGEND:

- HIGH MAST LIGHT TOWER
- 400W. HPS LUMINAIRE (BLACK PHASE- SOLID SYMBOLS, RED PHASE-OPEN SYMBOL)
- 7VCD1** HIGH MAST TOWER DESIGNATION
- LIGHTING CONTROLLER
- GROUND FIELD
- ELECTRIC UTILITY SERVICE
- TEMPORARY WOOD POLE, 90 FT. WITH 15 FT. MAST ARM AND 400W HPS LUMINAIRE
- AERIAL CABLE, 3*1/0 WITH MESSENGER CABLE UNLESS OTHERWISE NOTED
- LIGHTED SIGN STRUCTURE WITH 170 W. FLUORESCENT LUMINAIRES. QUANTITY OF LUMINAIRES AS REQUIRED. (BLACK PHASE- SOLID SYMBOLS, RED PHASE, OPEN SYMBOL)
- 3 POLE SAFETY SWITCH
- UNDERPASS LIGHTING UNIT, 70W HPS LUMINAIRE. (BLACK PHASE- SOLID SYMBOL, RED PHASE-OPEN SYMBOL)
- UNDERPASS LIGHTING UNIT, 55W HPS LUMINAIRE. (BLACK PHASE- SOLID SYMBOL, RED PHASE-OPEN SYMBOL)

CIRCUIT	RED PHASE		BLACK PHASE		
	AMPS	WATTS	CIRCUIT	AMPS	WATTS
A	44.55	8825	B	43.35	8595
C	34.10	6720	D	35.40	7010
E	42.95	8485	F	40.95	8085
G	35.35	7005	H	35.00	6950
I	SPARE	SPARE	J	SPARE	SPARE
K	SPARE	SPARE	L	SPARE	SPARE
M	SPARE	SPARE	N	SPARE	SPARE
O	SPARE	SPARE	P	SPARE	SPARE
TOTAL	156.95A	31,035	TOTAL	154.70A	30,640

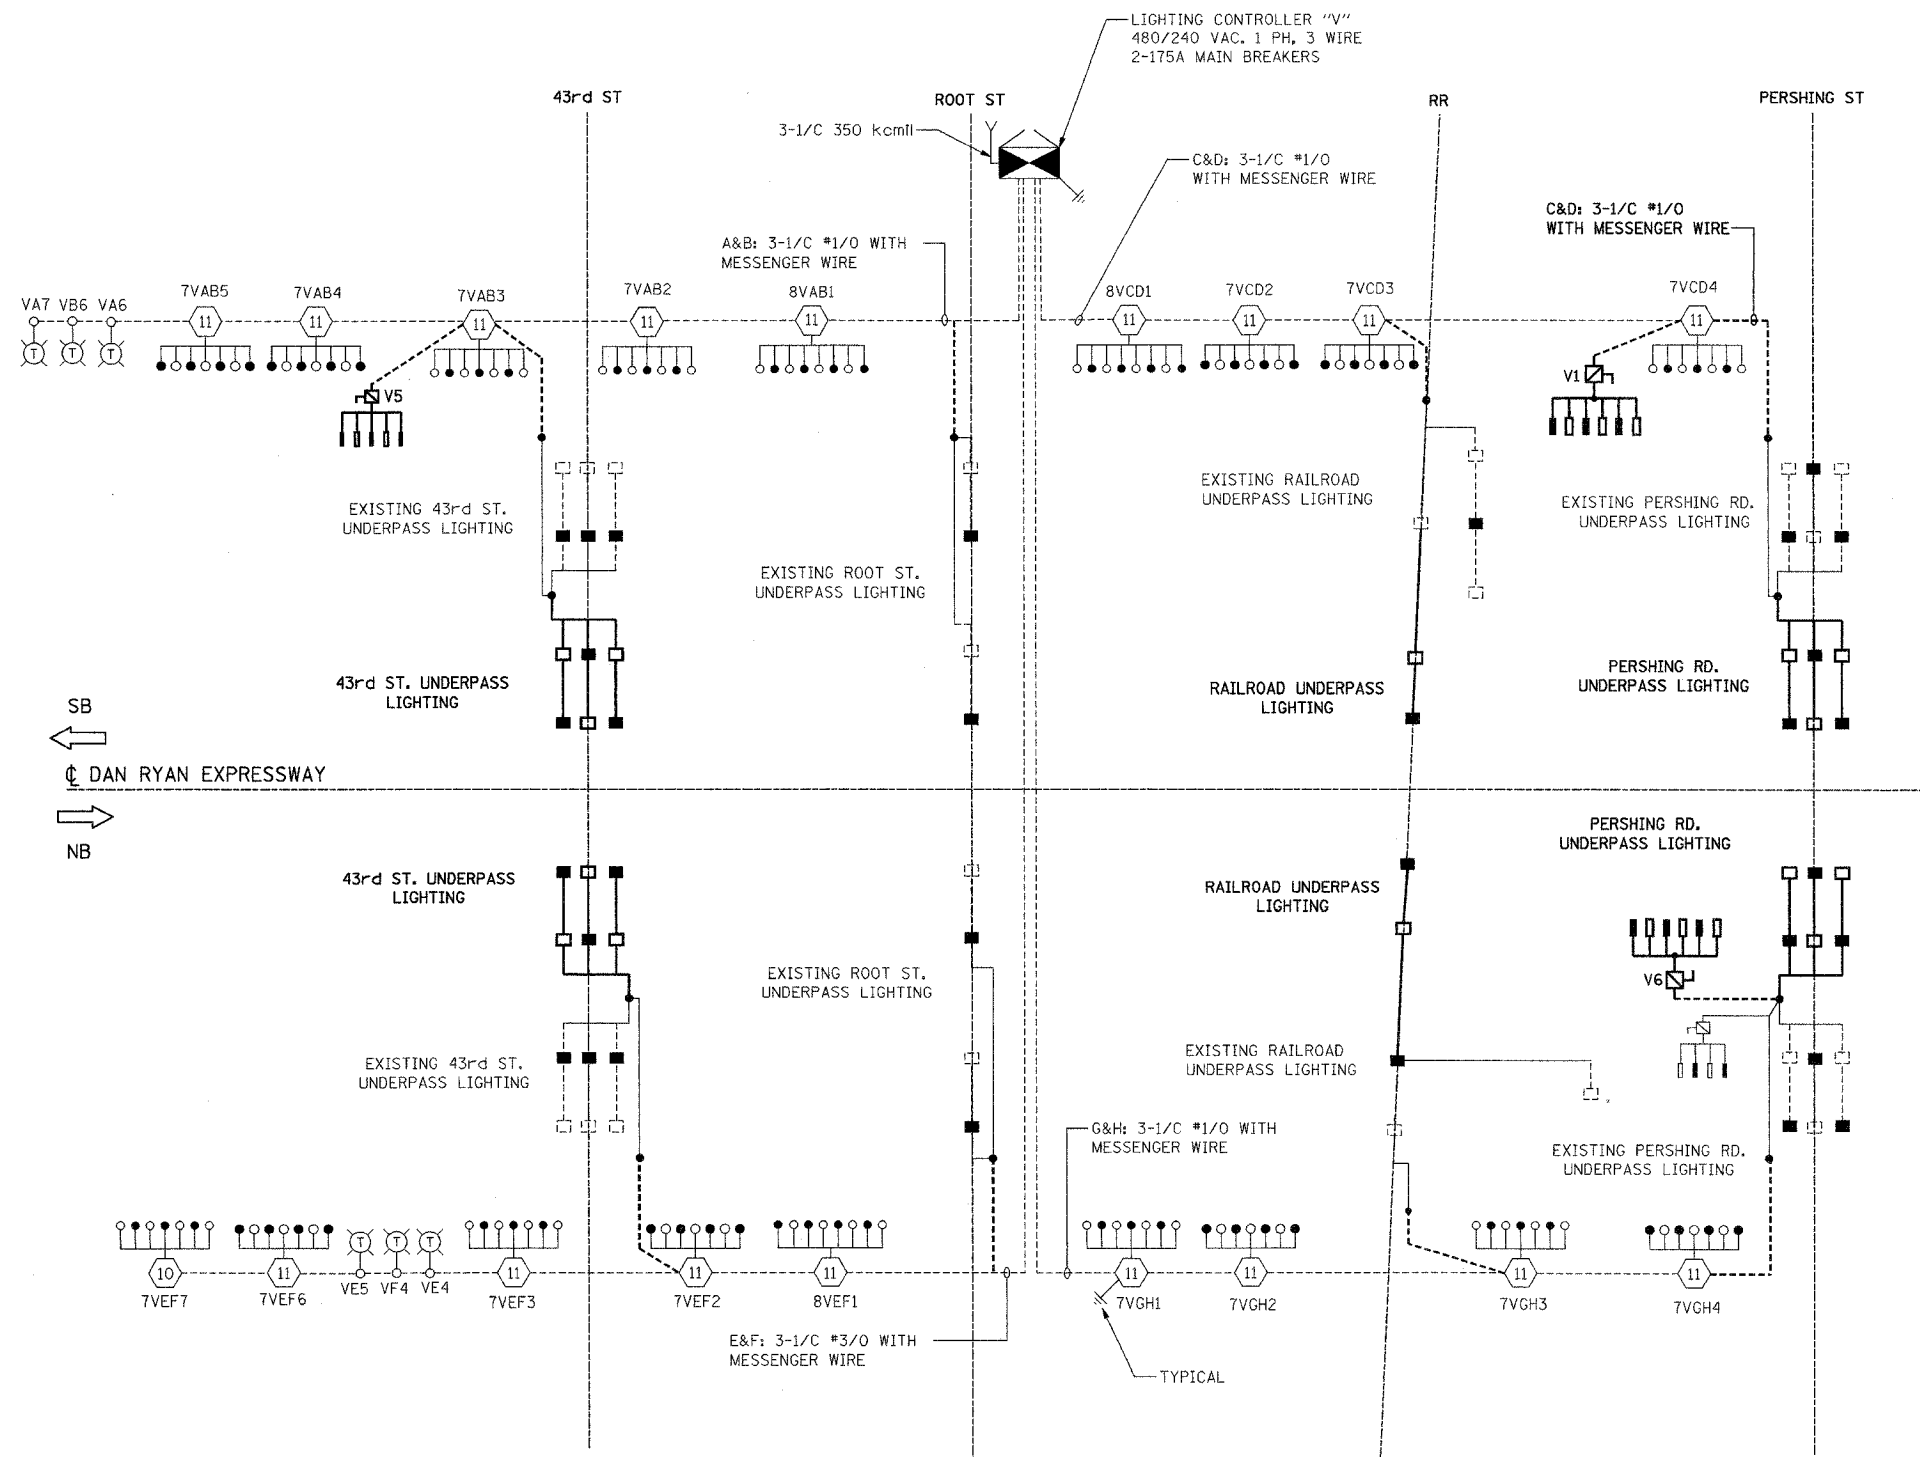

SL06-11

REVISIONS	
NAME	DATE

ILLINOIS DEPARTMENT OF TRANSPORTATION
F.A.I. 94/90 (DAN RYAN EXPRESSWAY)
31st STREET TO I-57

SINGLE LINE DIAGRAM
LIGHTING CONTROLLER "V"
PROPOSED IMPROVEMENTS 2006

SCALE: NONE DRAWN BY: BL
DATE: OCTOBER 29, 2004 CHECKED BY: SM

KAM ENGINEERING, INC.
CONSULTING ENGINEERS
707A Davis Road, Suite 205
Elgin, Illinois 60123-1369

10/16/2004 11:28:48 AM