



SECTION	COUNTY	TOTAL SHEETS	SHEET NO.
2003-0311	COOK	976	679
STA. 1204+00	TO STA. 1217+00		
FED. ROAD DIST. NO.	ILLINOIS	FED. AID PROJECT	
62583			

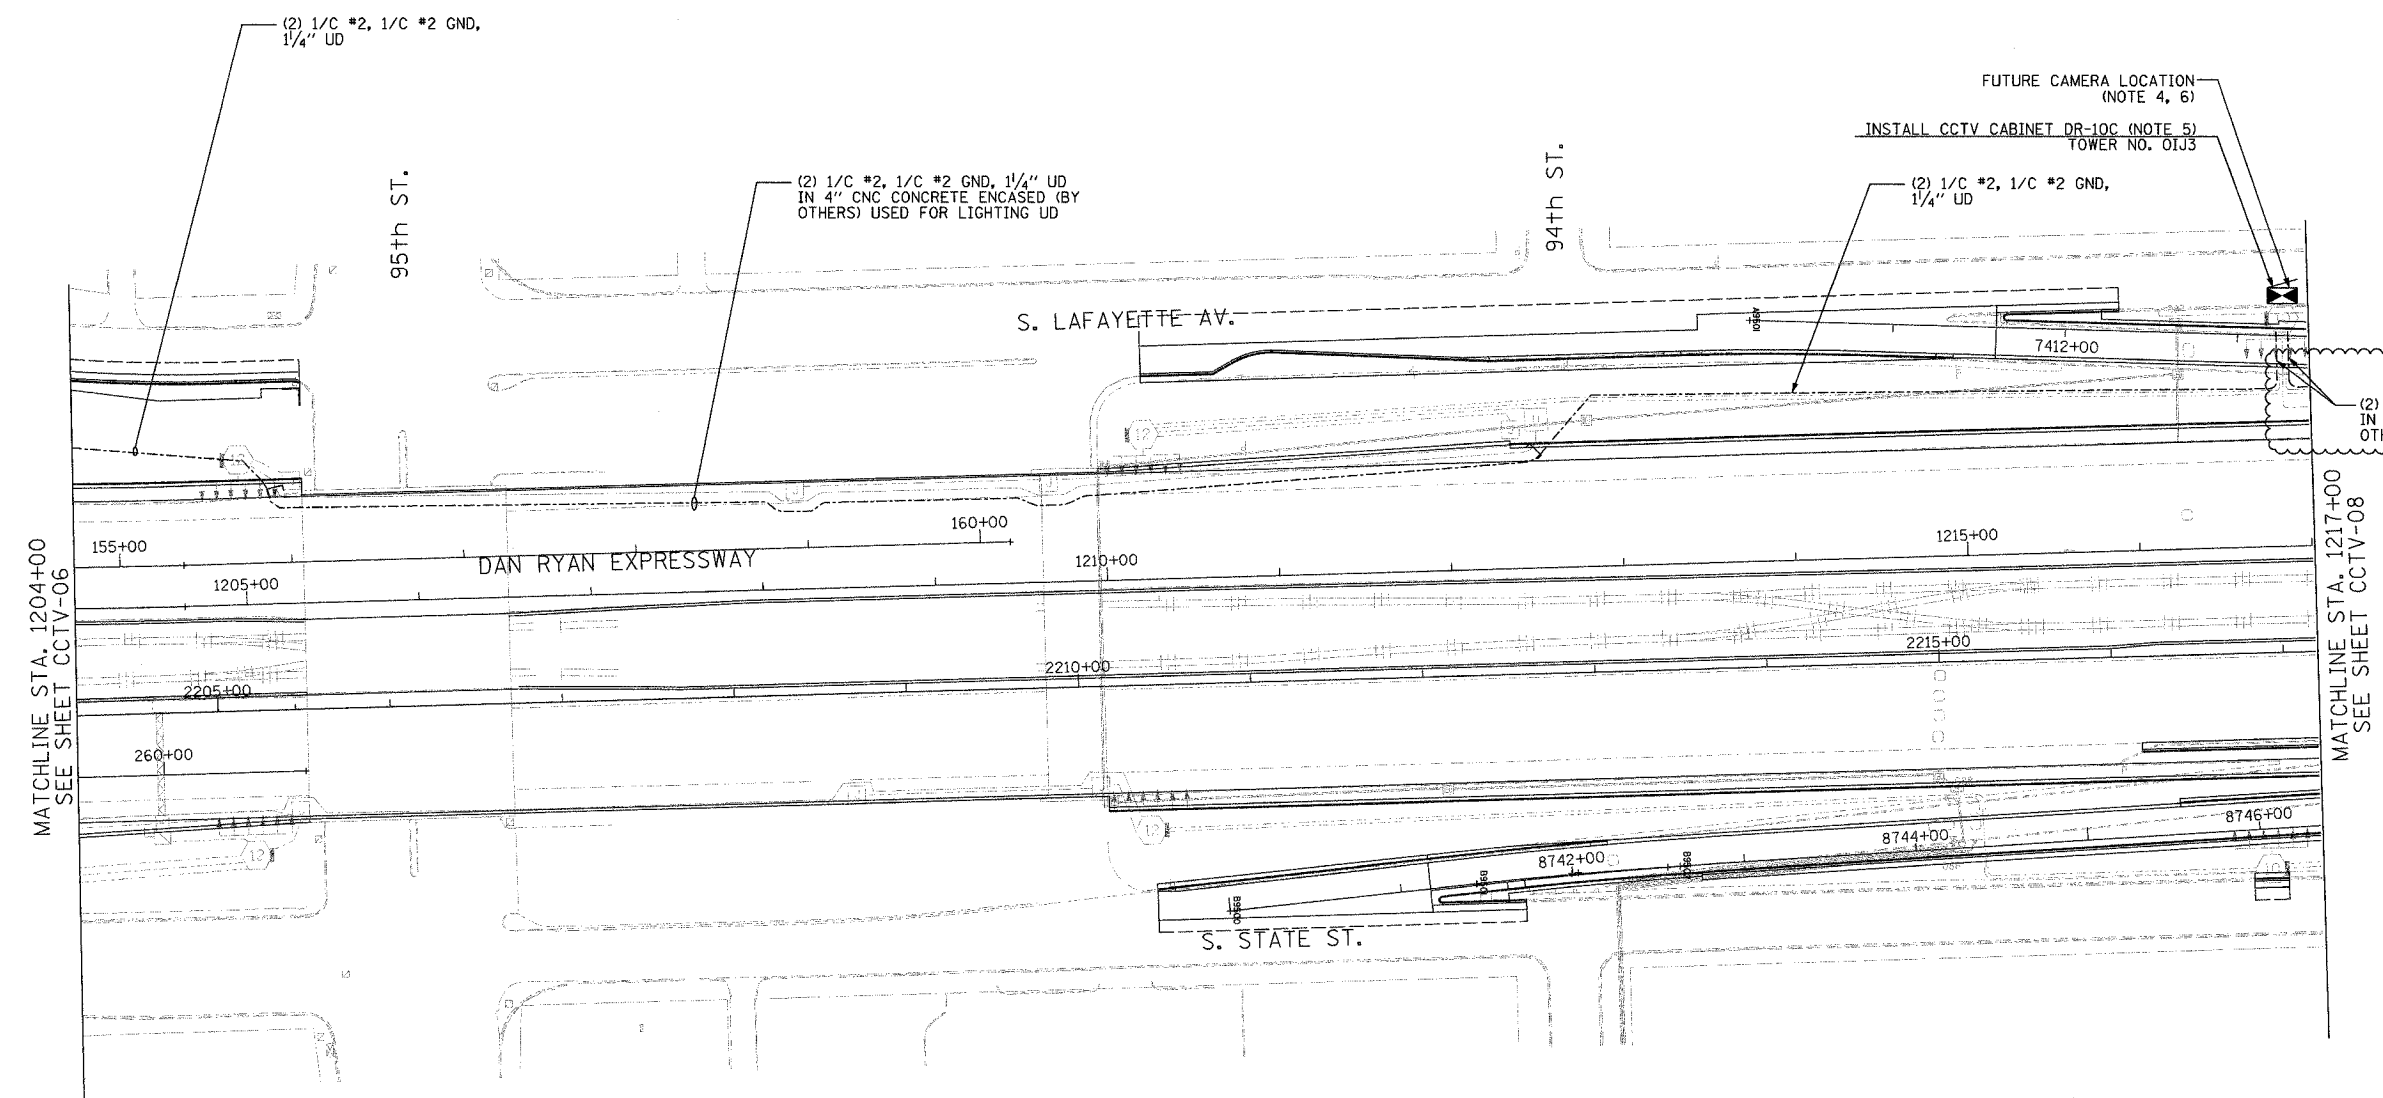

MATCHLINE STA. 1204+00  
SEE SHEET CCTV-06

MATCHLINE STA. 1217+00  
SEE SHEET CCTV-08

 - NOTES:**
1. SEE DRAWINGS ME-01 AND ME-02 FOR ELECTRICAL SYMBOLS AND ABBREVIATIONS.
  2. UNLESS OTHERWISE STATED, ALL NOTED CABLE AND CONDUIT TO BE FURNISHED AND INSTALLED UNDER THIS CONTRACT.
  3. THIS SHEET ONLY DEPICTS INSTALLATION OF CLOSED CIRCUIT TELEVISION ELEMENTS. SEE LIGHTING PLANS FOR LIGHTING ELEMENT INSTALLATION.
  4. SEE DRAWING COMM-10 FOR CCTV COMMUNICATIONS SYSTEM CONDUIT AND CABLE LAYOUT.
  5. SEE DRAWING DT-17 FOR CCTV CABINET MOUNTING DETAILS ON A HIGH-MAST LIGHT TOWER.
  6. CONTRACTOR SHALL SPLICE (2) 1/C #2, 1/C #2 GND IN CCTV CABINET DR-10C FOR CABINET DR-11 POWER FEED. SEE DRAWING CCTV-06 FOR CONTINUATION.



CCTV-07

**Edwards  
AND  
Kelcey**  
ONE NORTH FRANKLIN  
CHICAGO, IL 60606  
PHONE: (312) 251-3000  
FAX: (312) 251-3015  
WEB: WWW.EKCORP.COM

REVISIONS	
NAME	DATE
REVISION 1	12/17/04

ILLINOIS DEPARTMENT OF TRANSPORTATION  
F.A.I. 94/90 (DAN RYAN EXPRESSWAY)  
31st STREET to I-57  
CLOSED CIRCUIT TELEVISION  
SITE LAYOUT  
CAMERA DR-11 (SHEET 2 OF 4)  
CAMERA DR-10C (SHEET 1 OF 3)  
SCALE: 1"=50'  
DATE: October 29, 2004  
DRAWN BY: DHI  
CHECKED BY: MJL

P:\030009\035\75\ADD\CCTV\0207\2E.SHT 12/10/2004 10:11:21 AM