



SECTION	COUNTY	TOTAL SHEETS	SHEET NO.
2003-0311	COOK	976	870
STA.	TO STA.		
FED. ROAD DIST. NO.	ILLINOIS	FED. AID PROJECT	
62583			




NEW CCTV CONTROL WORKSTATION  
(SEE NOTE 3 FOR INSTALLATION DETAILS)

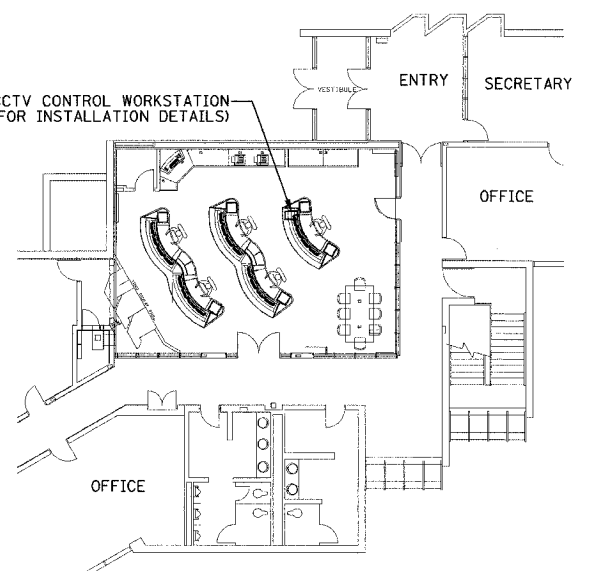

PARTIAL MAIN LEVEL FLOOR PLAN

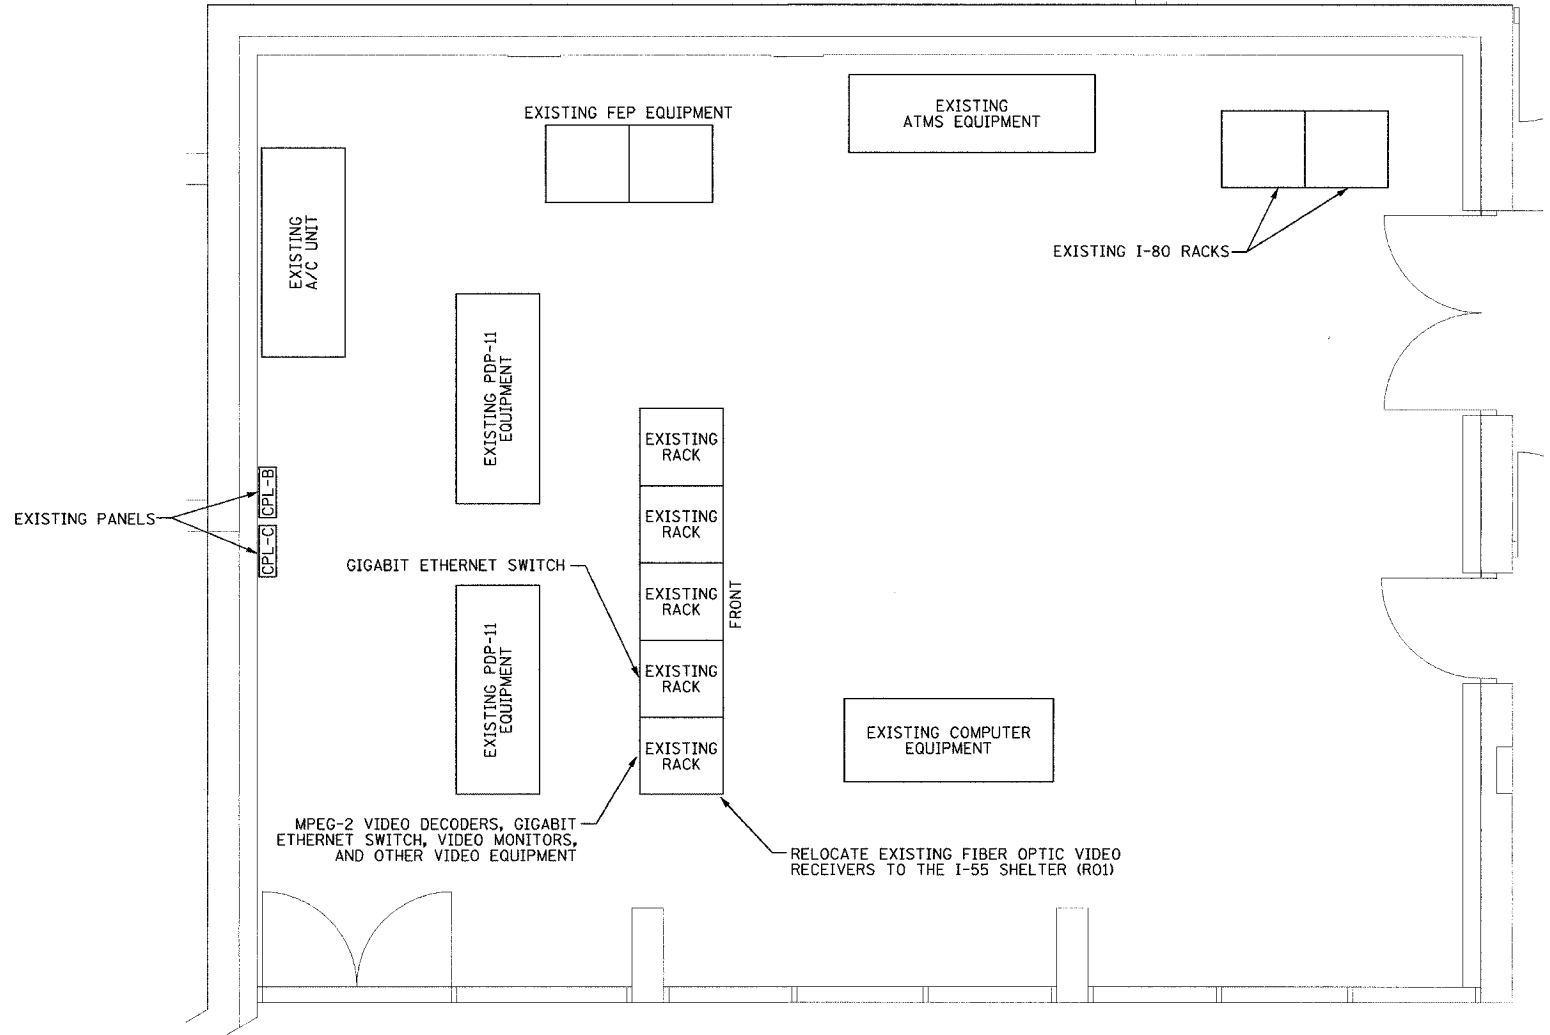

COMPUTER ROOM

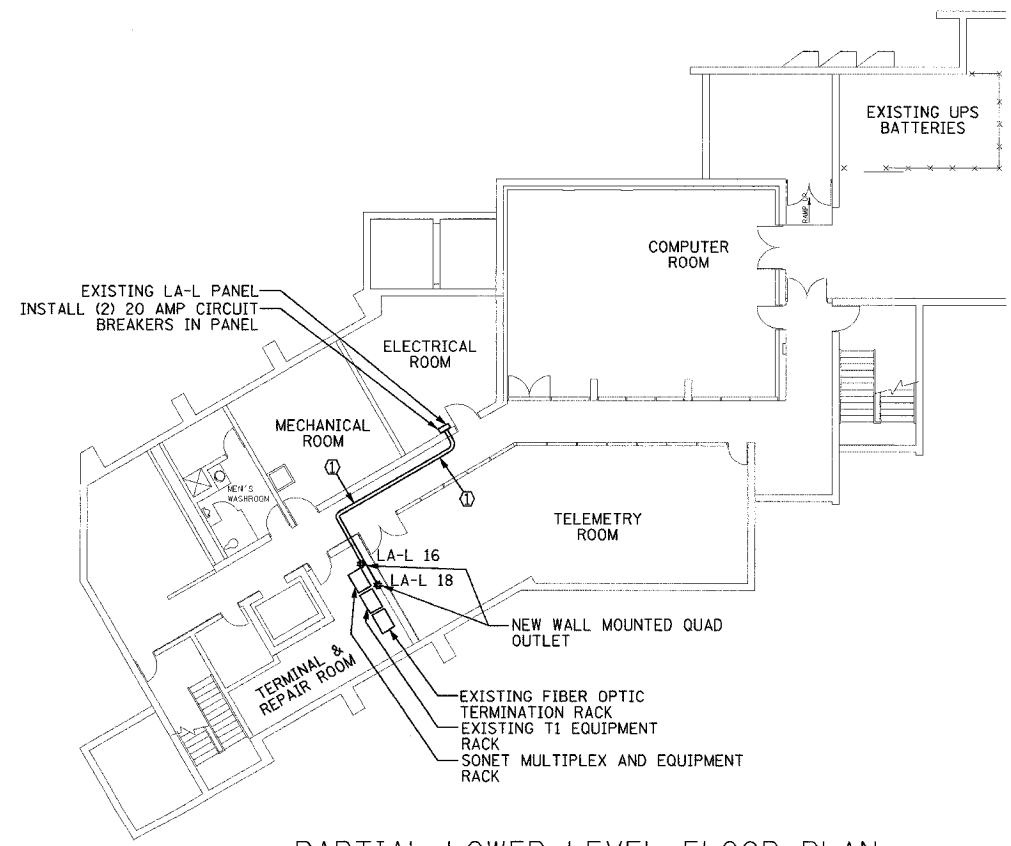

PARTIAL LOWER LEVEL FLOOR PLAN

① (2) #12 & (1) #12 GND, 3/4" C

**Edwards AND Kelcey**  
 ONE NORTH FRANKLIN  
 CHICAGO, IL 60606  
 PHONE: (312) 251-3000  
 FAX: (312) 251-3015  
 WEB: WWW.EKCORP.COM

- NOTES:
- CONTRACTOR SHALL COORDINATE THE FINAL LOCATION OF ALL EQUIPMENT WITH THE ENGINEER.
  - UNLESS OTHERWISE NOTED, ALL EQUIPMENT IS TO BE INSTALLED UNDER THIS CONTRACT.
  - CCTV CONTROL WORKSTATION SHALL USE EXISTING POWER AND DATA PORTS LOCATED IN CONSOLE.

REVISIONS	
NAME	DATE

ILLINOIS DEPARTMENT OF TRANSPORTATION  
 F.A.I. 94/90 (DAN RYAN EXPRESSWAY)  
 31st STREET to I-57  
 TRAFFIC SYSTEMS CENTER (TSC)  
 SITE PLAN  
 SCALE: NOT TO SCALE  
 DATE: October 29, 2004  
 DRAWN BY: DHI  
 CHECKED BY: JEZ

COMM-104

11/23/2004 07:30:27 AM