


|                     |           |                  |              |           |
|---------------------|-----------|------------------|--------------|-----------|
| F.A.I. RTE.         | SECTION   | COUNTY           | TOTAL SHEETS | SHEET NO. |
| 94/90               | 2003-0311 | COOK             | 976          | 895       |
| STA.                |           | TO STA.          |              |           |
| FED. ROAD DIST. NO. | ILLINOIS  | FED. AID PROJECT |              |           |
| 62583               |           |                  |              |           |

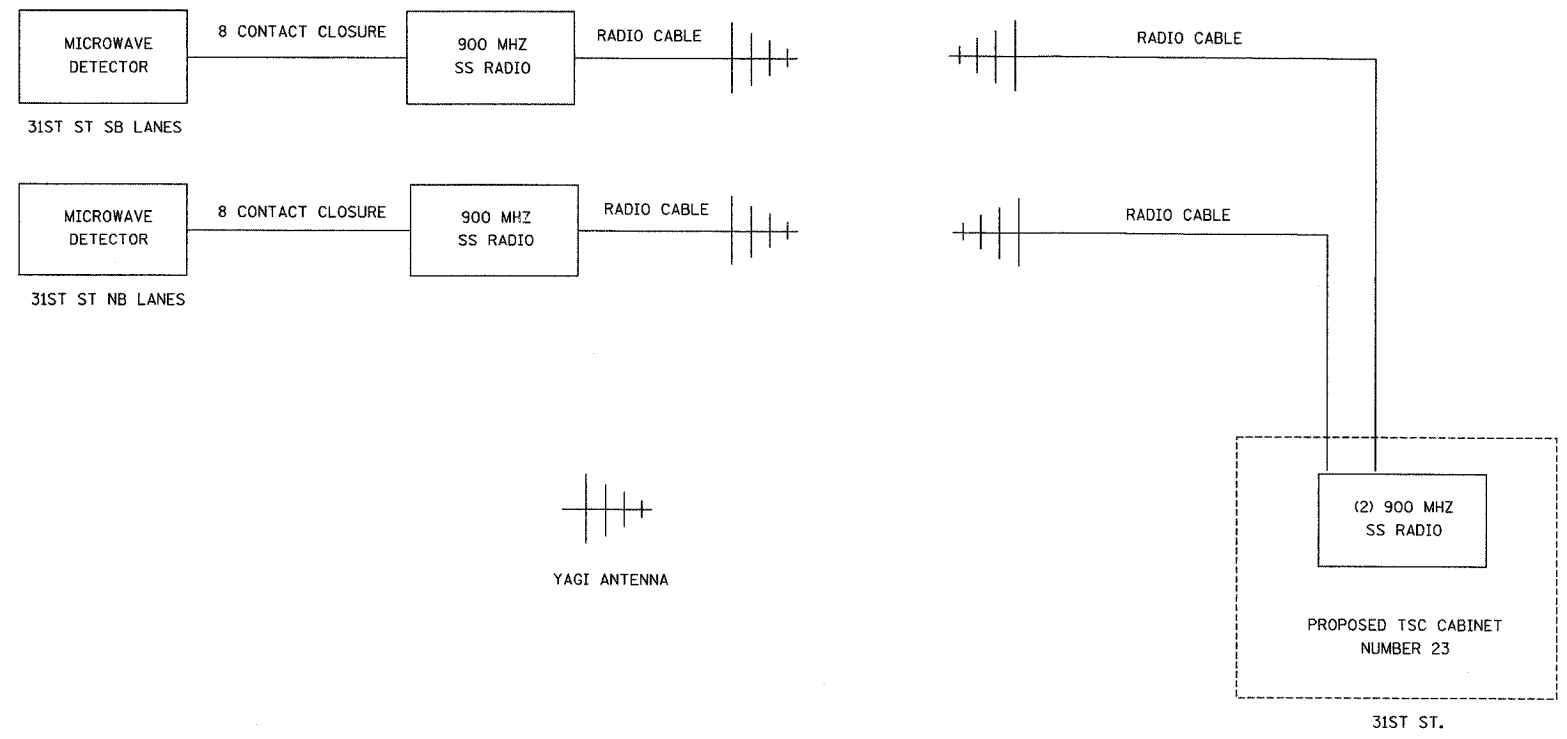

NOTE:  
1. SEE SHEETS DT-53, DT-54, DT-55 FOR SITE INSTALLATION DETAILS.

| REVISIONS |      |
|-----------|------|
| NAME      | DATE |
|           |      |
|           |      |
ILLINOIS DEPARTMENT OF TRANSPORTATION  
F.A.I. 94/90 (DAN RYAN EXPRESSWAY)  
31st STREET to I-57  
TEMPORARY DETECTION  
COMMUNICATIONS LAYOUT  
(Sheet 3 of 3)  
SCALE: N.T.S. DRAWN BY: DHI  
DATE: October 29, 2004 CHECKED BY: JEZ

**Edwards AND Kelcey**  
ONE NORTH FRANKLIN  
CHICAGO, IL 60606  
PHONE: (312) 251-3000  
FAX: (312) 251-3015  
WEB: WWW.EKCORP.COM

P:\030019\035 Vis Card\020312a.dwg 10/19/2004 01:49:00 PM