



BENCHMARK P172 - BIKE TRAIL BRIDGE BRASS PLUG IN SE ABUTMENT OF BRIDGE - ELEV. = 781.69
 BENCHMARK 1 - CHISELED SQUARE ON TOP SE CONCRETE RETAINING WALL @ CLINTON BLVD OVER SUGAR CREEK 200' N. OF EMERSON ST. - ELEV. 773.99
 BENCHMARK 2 - CHISELED SQUARE ON SE CORNER OF CONCRETE BRIDGE RAIL, ON FELL ST. 150' N. OF KELSEY ST. - ELEV. 768.97

NW1/4, SE 1/4, SEC. 33

1608 N. FELL AVENUE



1610 N. FELL AVENUE

1612 N. FELL AVENUE

1309 S. FELL AVENUE

TOTAL SHEET NO. 51 25

WATER SERVICE LOCATIONS		TYPE K COPPER PIPE LENGTH, FT
MAIN CONNECTION	CURB BOX	
STA 10+56.57, 29.70' RT	STA 10+56.57, 34.00' RT	4
STA 11+16.46, 29.30' RT	STA 11+16.46, 34.00' RT	5
STA 11+69.33, 31.00' RT	STA 11+85.37, 56.86' LT	90
STA 13+11.73, 31.00' RT	STA 13+11.73, 33.00' RT	2
STA 13+65.90, 29.60' RT	STA 13+65.90, 34.00' RT	4
STA 13+85.37, 29.70' RT	STA 13+85.37, 24.50' LT	54
STA 14+28.34, 29.90' RT	STA 14+28.35, 34.50' RT	5
STA 14+31.61, 29.90' RT	STA 14+31.61, 24.50' LT	54

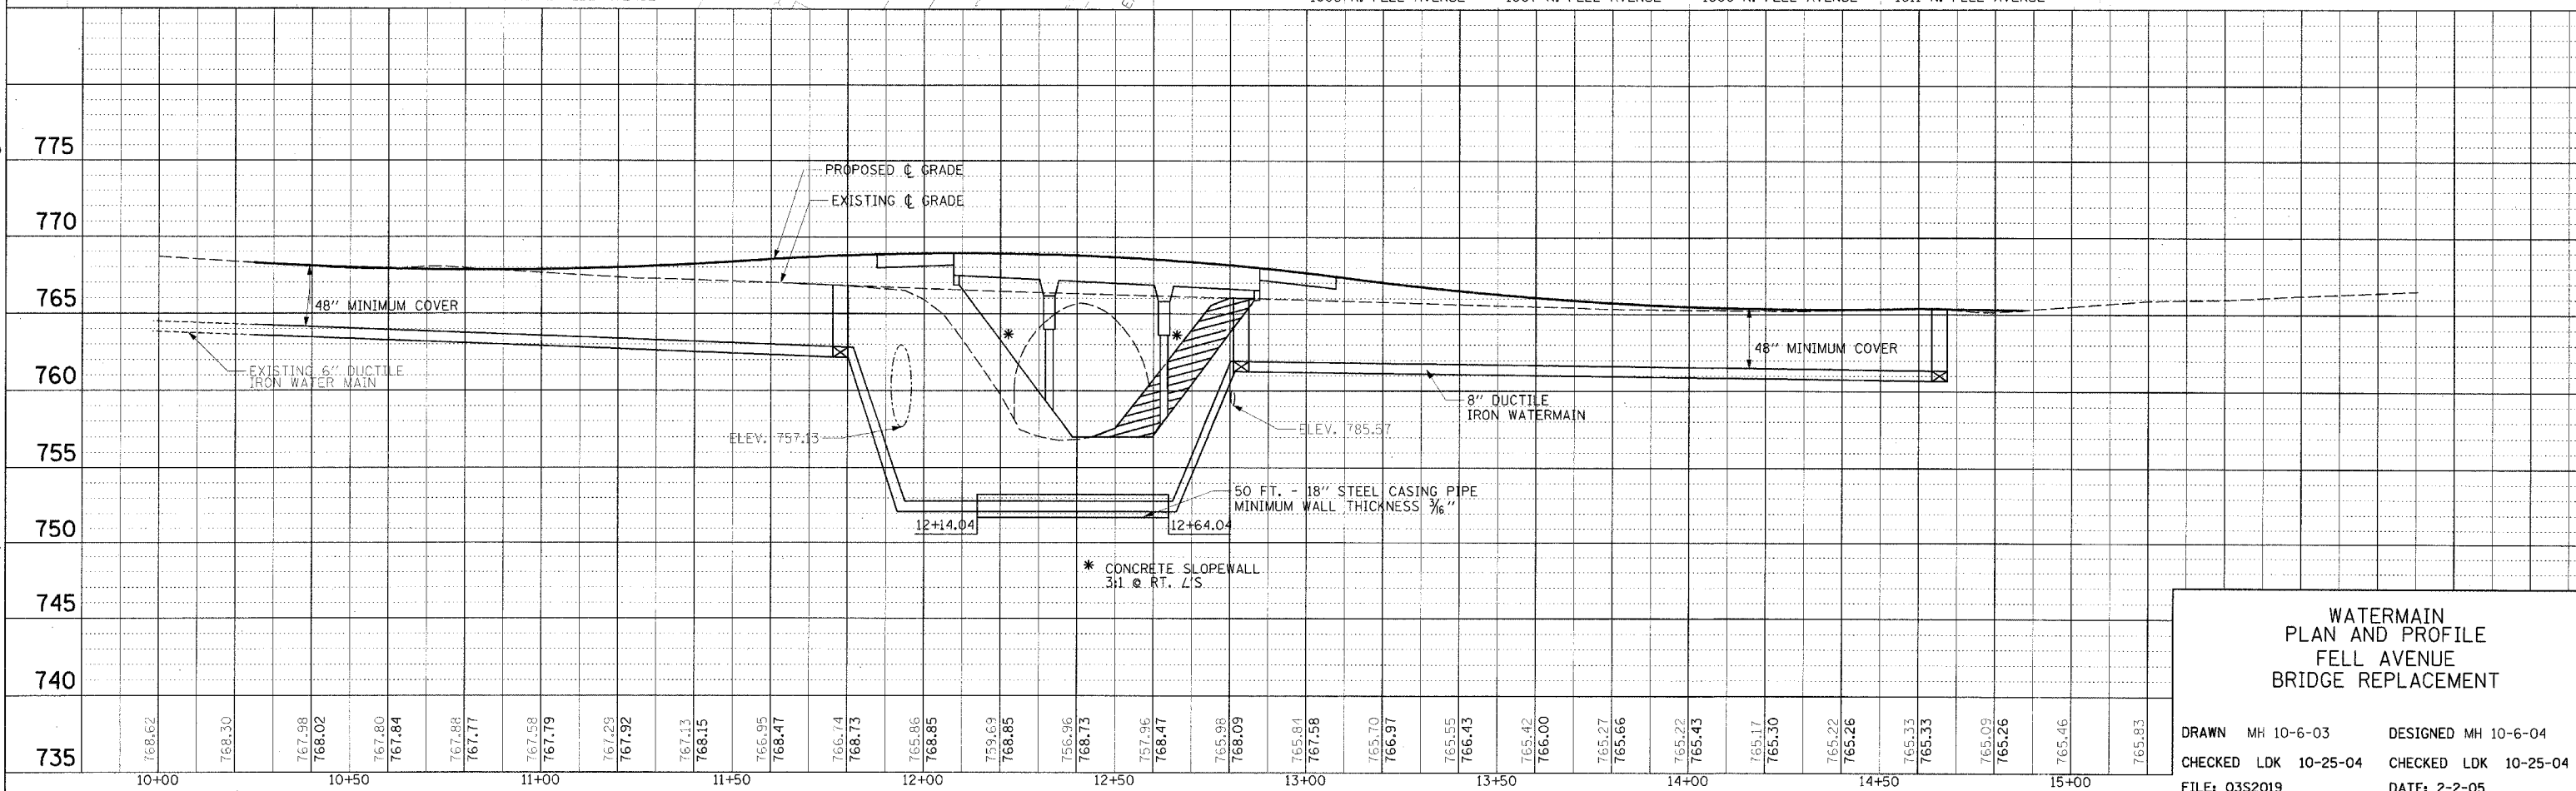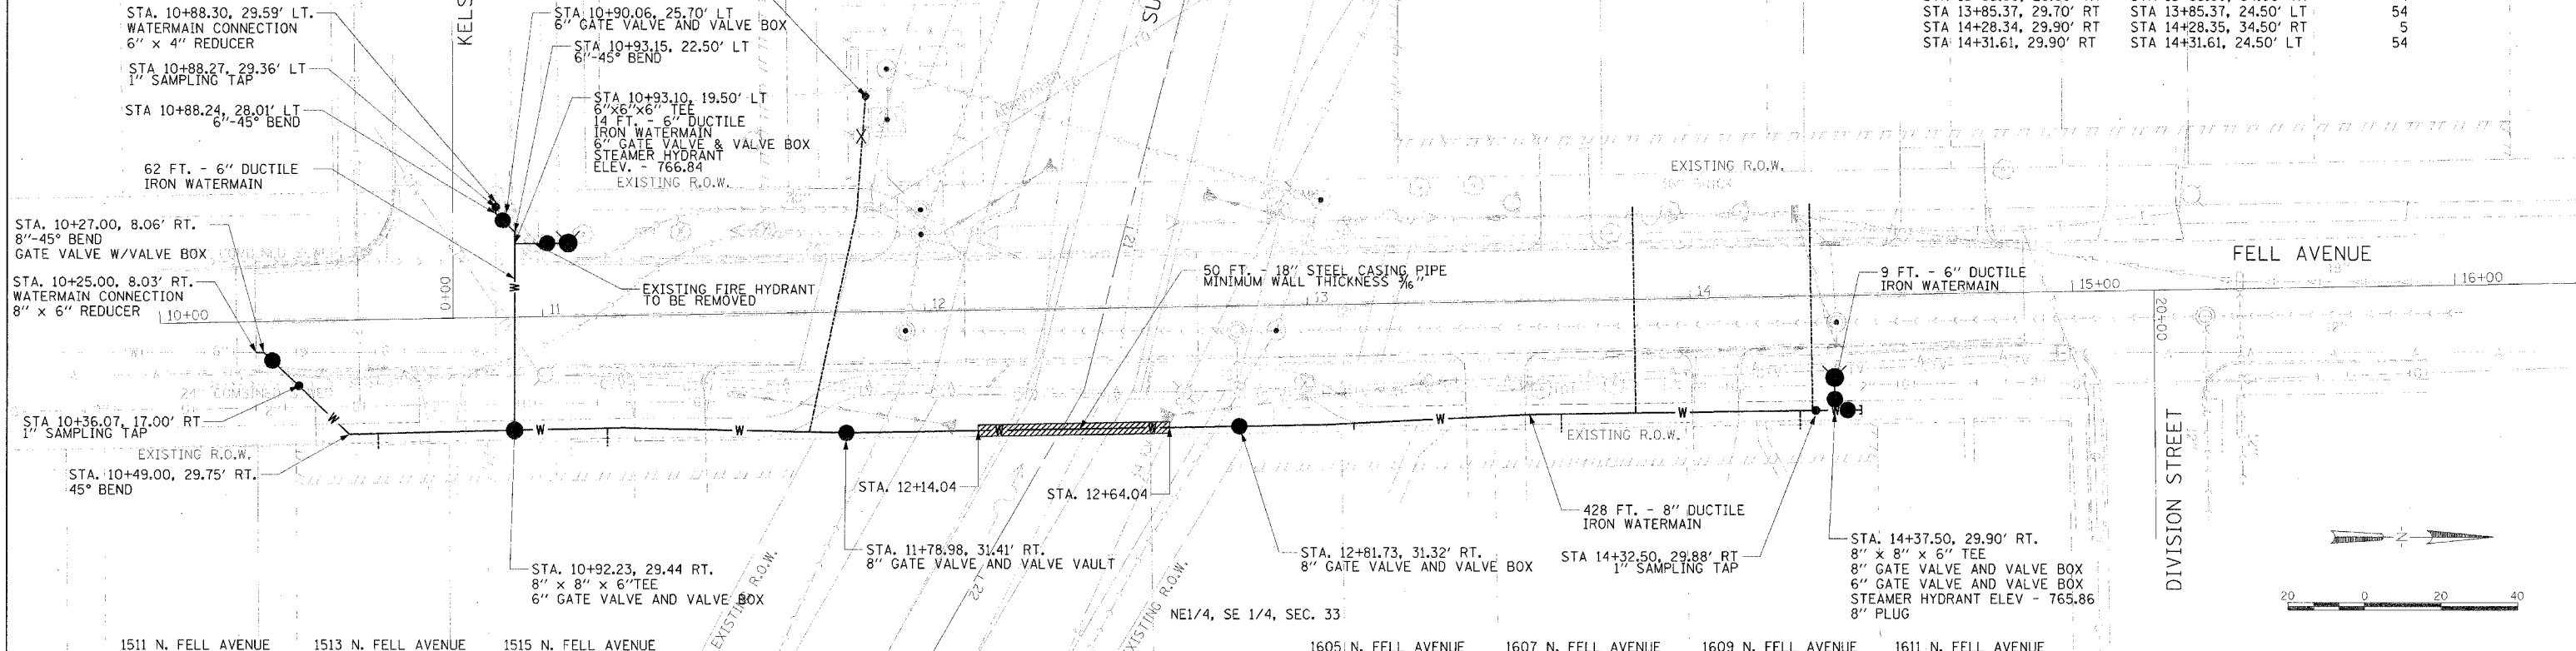

**WATERMAIN
 PLAN AND PROFILE
 FELL AVENUE
 BRIDGE REPLACEMENT**

DRAWN MH 10-6-03 DESIGNED MH 10-6-04
 CHECKED LDK 10-25-04 CHECKED LDK 10-25-04
 FILE: 03S2019 DATE: 2-2-05

02/03/2005
 A:\03\jobs\03s2019\dwg\sheet\c-706-wat.dgn