



 
 




EXISTING LEGEND

	PAVEMENT REMOVAL
	PAVED SHOULDER REMOVAL
	DRIVEWAY PAVEMENT REMOVAL
	TREE REMOVAL WITH UNIT DIAMETER TRUNK
	LINEAL REMOVAL ITEM
	HOT-MIX ASPHALT SURFACE REMOVAL, VARIABLE DEPTH

- NOTES:**
1. SEE ELECTRICAL PLANS FOR LIGHTING REMOVALS.
 2. SEE DRAINAGE PLANS FOR DRAINAGE REMOVALS.
 3. FOR STANDARD SYMBOLS AND PATTERN NOT SHOWN SEE STANDARD 000001-05.
 4. FOR ROW CALL-OUTS SEE PLAT OF HIGHWAYS SHEETS.

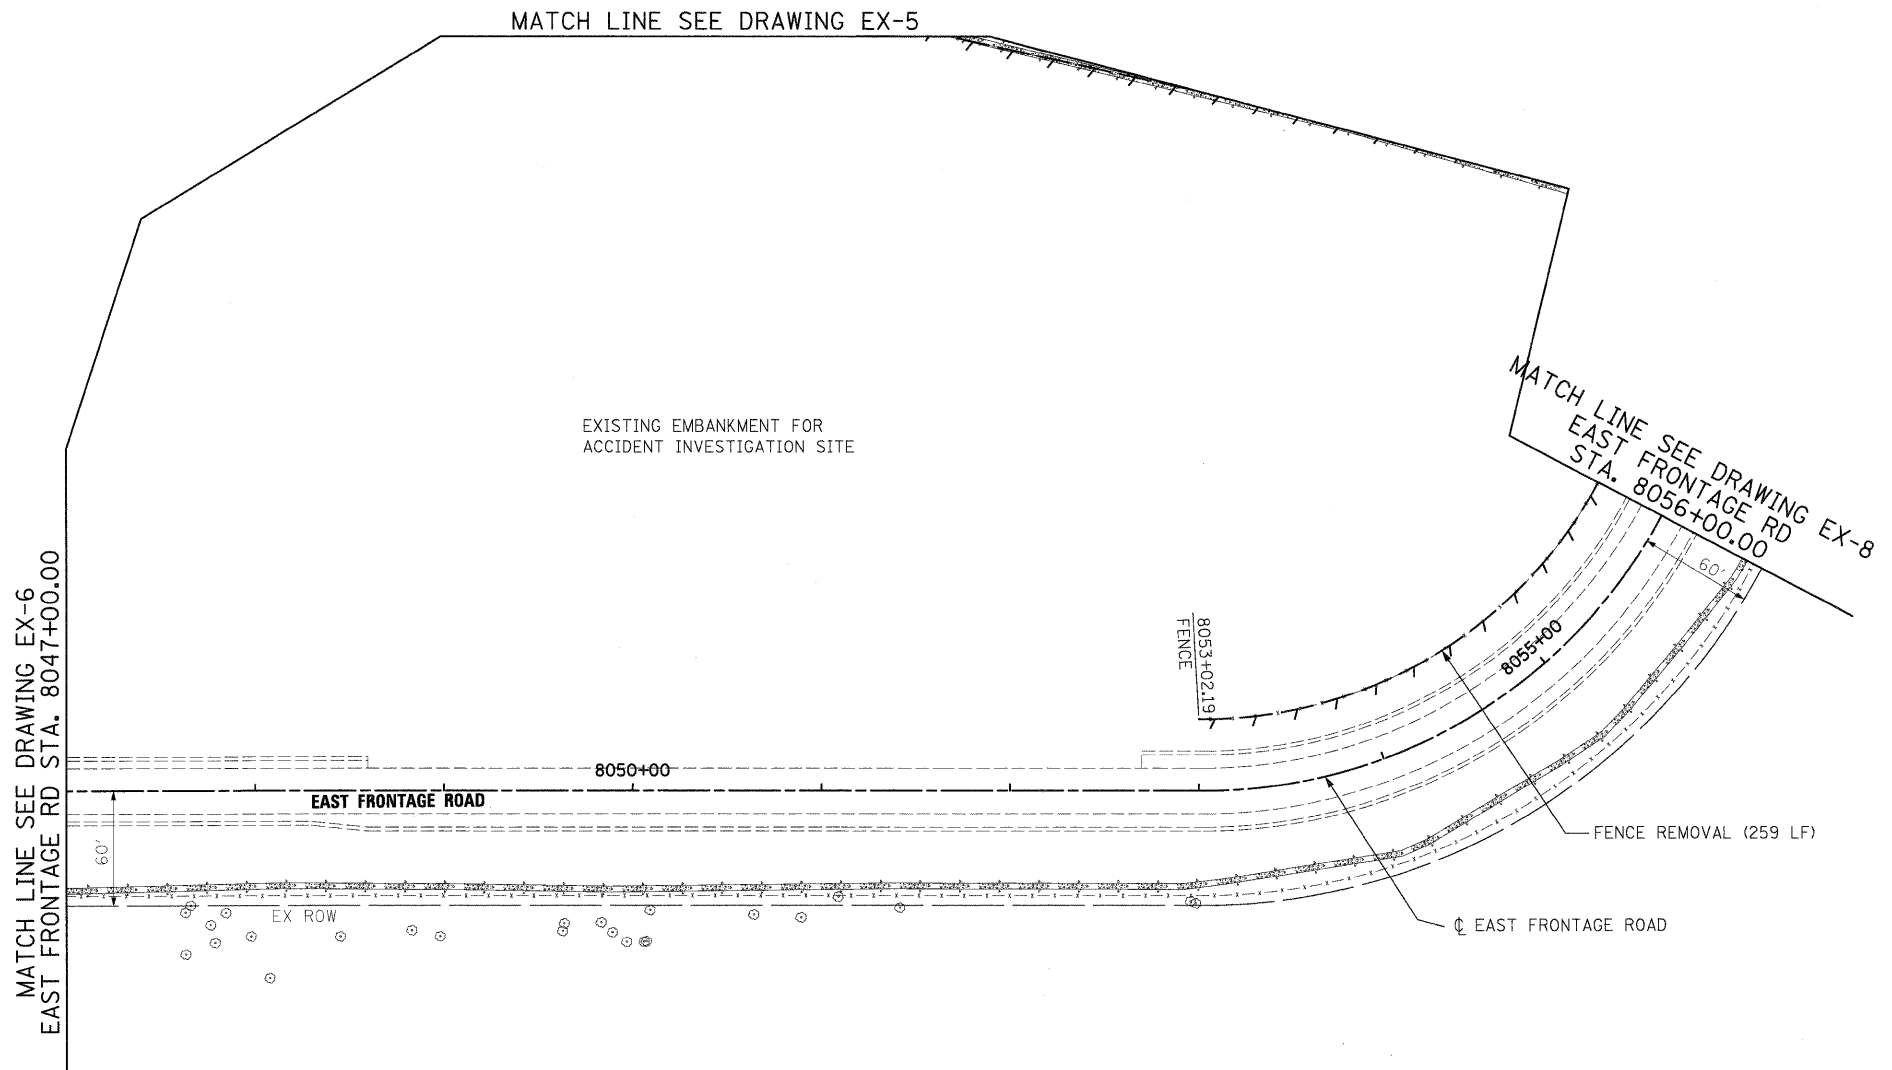

McDonough Associates Inc.
 Engineers / Architects
 130 East Randolph Street Chicago, Illinois 60601

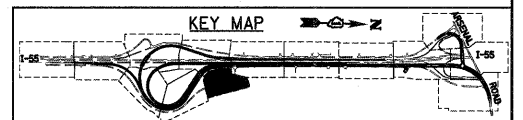

FILE NAME =	DL60F12-SHT-REM07.dgn
-------------	-----------------------

USER NAME =	TKluegel
PLOT SCALE =	1:50
PLOT DATE =	2/3/2011

DESIGNED -	JTF
DRAWN -	JTF
CHECKED -	DLT
DATE -	2/4/11

REVISED -	
REVISED -	
REVISED -	

**STATE OF ILLINOIS
DEPARTMENT OF TRANSPORTATION**

EXISTING PLAN AND REMOVALS	
SCALE: 1"=50'	SHEET NO. 7 OF 15 SHEETS STA. TO STA.

F.A.I. RTE.	SECTION	COUNTY	TOTAL SHEETS	SHEET NO.
55	99-2HB-2B-1	WILL	756	49
CONTRACT NO. 60F12				
FED. ROAD DIST. NO. 1 ILLINOIS FED. AID PROJECT				