




MATCH LINE SEE DRAWING GP-9
WEST FRONTAGE CONNECTOR
STA. 6050+00.00

MATCH LINE SEE DRAWING GP-9
ARSENAL RD STA. 932+50.00

MATCH LINE SEE DRAWING GP-11
WEST FRONTAGE CONNECTOR
STA. 6064+50.00

MATCH LINE SEE DRAWING GP-11
ARSENAL RD STA. 947+00.00

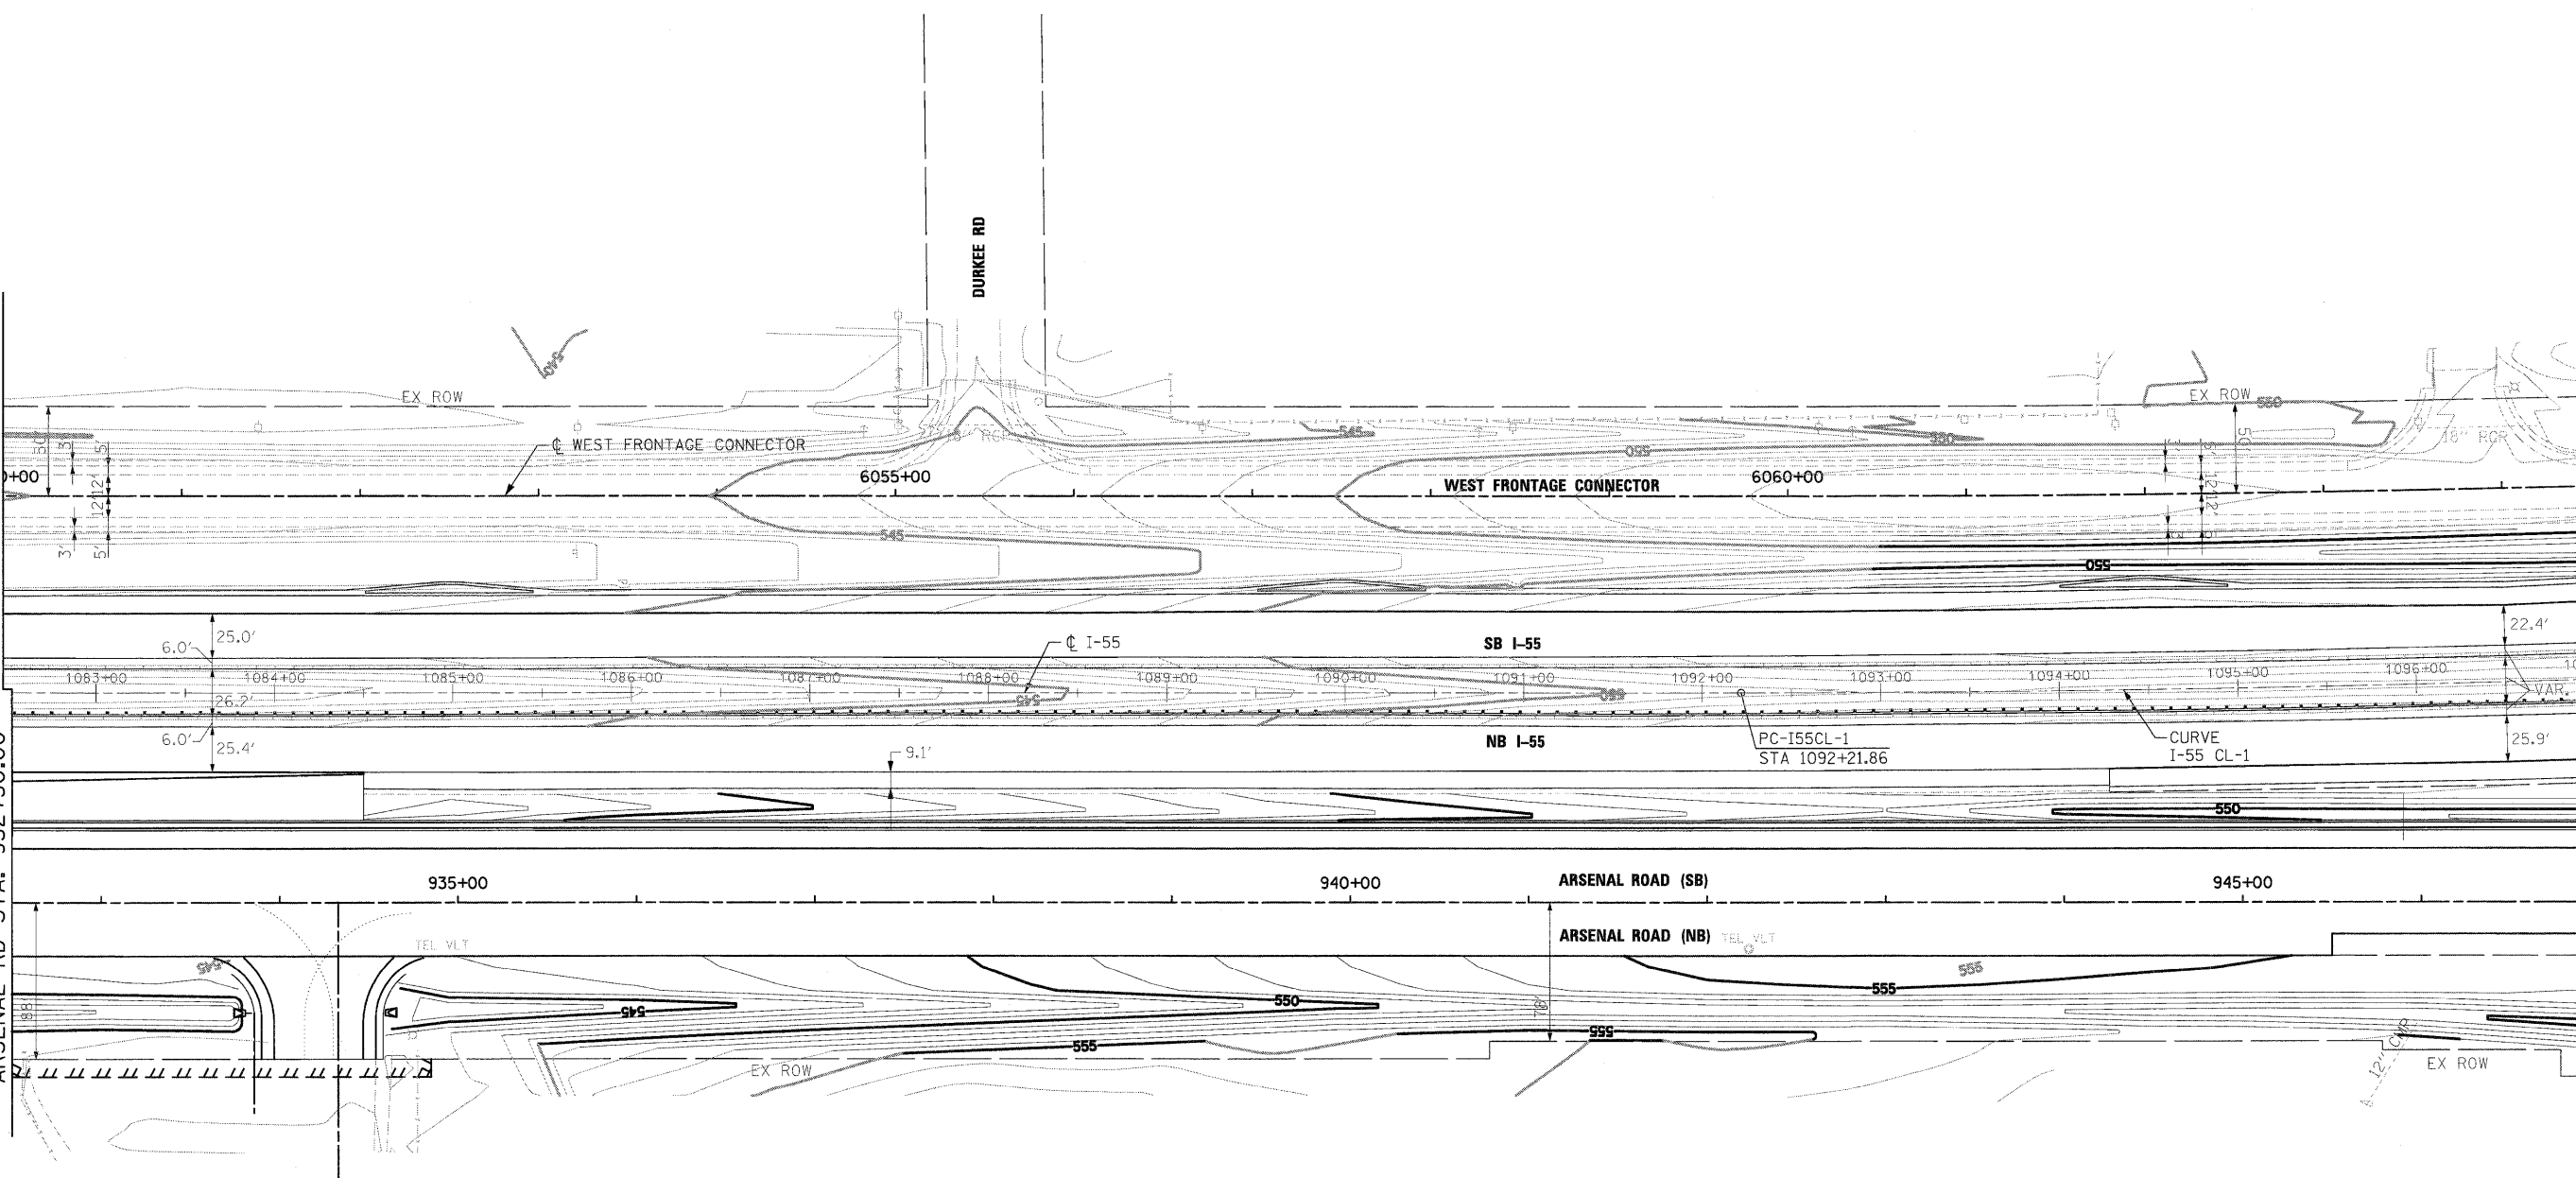

McDonough Associates Inc.
 Engineers / Architects
 130 East Randolph Street, Chicago, Illinois 60601

FILE NAME -
D162F12-SHT-GRADING10.dgn

USER NAME = TK1uegal
 PLOT SCALE = 1:50
 PLOT DATE = 2/3/2011

DESIGNED - MJT
 DRAWN - MJT
 CHECKED - DLT
 DATE - 2/4/11

REVISED -
 REVISED -
 REVISED -
 REVISED -

**STATE OF ILLINOIS
 DEPARTMENT OF TRANSPORTATION**

GRADING PLAN

SCALE: 1"=50' SHEET NO. 10 OF 15 SHEETS STA. TO STA.

F.A.I. RTE.	SECTION	COUNTY	TOTAL SHEETS	SHEET NO.
55	99-2HB-2B-1	WILL	756	214
CONTRACT NO. 60F12				
FED. ROAD DIST. NO. 1 ILLINOIS FED. AID PROJECT				

