




MATCH LINE SEE DRAWING GP-10 WEST FRONTAGE CONNECTOR STA. 6064+50.00


MATCH LINE SEE DRAWING GP-10 ARSENAL RD STA. 947+00.00

MATCH LINE SEE DRAWING GP-12 WEST FRONTAGE CONNECTOR STA. 6014+00.00

MATCH LINE SEE DRAWING GP-13 ARSENAL RD STA. 962+00.00

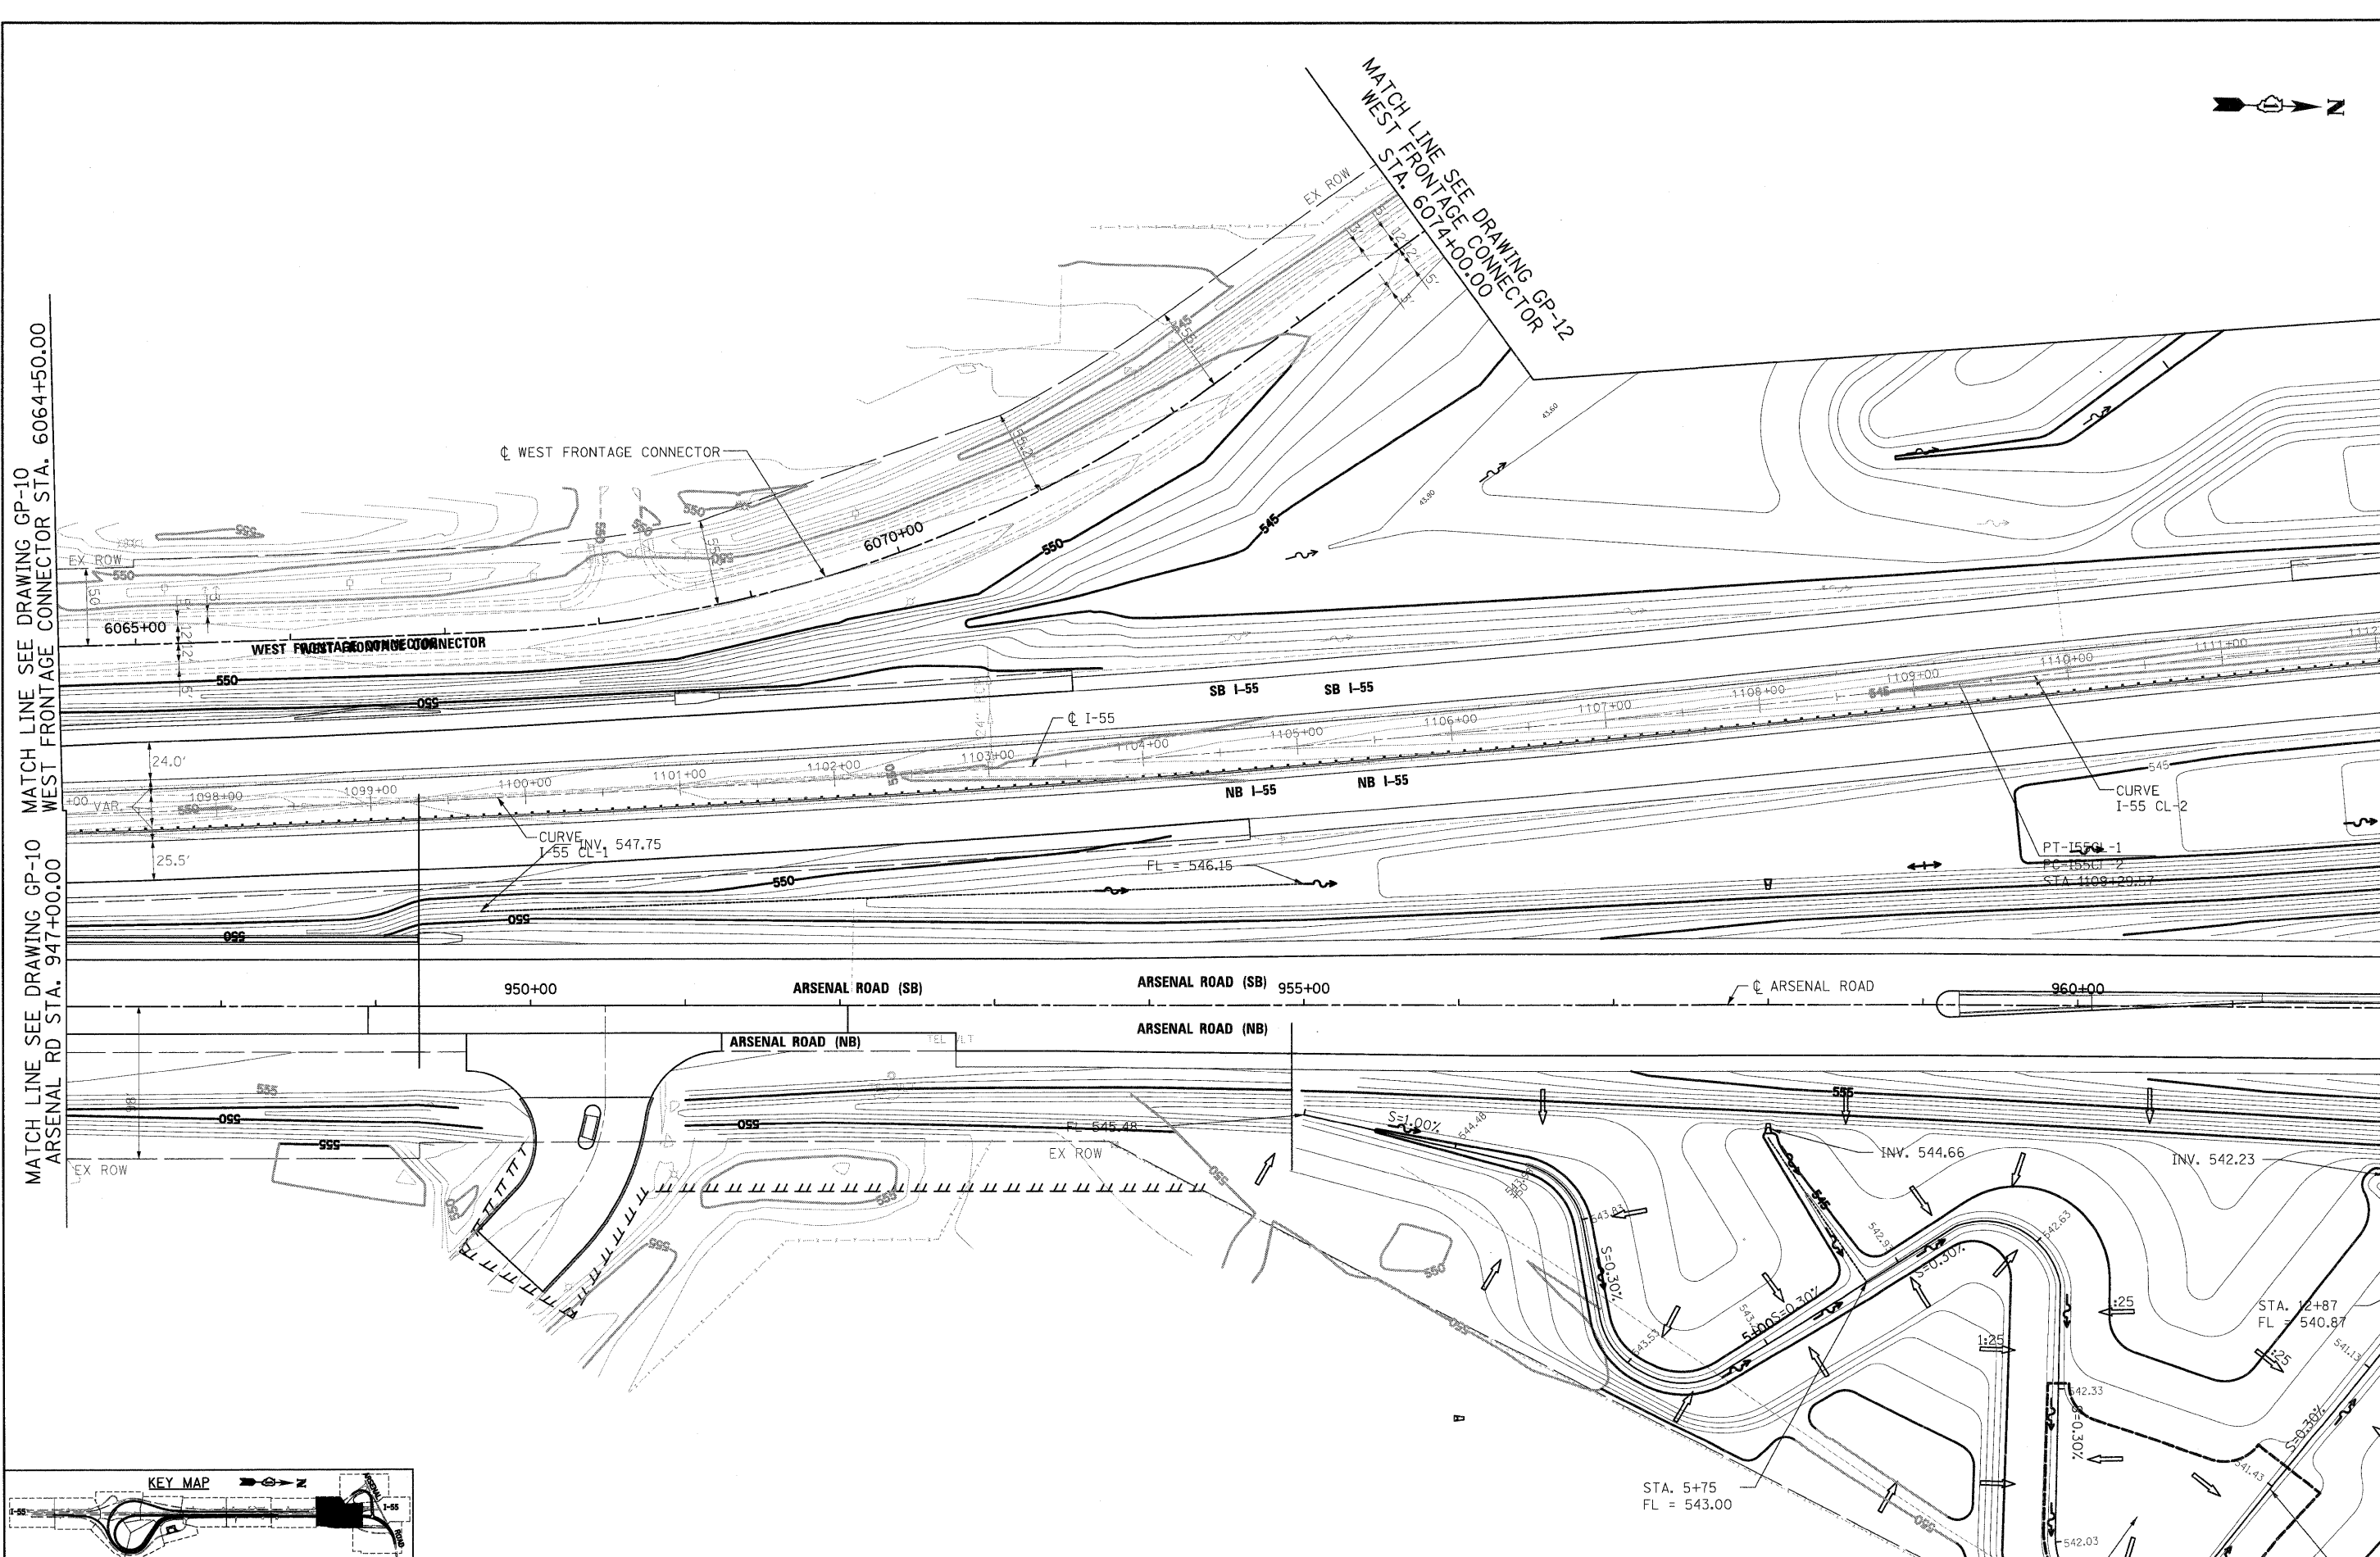

**McDonough Associates Inc.**  
 Engineers / Architects  
 130 East Randolph Street, Chicago, Illinois 60601

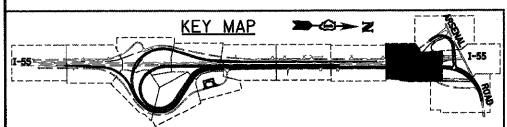

FILE NAME = D:\10012-SHT-GRADING\11.dgn	USER NAME = TKluegel	DESIGNED - MJT	REVISED -
PLDT SCALE = 1:50	CHECKED - DLT	DRAWN - MJT	REVISED -
PLDT DATE = 2/3/2011	DATE = 2/4/11	REVISOR -	REVISED -

**STATE OF ILLINOIS  
 DEPARTMENT OF TRANSPORTATION**

**GRADING PLAN**

SCALE: 1"=50'    SHEET NO. 11 OF 15 SHEETS    STA. TO STA.

F.A.I. RTE. 55	SECTION 99-2HB-28-1	COUNTY WILL	TOTAL SHEETS 756	SHEET NO. 215
CONTRACT NO. 60F12				
FED. ROAD DIST. NO. 1 ILLINOIS FED. AID PROJECT				