
 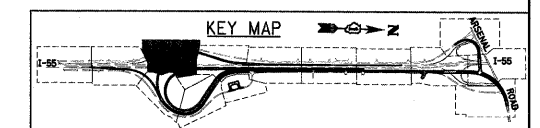


**NOTES:**

1. SEE DRAWING GE-1 FOR ELECTRICAL SYMBOLS AND ABBREVIATIONS. SEE DRAWING GE-2 FOR ELECTRICAL GENERAL NOTES AND SUGGESTED LIGHTING PHASING NOTES.
2. THE CONTRACTOR SHALL REMOVE AND RELOCATE EXISTING LIGHTING UNIT CONSISTING OF 100 FT WOOD POLE WITH 15 FT MAST ARM AND 750W HPS HIGH MAST LUMINAIRE AFTER RAMP D IS CLOSED. THIS WORK SHALL BE INCLUDED IN THE "RELOCATE EXISTING LIGHTING UNIT, SPECIAL" PAY ITEM. SEPARATE PAYMENT WILL NOT BE MADE.
3. THE CONTRACTOR SHALL REMOVE WOOD POLE FOUNDATION AND BACKFILL HOLE. THIS WORK SHALL BE INCLUDED IN THE "REMOVAL OF POLE FOUNDATION" PAY ITEM. SEPARATE PAYMENT WILL NOT BE MADE.



**McDonough Associates Inc.**  
 Engineers / Architects  
 130 East Randolph Street, Chicago, Illinois 60601

FILE NAME = D:\62\F12-SHT-RL1-3.dgn	USER NAME = TKLuegel	DESIGNED - JLW	REVISED -
PLOT SCALE = 1:50	DRAWN - CJM	CHECKED - KMY	REVISED -
PLOT DATE = 3/3/2011	DATE = 2/4/11		REVISED -

**STATE OF ILLINOIS**  
**DEPARTMENT OF TRANSPORTATION**

**I-55 AT ARSENAL ROAD**  
**PROPOSED ROADWAY LIGHTING PLAN-STAGE 1 DEMOLITION**

SCALE: 1" = 50'    SHEET NO. 3 OF 10 SHEETS    STA.    TO STA.

F.A.I. RTE.	SECTION	COUNTY	TOTAL SHEETS	SHEET NO.
55	99-2HB-2B-1	WILL	756	351
CONTRACT NO. 60F12				