


MATCH LINE SEE DRAWING RL2-9
WEST FRONTAGE CONNECTOR
6050+00.00

MATCH LINE SEE DRAWING RL2-11
WEST FRONTAGE CONNECTOR
6064+50.00


 
MATCH LINE
SEE DRAWING RL2-9
ARSENAL RD 932+50.00

MATCH LINE
SEE DRAWING RL2-11
ARSENAL RD 947+00.00

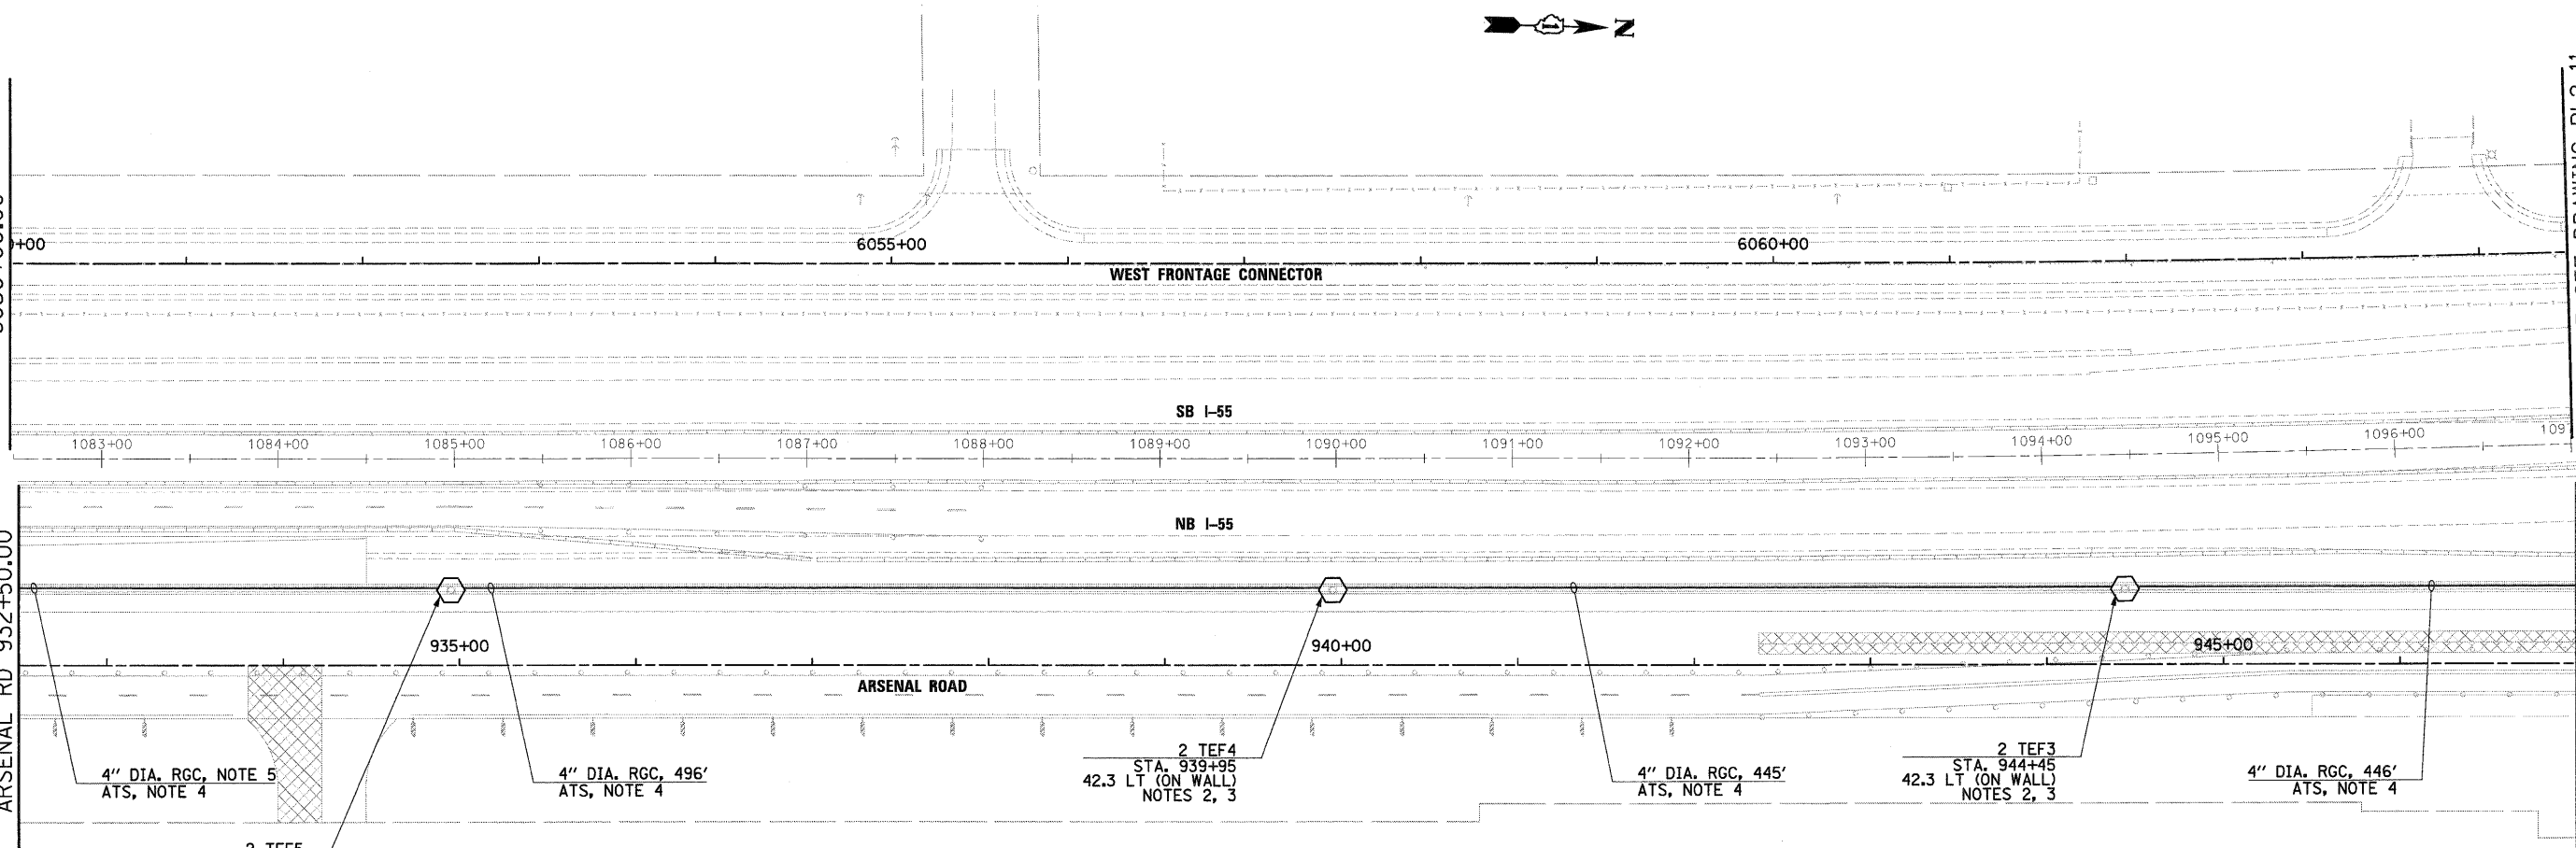

NOTES:

1. SEE DRAWING GE-1 FOR ELECTRICAL SYMBOL LIST AND ABBREVIATIONS. SEE DRAWING GE-2 FOR ELECTRICAL GENERAL NOTES AND SUGGESTED LIGHTING PHASING NOTES.
2. WORK SHOWN ON THIS DRAWING WILL BE DONE IN STAGES 2, 3, AND 4. INSTALL CONDUITS AND GROUND ROD FOR EACH HIGH MAST TOWER LOCATED ALONG THE RETAINING WALL AS THE TOWER FOUNDATION IS BEING CONSTRUCTED. THIS WORK SHALL BE INCLUDED IN THE "LIGHT TOWER FOUNDATION, 54" DIAMETER" PAY ITEM. SEPARATE PAYMENT WILL NOT BE MADE.
3. SEE DRAWINGS S-1 AND ED-1 FOR HIGH MAST LIGHT TOWER FOUNDATIONS INTEGRAL WITH RETAINING WALL DETAILS.
4. PROVIDE 4" RGS CONDUIT BETWEEN HIGH MAST TOWERS LOCATED ALONG THE RETAINING WALL AFTER RETAINING WALL IS CONSTRUCTED AND PRIOR TO CONSTRUCTION OF THE BARRIER WALL. CONDUIT SHALL BE ATTACHED TO THE EAST SIDE OF THE RETAINING WALL. PROVIDE WATERTIGHT SEAL AT CONDUIT OPENINGS. THIS WORK SHALL BE INCLUDED IN THE "CONDUIT ATTACHED TO STRUCTURE, 4" DIA., GALVANIZED STEEL" PAY ITEM. SEPARATE PAYMENT WILL NOT BE MADE.
5. LENGTH NOT SHOWN. SEE DRAWING RL2-9 FOR RUN LENGTH.
6. INDICATES TEMPORARY PAVEMENT INSTALLATION LIMITS. SEE MAINTENANCE OF TRAFFIC DRAWINGS FOR CONSTRUCTION STAGING INFORMATION.

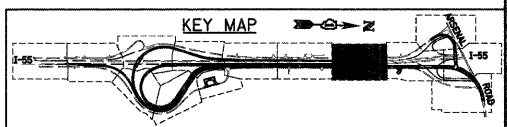

McDonough Associates Inc.
 Engineers / Architects
 130 East Randolph Street Chicago, Illinois 60601

FILE NAME = D162F12-SHT-RL2-10.dgn	USER NAME = TK\uegl	DESIGNED - JLW	REVISED -
		DRAWN - CJM	REVISED -
	PLOT SCALE = 1/50	CHECKED - KMY	REVISED -
	PLOT DATE = 2/3/2011	DATE - 2/4/11	REVISED -

**STATE OF ILLINOIS
DEPARTMENT OF TRANSPORTATION**

**I-55 AT ARSENAL ROAD
PROPOSED ROADWAY LIGHTING PLAN-STAGE 2**

SCALE: 1" = 50' SHEET NO. 10 OF 12 SHEETS STA. TO STA.

F.A.I. RTE. 55	SECTION 99-2HB-2B-1	COUNTY WILL	TOTAL SHEETS 756	SHEET NO. 368
FED. ROAD DIST. NO. 1 [ILLINOIS] FED. AID PROJECT			CONTRACT NO. 60F12	