


 
MATCH LINE SEE DRAWING RL-4
 EAST FRONTAGE RD 8033+00.00
 NB I-55 ENTRANCE 3018+96.00
 SB I-55 EXIT 106+76.68

MATCH LINE SEE DRAWING RL-5
 NB I-55 ENTRANCE 3005+00.00
 SB I-55 EXIT 121+62.75

MATCH LINE SEE DRAWING RL-7
 EAST FRONTAGE RD 8047+00.00

NOTES:

- SEE DRAWING GE-1 FOR ELECTRICAL SYMBOL LIST AND ABBREVIATIONS.
- SEE DRAWING S-3 FOR HIGH MAST LIGHT TOWER FOUNDATION TABLE.

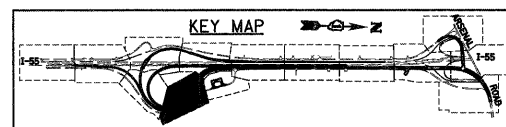

McDonough Associates Inc.
 Engineers / Architects
 130 East Randolph Street, Chicago, Illinois 60601

FILE NAME = D160F12-SMT-RL-6.dgn	USER NAME = TK1uege1	DESIGNED - JLW	REVISED -
		DRAWN - CJM	REVISED -
		CHECKED - KMY	REVISED -
		DATE - 2/4/11	REVISED -

STATE OF ILLINOIS
DEPARTMENT OF TRANSPORTATION

I-55 AT ARSENAL ROAD
PROPOSED ROADWAY LIGHTING PLAN FINAL CONDITIONS

SCALE: 1" = 50' SHEET NO. 6 OF 14 SHEETS STA. TO STA.

F.A.I. RTE.	SECTION	COUNTY	TOTAL SHEETS	SHEET NO.
55	99-2HB-2B-1	WILL	756	395
				CONTRACT NO. 60F12
FED. ROAD DIST. NO. 1 ILLINOIS FED. AID PROJECT				