

MATCH LINE SEE DRAWING RL-5  
W. FRONTAGE CONN. 6021+00.00  
SB EXIT RAMP 2005+51.17

MATCH LINE SEE DRAWING RL-9  
WEST FRONTAGE  
CONNECTOR 6035+50.00


 
MATCH LINE SEE DRAWING RL-5  
ARSENAL ROAD 904+00.00  
NB ENTRANCE RAMP 3050+85.37

MATCH LINE SEE DRAWING RL-9  
ARSENAL RD 918+00.00

MATCH LINE SEE DRAWING RL-7  
EAST FRONTAGE RD 8056+00.00

**NOTES:**

1. SEE DRAWING GE-1 FOR ELECTRICAL SYMBOL LIST AND ABBREVIATIONS.
2. SEE DRAWINGS S-1 AND S-3 FOR HIGH MAST LIGHT TOWER FOUNDATION TABLES.
3. LENGTH NOT SHOWN, SEE DRAWING RL-5 FOR RUN LENGTH.

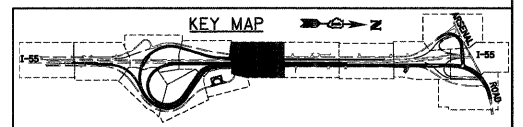

FILE NAME = D162P12-SHT-RL-8.dgn	USER NAME = TKluegel	DESIGNED - JLW	REVISED -
		DRAWN - CJM	REVISED -
	PLOT SCALE = 1:50	CHECKED - KMY	REVISED -
	PLOT DATE = 2/3/2011	DATE - 2/4/11	REVISED -

**STATE OF ILLINOIS  
DEPARTMENT OF TRANSPORTATION**

**I-55 AT ARSENAL ROAD  
PROPOSED ROADWAY LIGHTING PLAN FINAL CONDITIONS**

SCALE: 1" = 50' SHEET NO. 8 OF 14 SHEETS STA. TO STA.

F.A.I. RTE. 55	SECTION 99-2HB-2B-1	COUNTY WILL	TOTAL SHEETS 756	SHEET NO. 397
FED. ROAD DIST. NO. 1 ILLINOIS FED. AID PROJECT			CONTRACT NO. 60F12	