

MATCH LINE SEE DRAWING RL-13
 ARSENAL RD STA. 970+50.00

G&H: 3*2 & 1*4 GND.
 1/2" DIA. UNIT DUCT

2 TGH7
 STA. 971+78
 76 LT (43 LT EOP)

G&H: 3*2 & 1*4 GND.
 1/2" DIA. UNIT DUCT


 
2 TGH8
 STA. 975+59
 74 LT (41 LT EOP)

G&H: 3*2 & 1*4 GND.
 1/2" DIA. UNIT DUCT

2 TGH9
 STA. 979+60
 71 LT (68 LT EOP)

NOTES:

1. SEE DRAWING GE-1 FOR ELECTRICAL SYMBOL LIST AND ABBREVIATIONS.
2. SEE DRAWING S-3 FOR HIGH MAST LIGHT TOWER FOUNDATION TABLE.

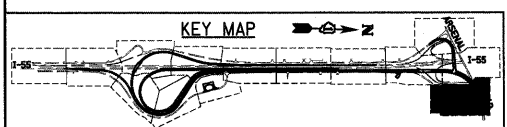

McDonough Associates Inc.
 Engineers / Architects
 130 East Randolph Street Chicago, Illinois 60601

FILE NAME = D:\B0\F12-SHT-RL-14.dgn	USER NAME = TKluegel	DESIGNED - JLW	REVISED -
	PLDT SCALE = 1:50	DRAWN - CJM	REVISED -
	PLDT DATE = 2/3/2011	CHECKED - KMY	REVISED -
		DATE - 2/4/11	REVISED -

STATE OF ILLINOIS
 DEPARTMENT OF TRANSPORTATION

I-55 AT ARSENAL ROAD
 PROPOSED ROADWAY LIGHTING PLAN FINAL CONDITIONS

SCALE: 1" = 50' SHEET NO. 14 OF 14 SHEETS STA. TO STA.

F.A.I. RTE.	SECTION	COUNTY	TOTAL SHEETS	SHEET NO.
55	99-2HB-2B-1	WILL	756	403
CONTRACT NO. 60F12				
FED. ROAD DIST. NO. 1 ILLINOIS FED. AID PROJECT				