
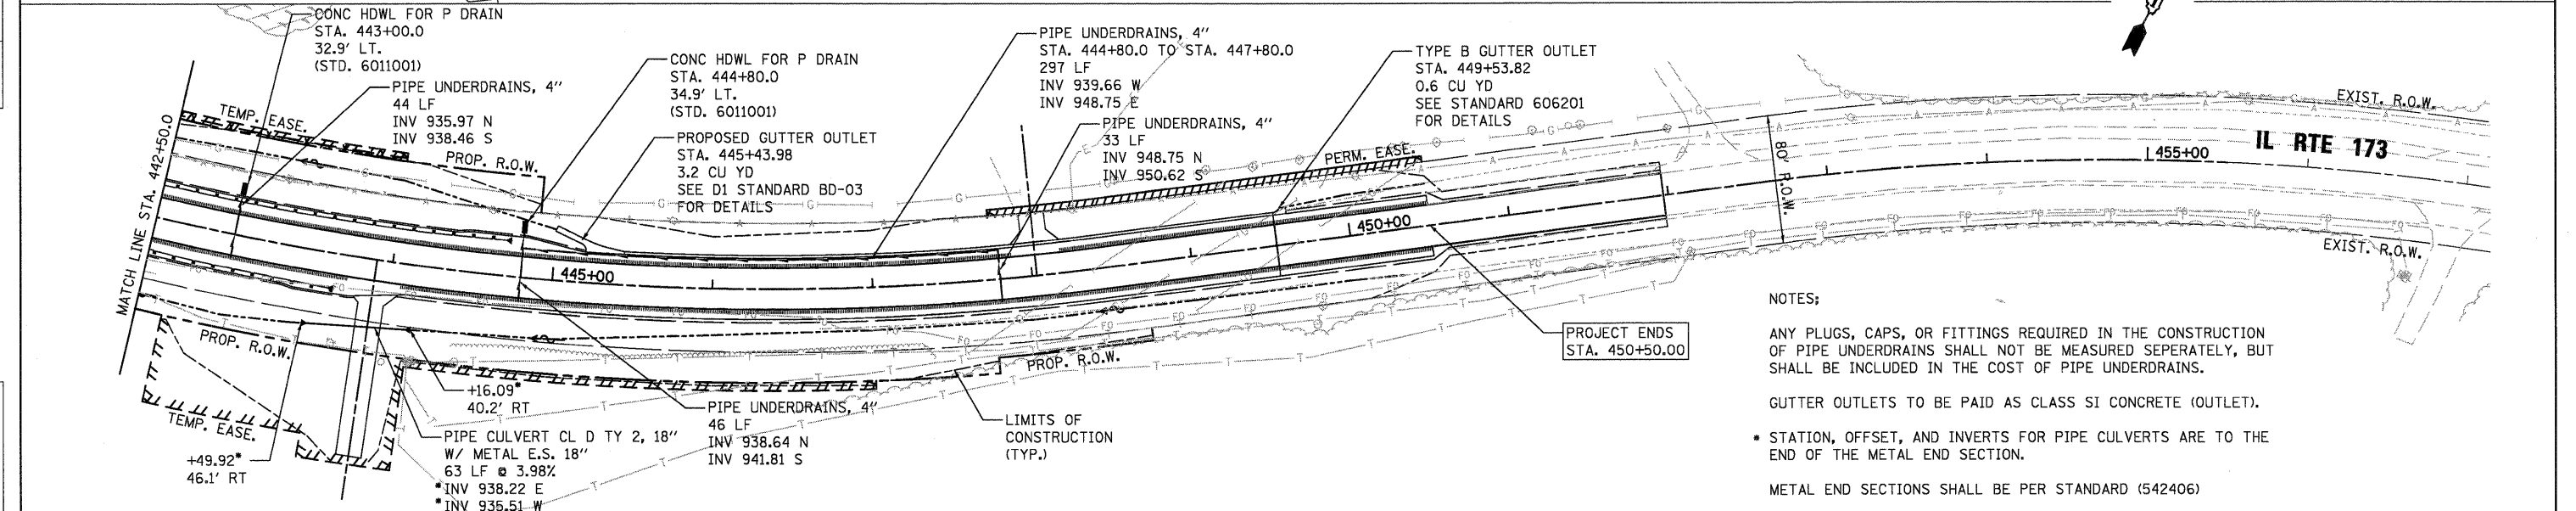



DATE	
BY	
SURVEYED	
PLOTTED	
GRADES CHECKED	
STRUCTURE NOTATIONS CHECKED	
NOTE BOOK NO.	
CADD FILE NAME	

DATE	
BY	
PROFILE	
PLOTTED	
GRADES CHECKED	
STRUCTURE NOTATIONS CHECKED	
NOTE BOOK NO.	
CADD FILE NAME	

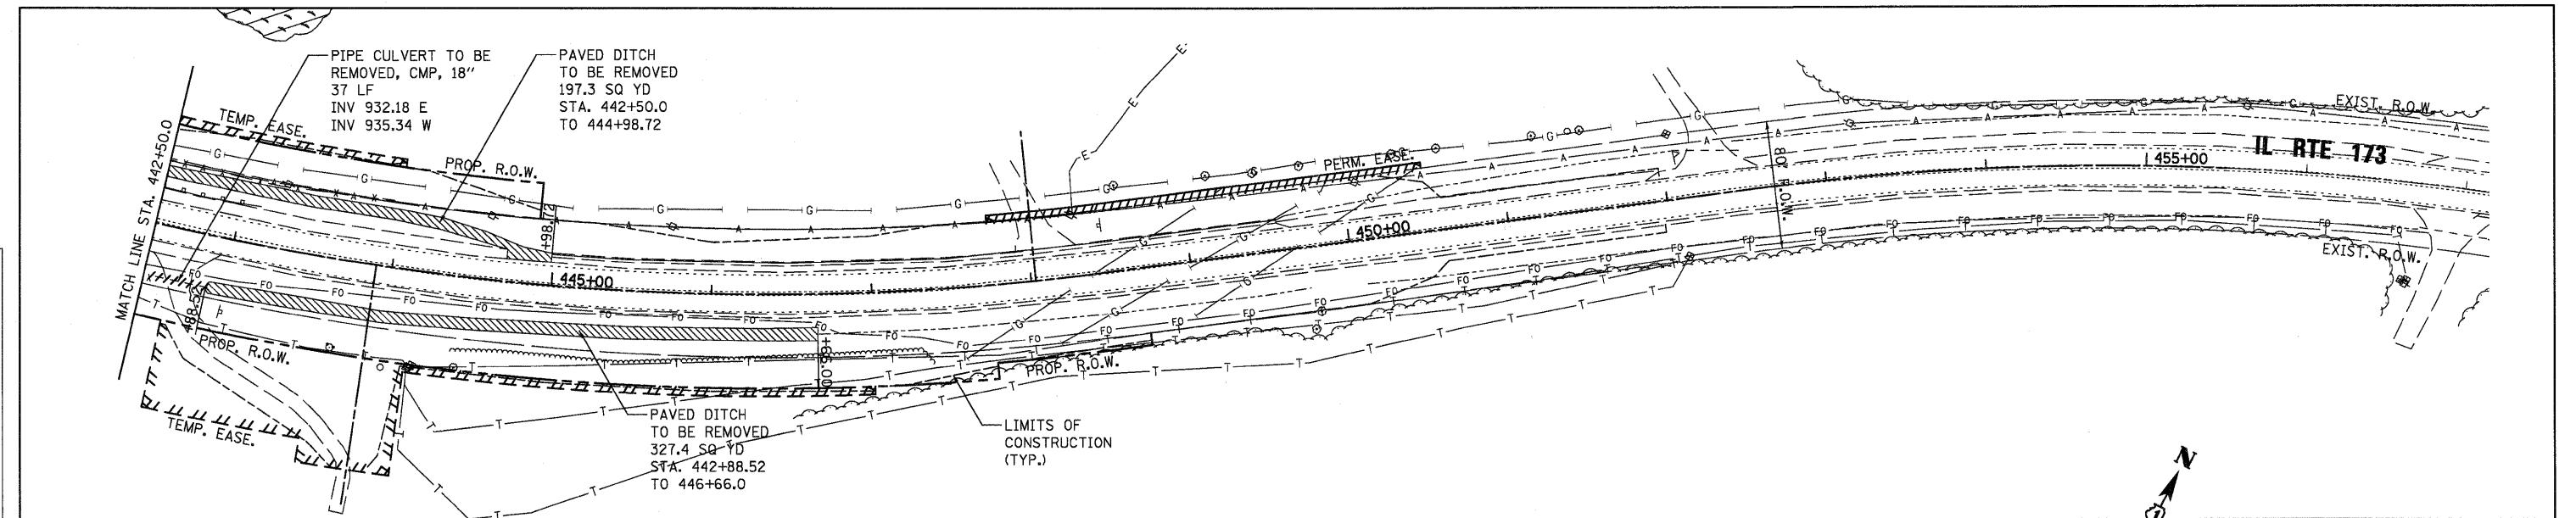

NOTES:

- ANY PLUGS, CAPS, OR FITTINGS REQUIRED IN THE CONSTRUCTION OF PIPE UNDERDRAINS SHALL NOT BE MEASURED SEPARATELY, BUT SHALL BE INCLUDED IN THE COST OF PIPE UNDERDRAINS.
- GUTTER OUTLETS TO BE PAID AS CLASS SI CONCRETE (OUTLET).
- STATION, OFFSET, AND INVERTS FOR PIPE CULVERTS ARE TO THE END OF THE METAL END SECTION.
- METAL END SECTIONS SHALL BE PER STANDARD (542406)

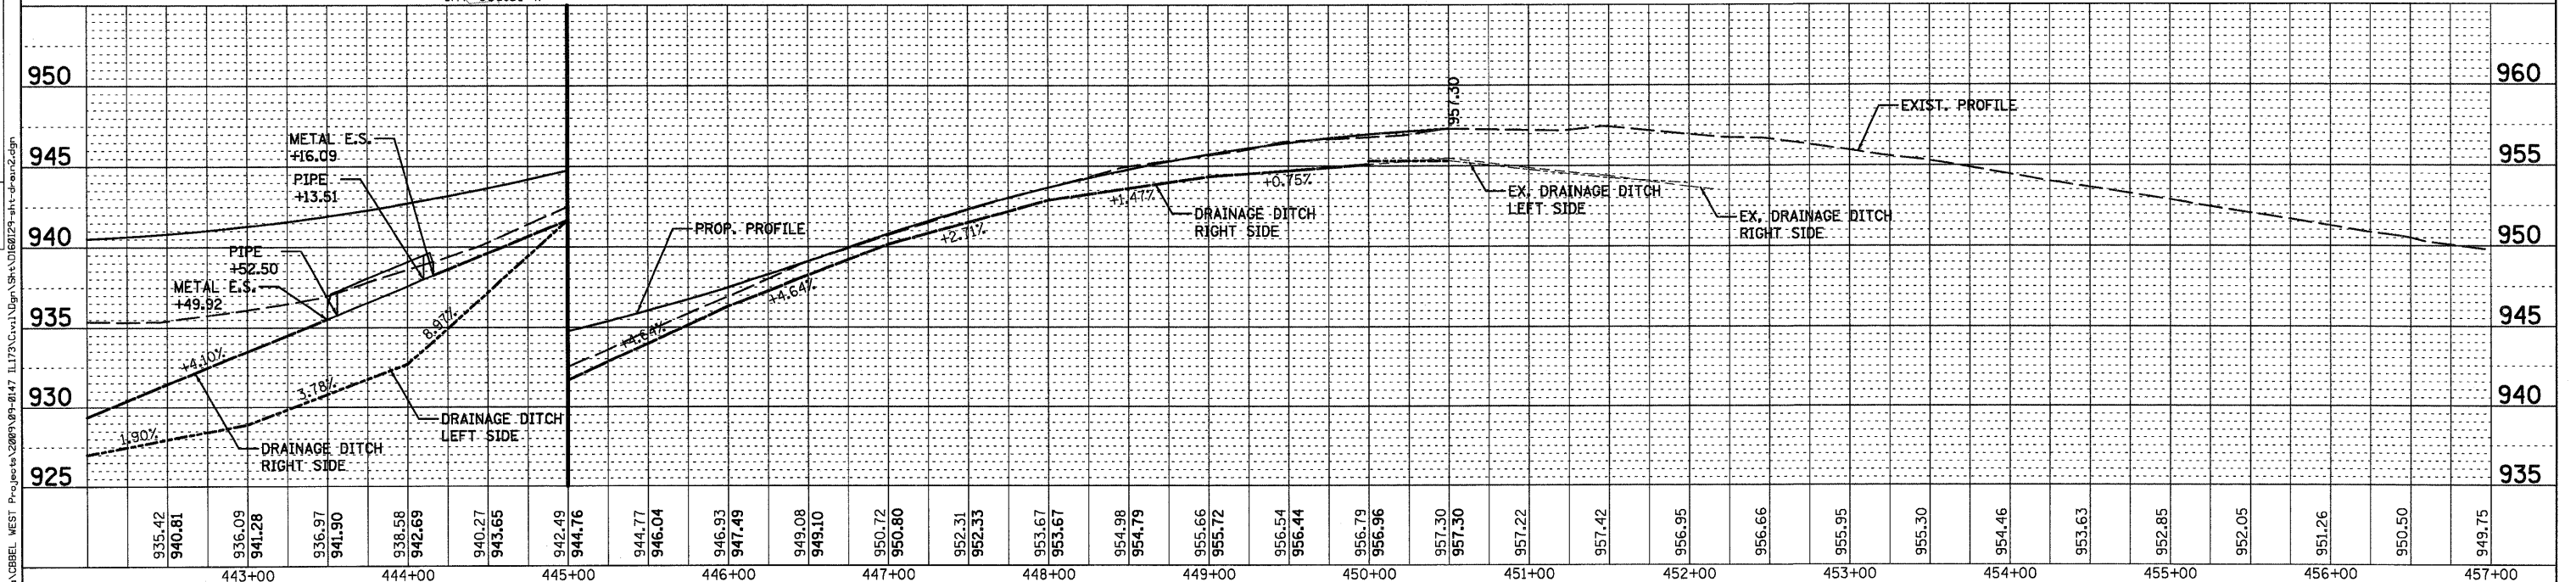

935.42	940.81	936.09	941.28	936.97	941.90	938.58	942.69	940.27	943.65	942.49	944.76	944.77	946.04	946.93	947.49	949.08	949.10	950.72	950.80	952.31	952.33	953.67	953.67	954.98	954.79	955.66	955.72	956.54	956.44	956.79	956.96	957.30	957.30	957.22	957.42	956.95	956.66	955.95	955.30	954.46	953.63	952.85	952.05	951.26	950.50	949.75
443+00		444+00		445+00		446+00		447+00		448+00		449+00		450+00		451+00		452+00		453+00		454+00		455+00		456+00		457+00																		

WILLS BURKE KELSEY ASSOCIATES LTD.
118 West Main Street, Suite 201
St. Charles, Illinois 60174
(830) 443-7795

USER NAME = #USER#	DESIGNED - SBP/KMA	REVISED -
PLLOT SCALE =	DRAWN - NDP	REVISED -
PLLOT DATE = 1/5/2011	CHECKED - P/JF	REVISED -
	DATE - 12/14/10	REVISED -

STATE OF ILLINOIS
DEPARTMENT OF TRANSPORTATION

DRAINAGE PLAN & PROFILE	
SCALE:	SHEET NO. 33 OF 106 SHEETS STA. 442+50.0 TO STA. 452+15.0

F.A.P. RTE. 303	SECTION 132 B-2	COUNTY McHENRY	TOTAL SHEETS 106	SHEET NO. 33
CONTRACT NO. 60I29				
FED. ROAD DIST. NO. [ILLINOIS] FED. AID PROJECT				