
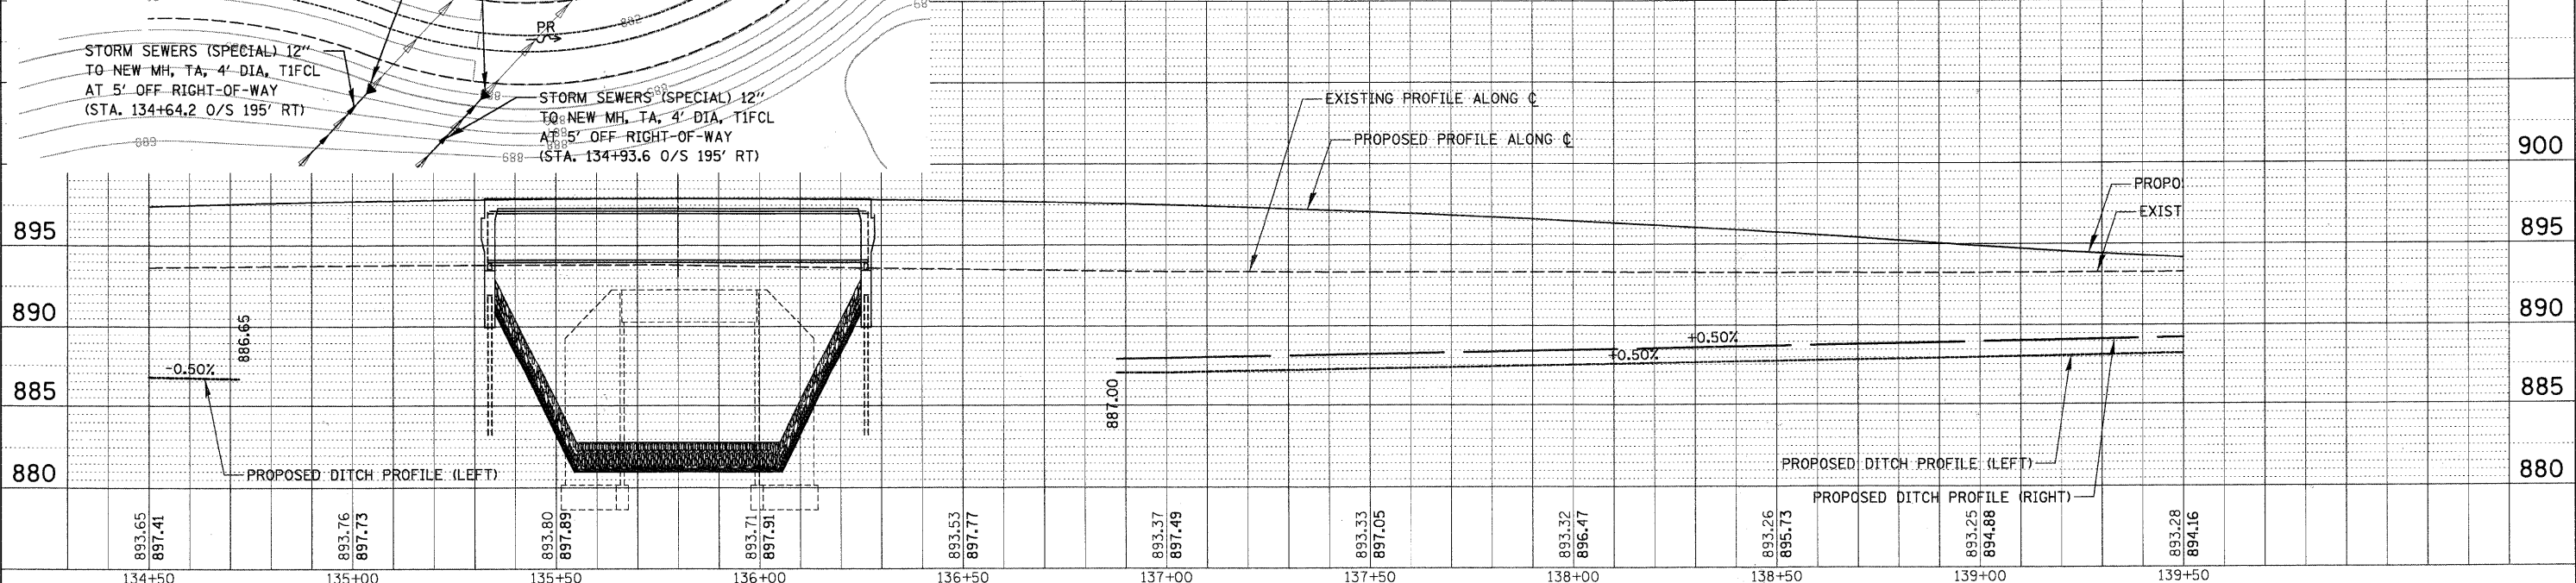
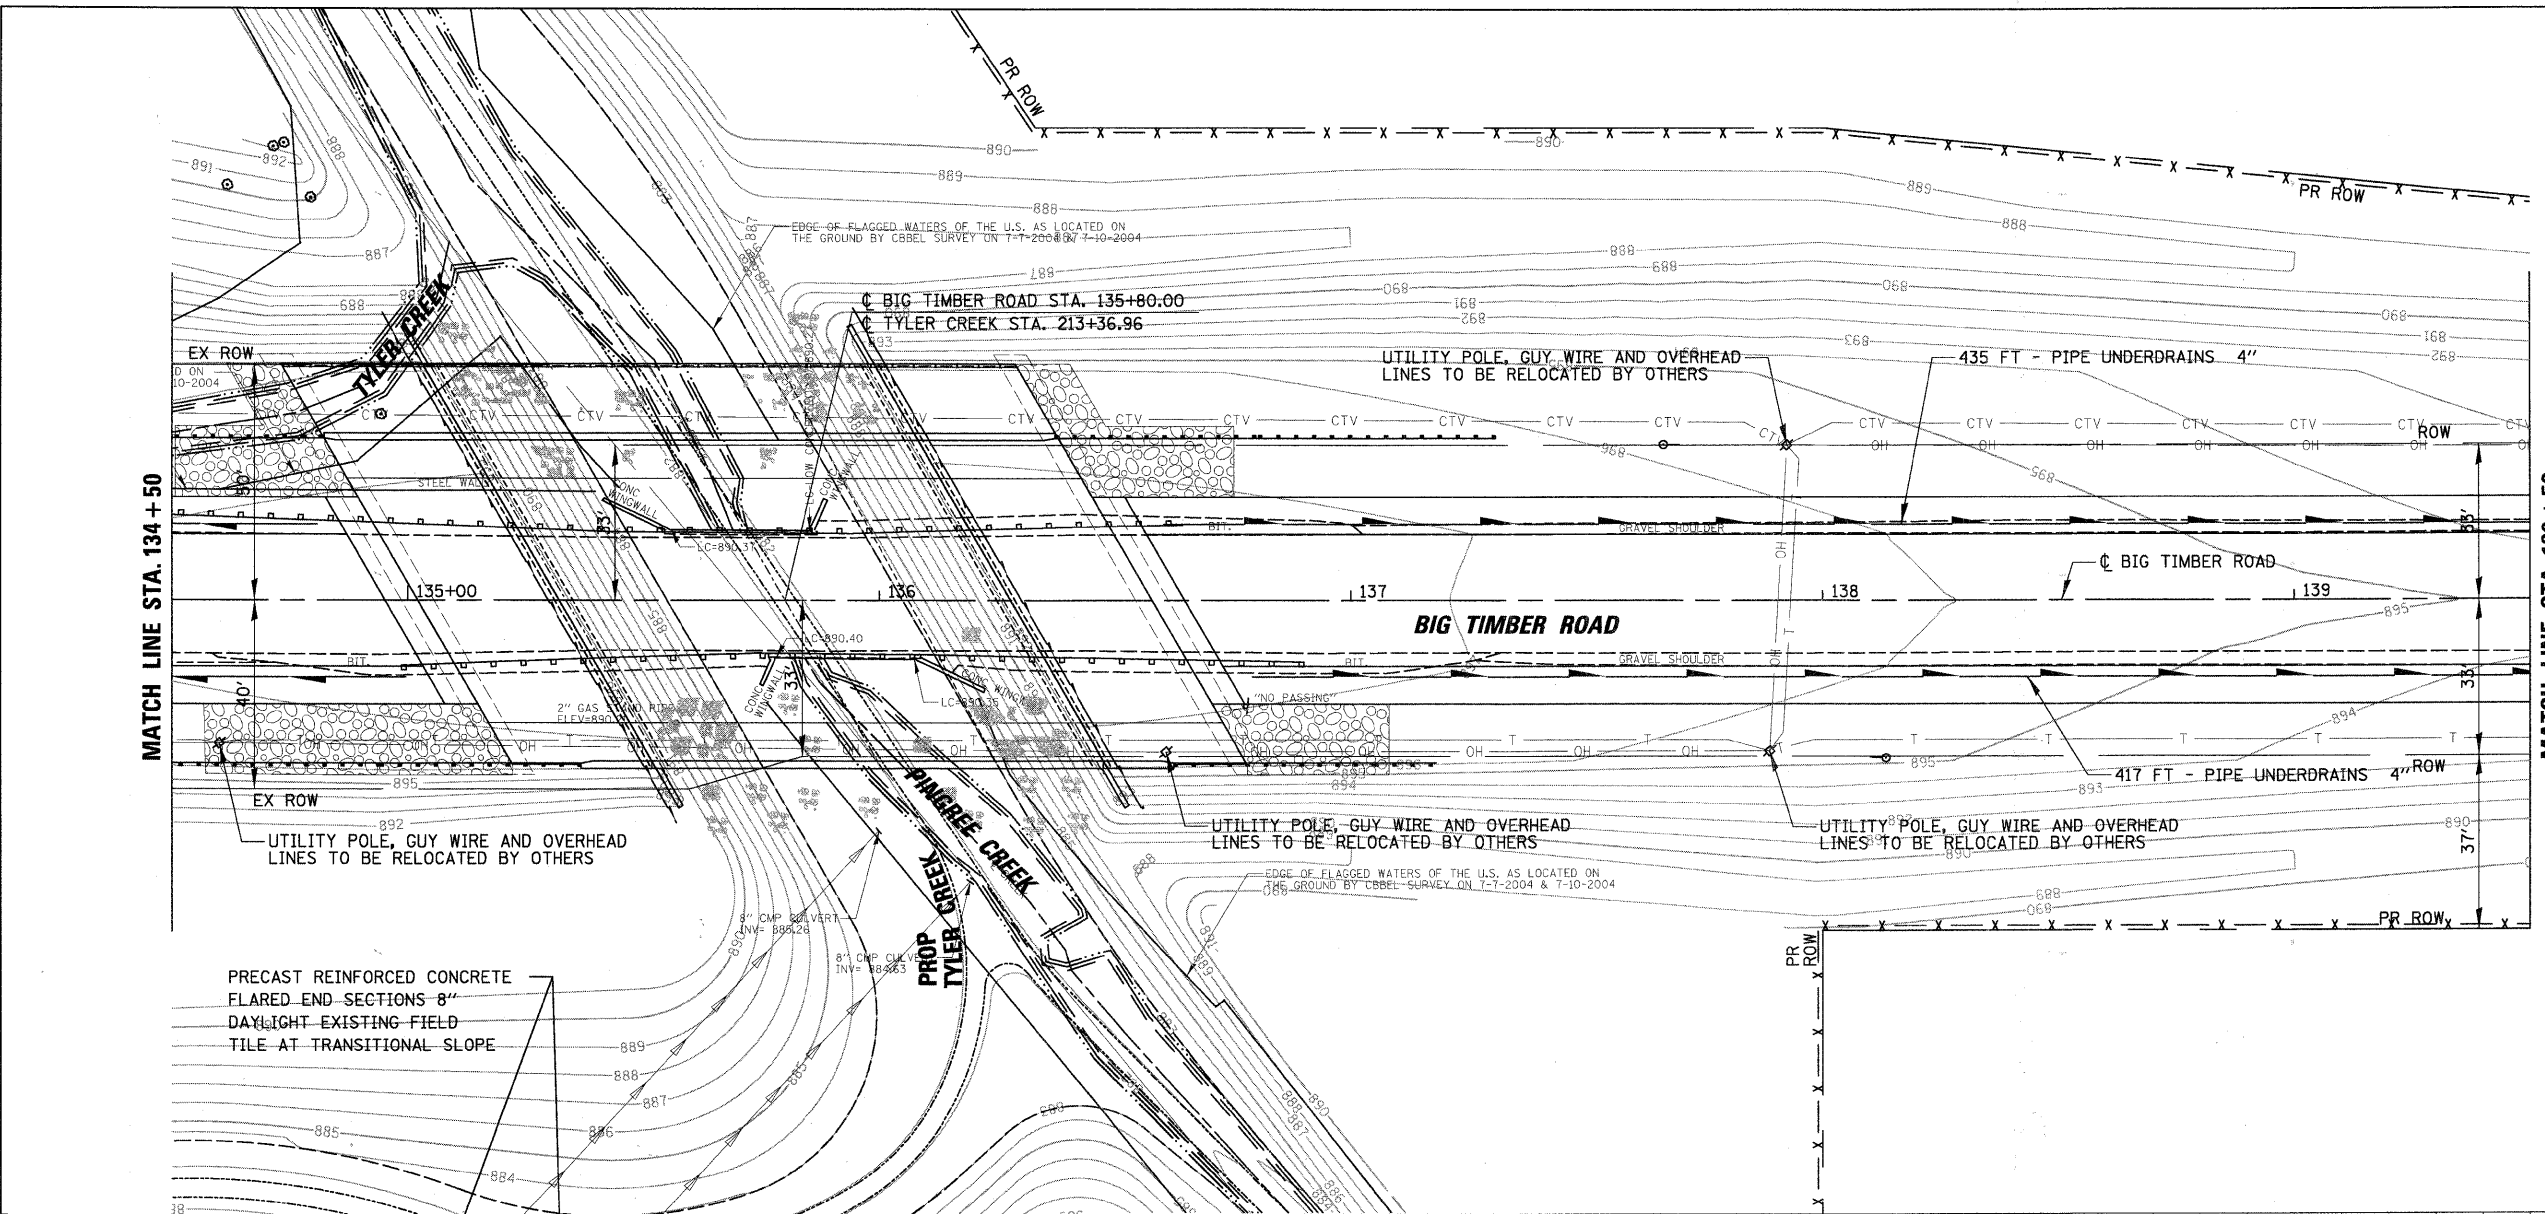


PLAN	DESIGNED	BY	DATE
	CHECKED		
	ALIGNED		
	NOTED		
	FILED		
	NO.		
	NO.		
	NO.		

PROFILE	DESIGNED	BY	DATE
	CHECKED		
	ALIGNED		
	NOTED		
	FILED		
	NO.		
	NO.		
	NO.		

CHRISTOPHER B. BURKE ENGINEERING, LTD.
 9575 W. Higgins Road, Suite 600
 Rosemont, Illinois 60018
 (847) 823-0500

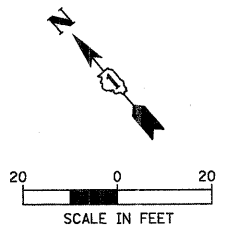

FILE NAME =	USER NAME = BLUKE	DESIGNED - RCB	REVISED -	STATE OF ILLINOIS DEPARTMENT OF TRANSPORTATION	FAS 0130 - BIG TIMBER ROAD DRAINAGE/UTILITY PLAN AND PROFILE			F.A.S. RTE. 0130	SECTION 01-00266-00-BR	COUNTY KANE	TOTAL SHEETS 70	SHEET NO. 29
N:\kane\county\04198\Cv1\1.2\DP\04198_2-03.sht		DRAWN - PMM	REVISED -		SCALE: 1"=20'	SHEET NO. OF SHEETS	STA. 134+50 TO STA. 139+50	FED. ROAD DIST. NO. 1 ILLINOIS FED. AID PROJECT BRM-8003043				
		CHECKED - JCS	REVISED -					CONTRACT NO.				
		DATE	REVISED -									