
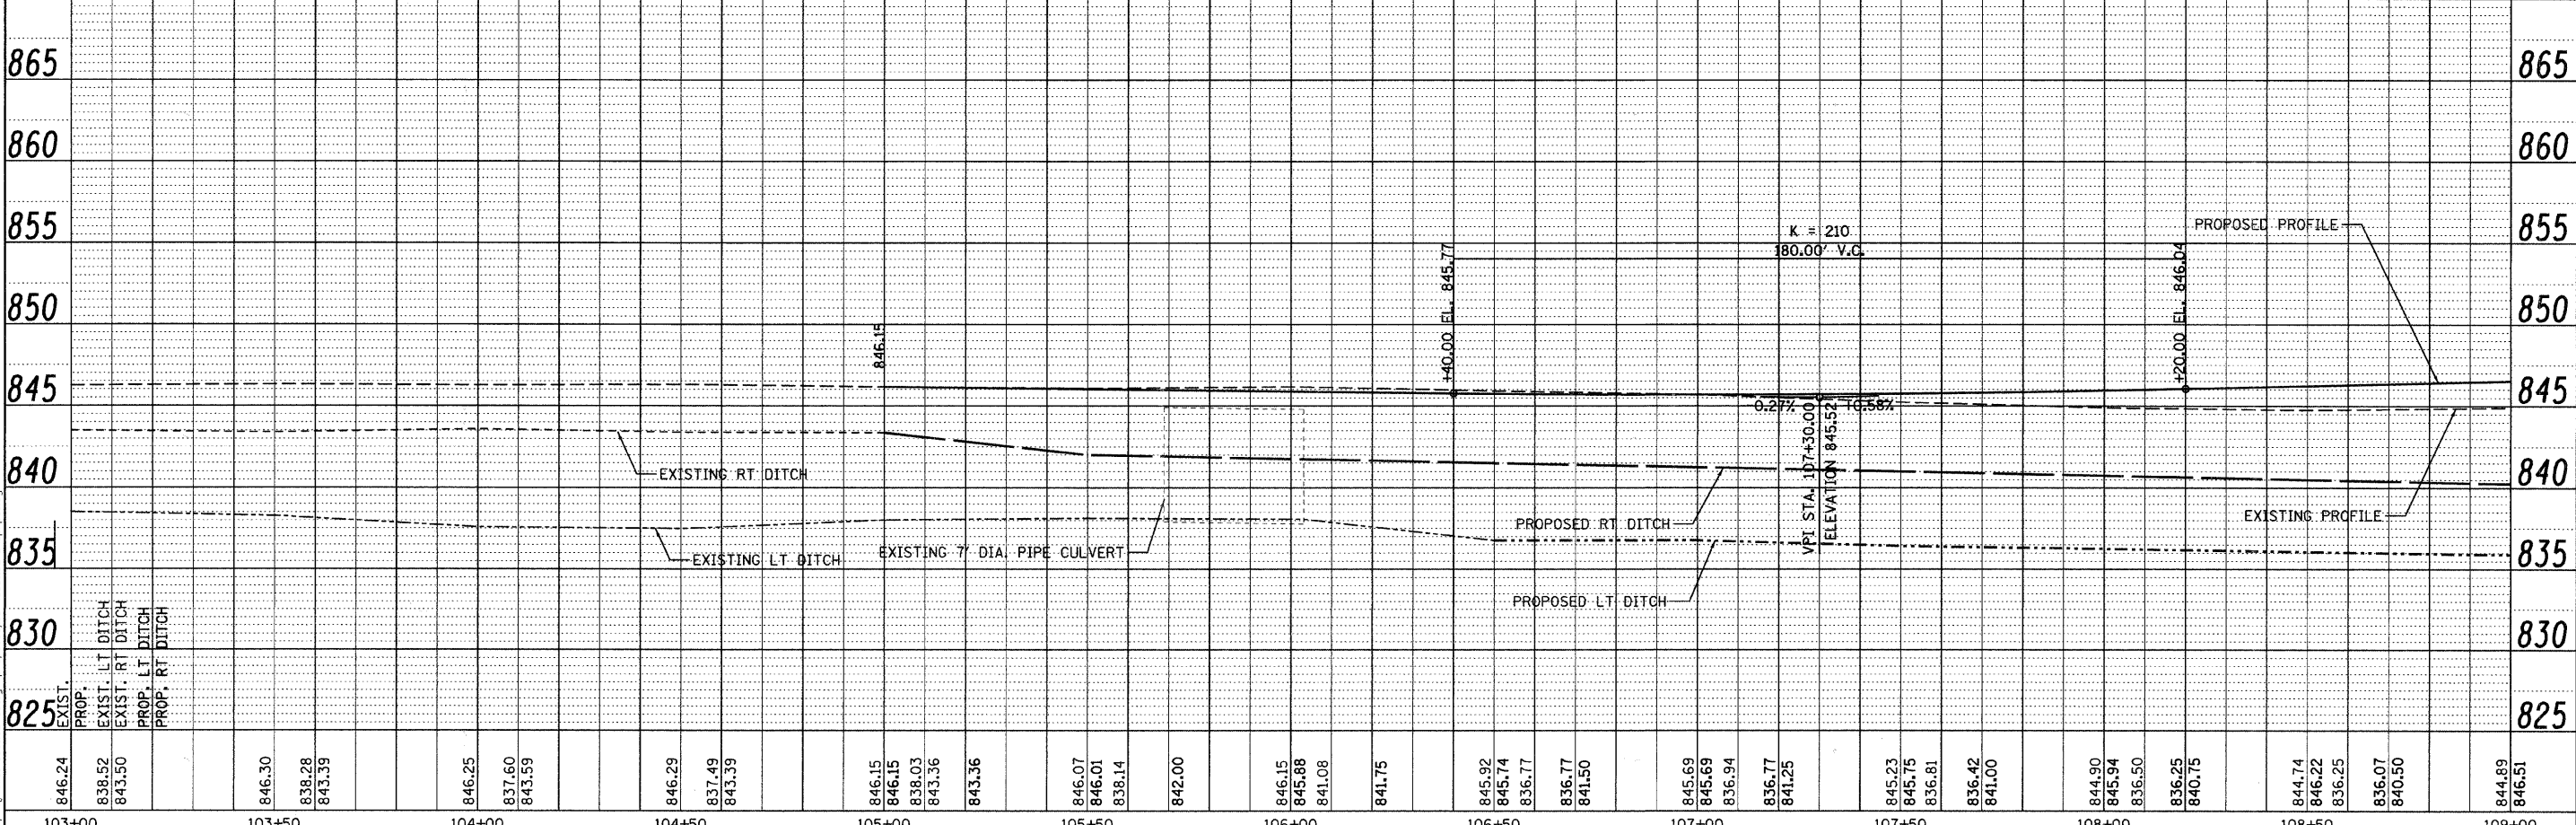
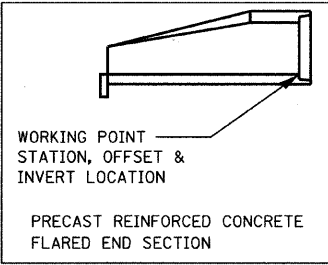


DATE	
BY	
REVISIONS	
PLANNING	
DESIGN	
CONSTRUCTION	
NO.	

DATE	
BY	
REVISIONS	
PROFILES	
GRADES	
STRUCTURE	
NO.	

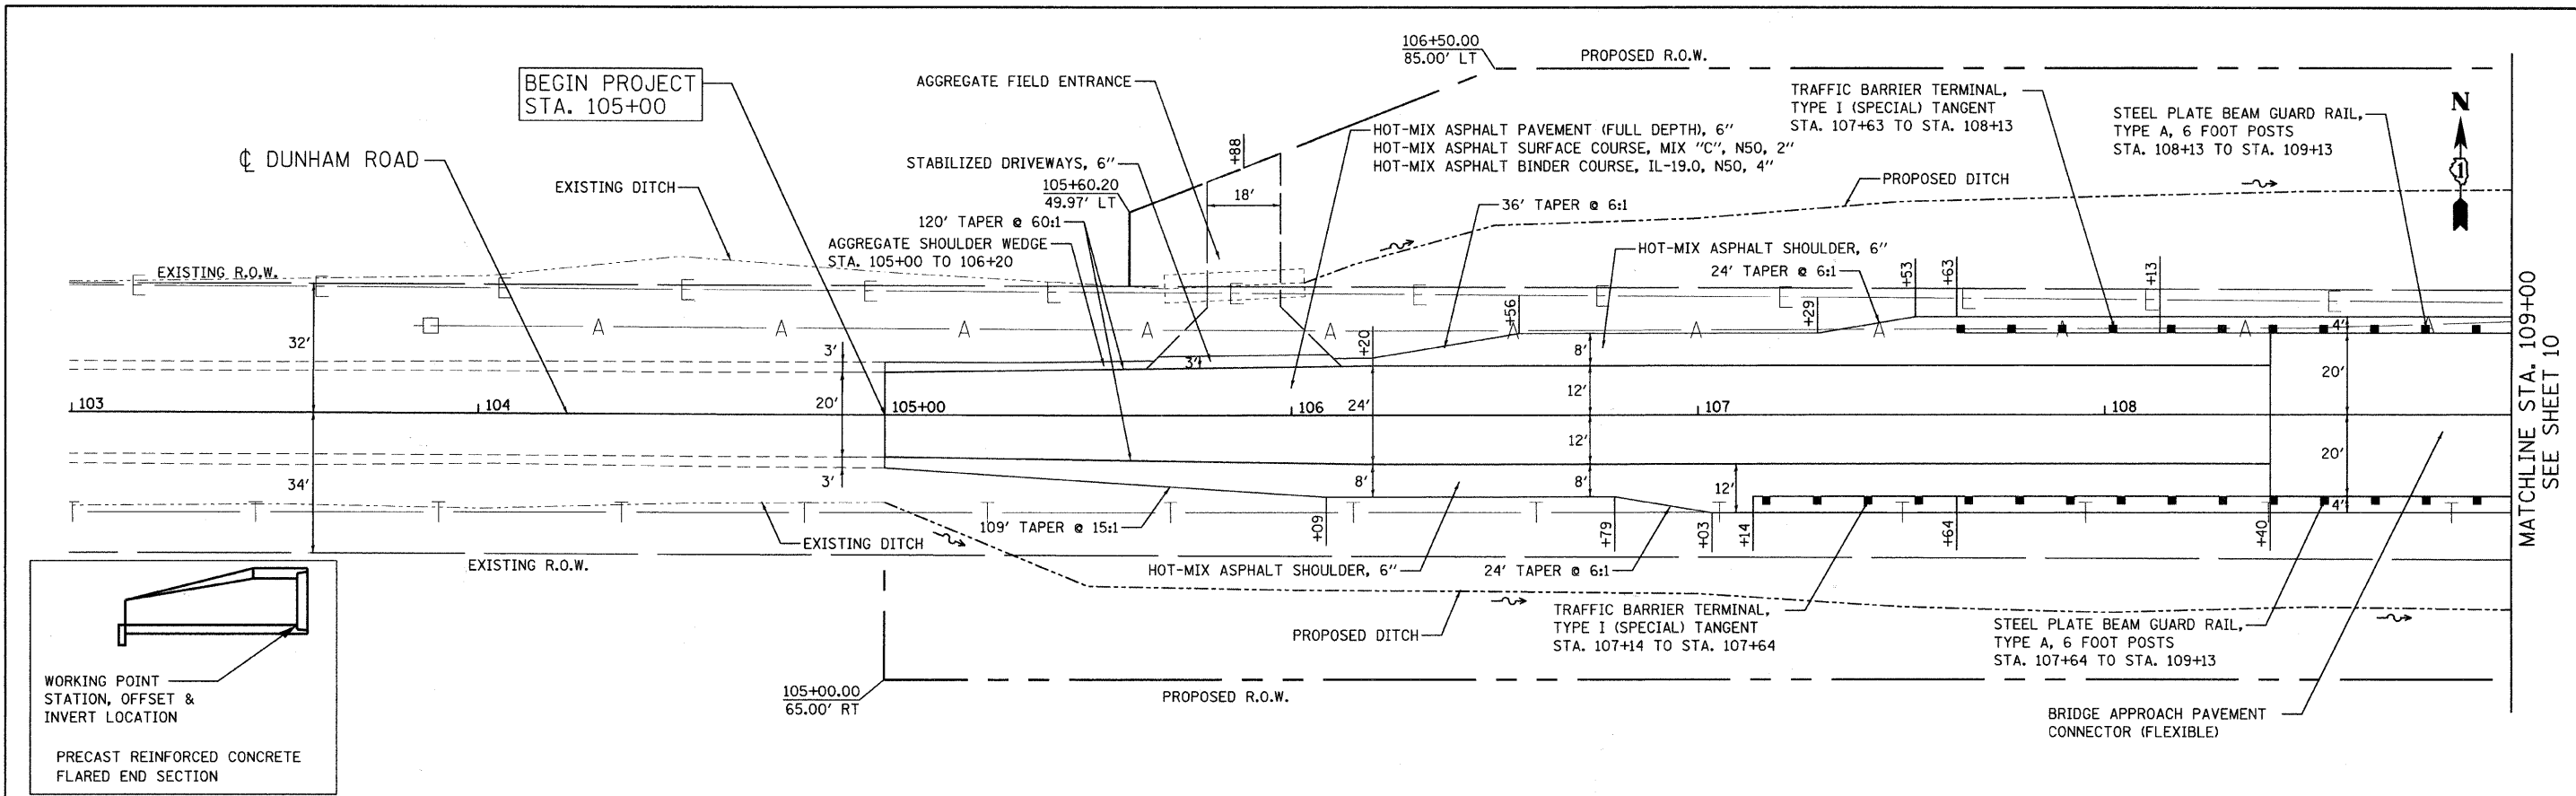

Ciorba Group, Inc.
 CONSULTING ENGINEERS
 5507 North Cumberland Avenue, Suite 402
 Chicago, Illinois 60656
 Tel. 773.775.4009 Fax 773.775.4014

USER NAME = espina	DESIGNED - DKD	REVISED -
FLDT SCALE = 20.0000' / IN.	DRAWN - DKD	REVISED -
FLDT DATE = 2/4/2011	CHECKED - CLG	REVISED -
	DATE - 02/07/2011	REVISED -

MCHENRY COUNTY DIVISION OF TRANSPORTATION

PROPOSED PLAN AND PROFILE			
SCALE: 1" = 20'	SHEET NO. OF SHEETS	STA. TO STA.	

TR. RTE.	SECTION	COUNTY	TOTAL SHEETS	SHEET NO.
	07-00340-00-BR	MCHENRY	46	9
CONTRACT NO. 63552			FED. ROAD DIST. NO. 1 ILLINOIS FED. AID PROJECT	