
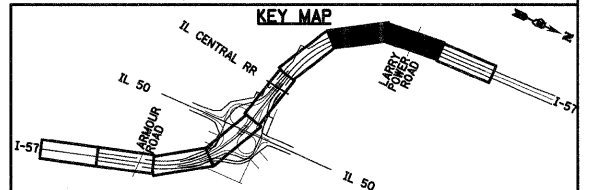


- LEGEND**
- ROADWAY PAVEMENT REMOVAL
 - SHOULDER REMOVAL
 - DRIVEWAY PAVEMENT REMOVAL
 - BITUMINOUS SURFACE REMOVAL
 - TREE REMOVAL WITH UNIT DIAMETER TRUNK

- REMOVAL NOTES**
1. SEE ELECTRICAL PLANS FOR LIGHTING REMOVALS.
 2. SEE DRAINAGE PLANS FOR DRAINAGE REMOVALS.
 3. SEE SIGNING PLANS FOR SIGNING REMOVALS.

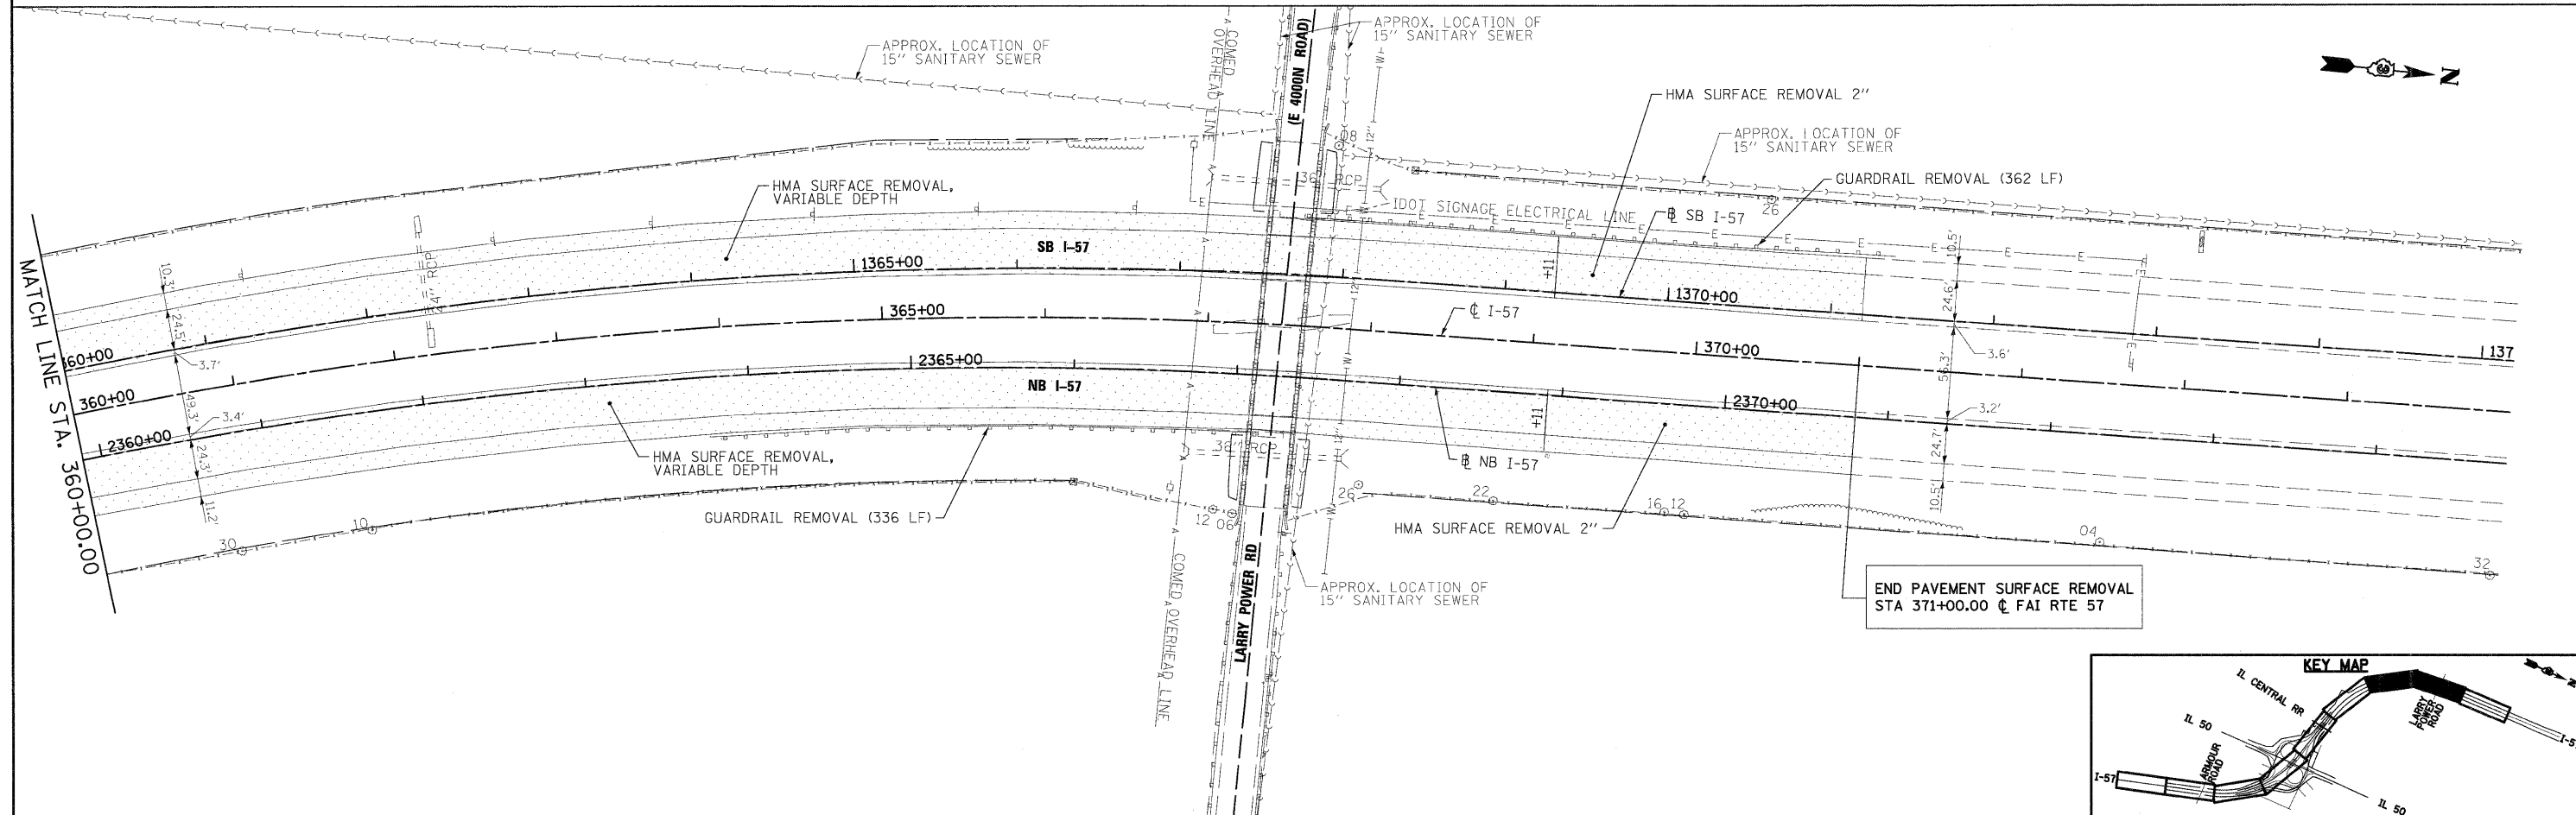

FILE NAME = I:\Dgn\sheets\xp04.dgn	USER NAME = E-106	DESIGNED - JTF	REVISED -	STATE OF ILLINOIS DEPARTMENT OF TRANSPORTATION	EXISTING PLAN AND REMOVALS I-57			F.A.I. RTE. = 57	SECTION = (46-2) I, HBR, VBR	COUNTY = KANKAKEE	TOTAL SHEETS = 558	SHEET NO. = 46
	PLOT SCALE = 1:50	CHECKED - EJG	REVISED -					FED. ROAD DIST. NO. 3	ILLINOIS FED. AID PROJECT	CONTRACT NO. 66409		
	PLOT DATE = 12/22/2010	DATE = 12/17/10	REVISED -					SCALE:	SHEET NO. OF SHEETS	STA. TO STA.		