



PLAN
 DESIGNED
 PLOTTED
 ALIGNMENT CHECKED
 GRADES CHECKED
 NOTE BOOK NO.
 DATE
 BY

PROFILE
 DESIGNED
 PLOTTED
 GRADES CHECKED
 NOTE BOOK NO.
 DATE
 BY

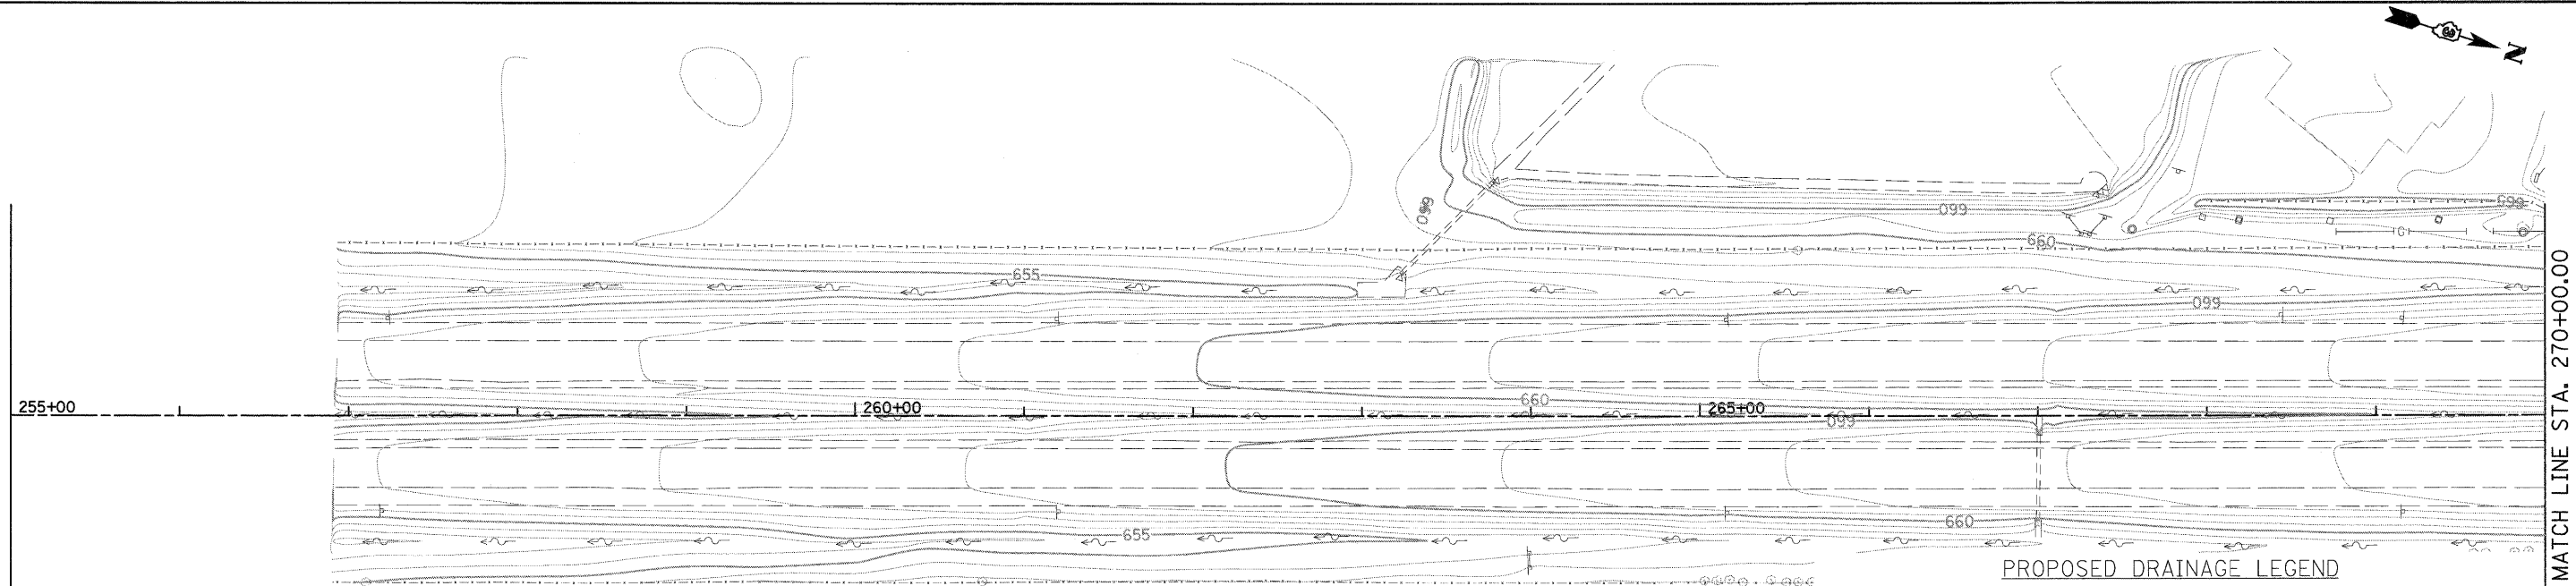

PROPOSED DRAINAGE LEGEND

- DITCH FLOW
- SUMMIT
- SWALE
- CULVERT
- CATCH BASIN
- MANHOLE
- DRAINAGE STRUCTURE
- LIMITS OF CONSTRUCTION
- INLET
- FLARED END SECTION
- HEADWALL
- STORM SEWER
- CULVERT ID
- STORM SEWER ID
- DRAINAGE STRUCTURE ID
- PIPE UNDERDRAIN

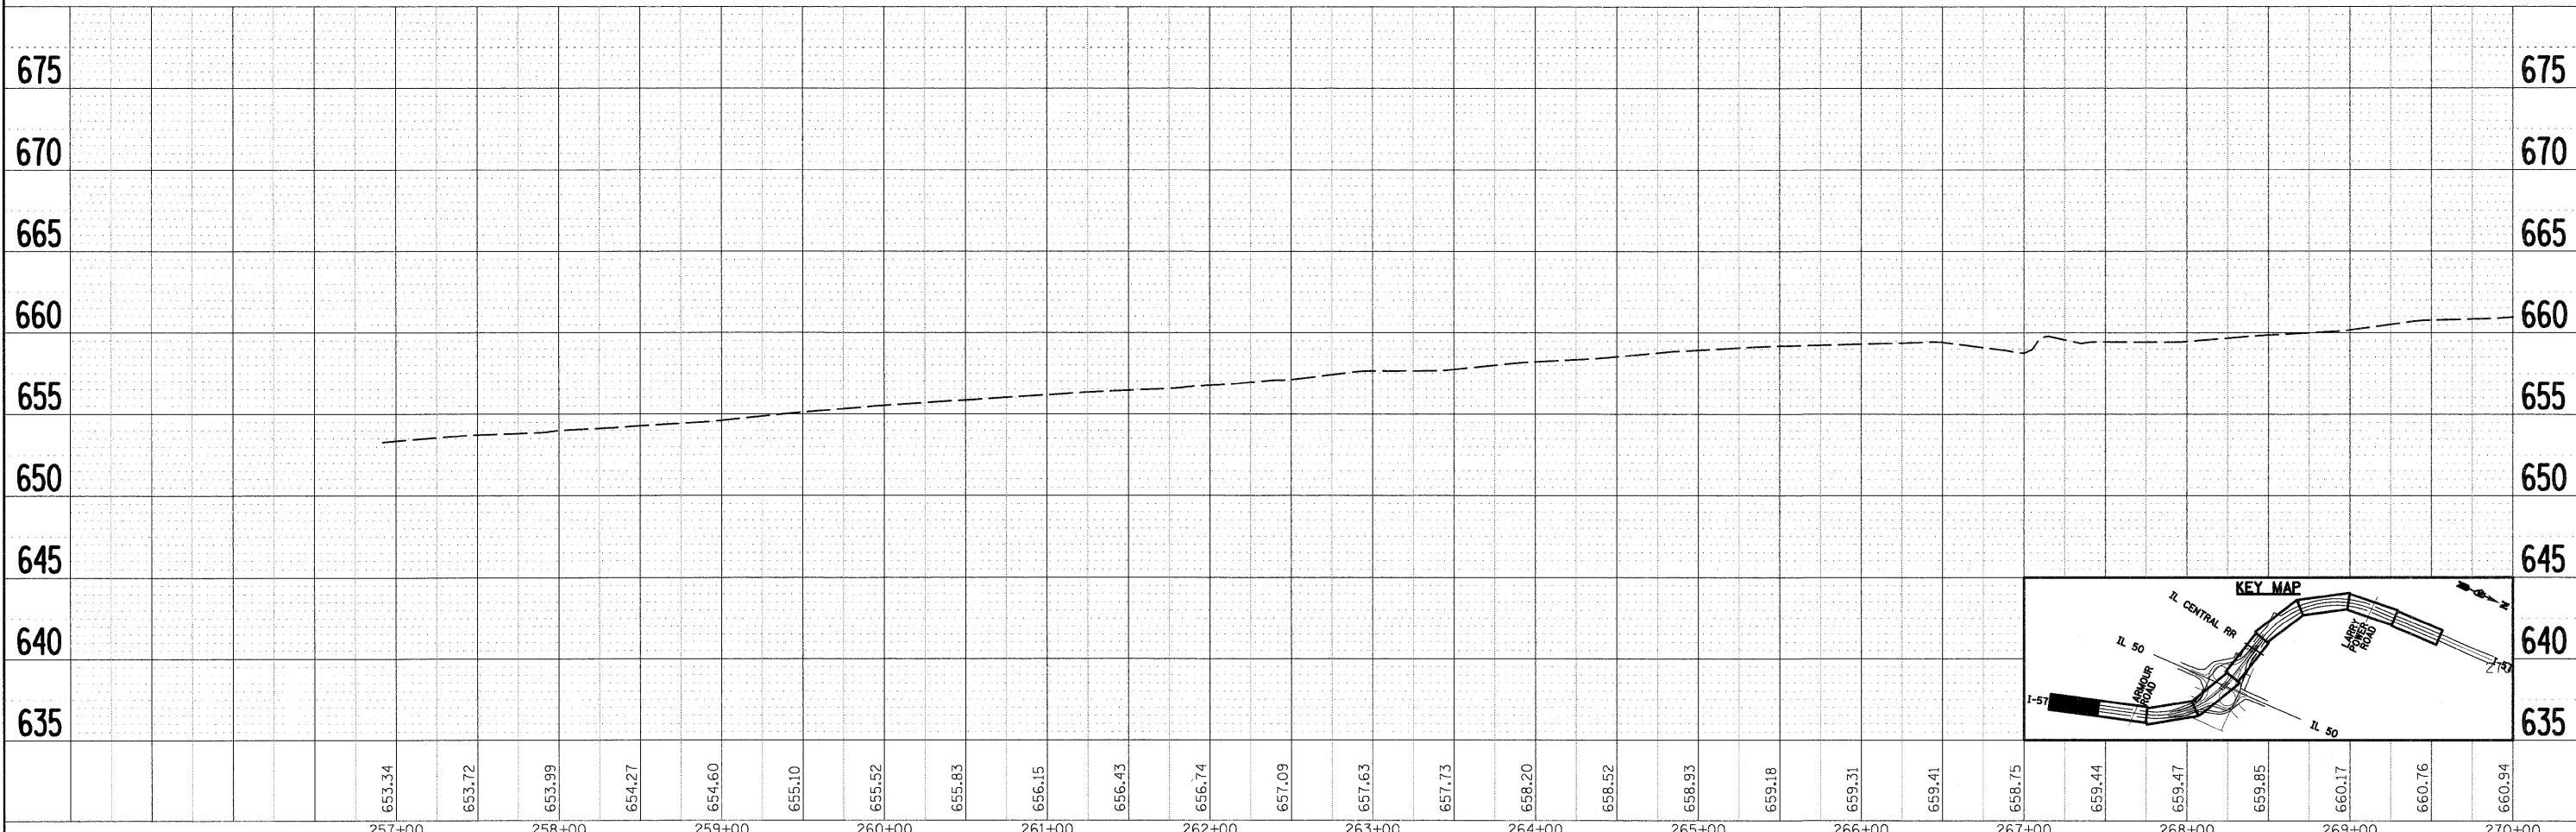

FILE NAME = I:\Dgn\sheets\d118.dgn	USER NAME = EricG	DESIGNED - JWM	REVISED -	STATE OF ILLINOIS DEPARTMENT OF TRANSPORTATION	I-57 PROPOSED DRAINAGE PLAN AND PROFILE	F.A.I. RTE. 57	SECTION (46-2) I, HBR, VBR	COUNTY KANKAKEE	TOTAL SHEETS 558	SHEET NO. 142		
PLOT SCALE = 1:50	CHECKED - EJG	REVISED -	SCALE:			SHEET NO. OF SHEETS STA. TO STA.	CONTRACT NO. 66409					
PLOT DATE = 12/22/2010	DATE - 12/17/10	REVISED -	FED. ROAD DIST. NO. 3 ILLINOIS FED. AID PROJECT									