

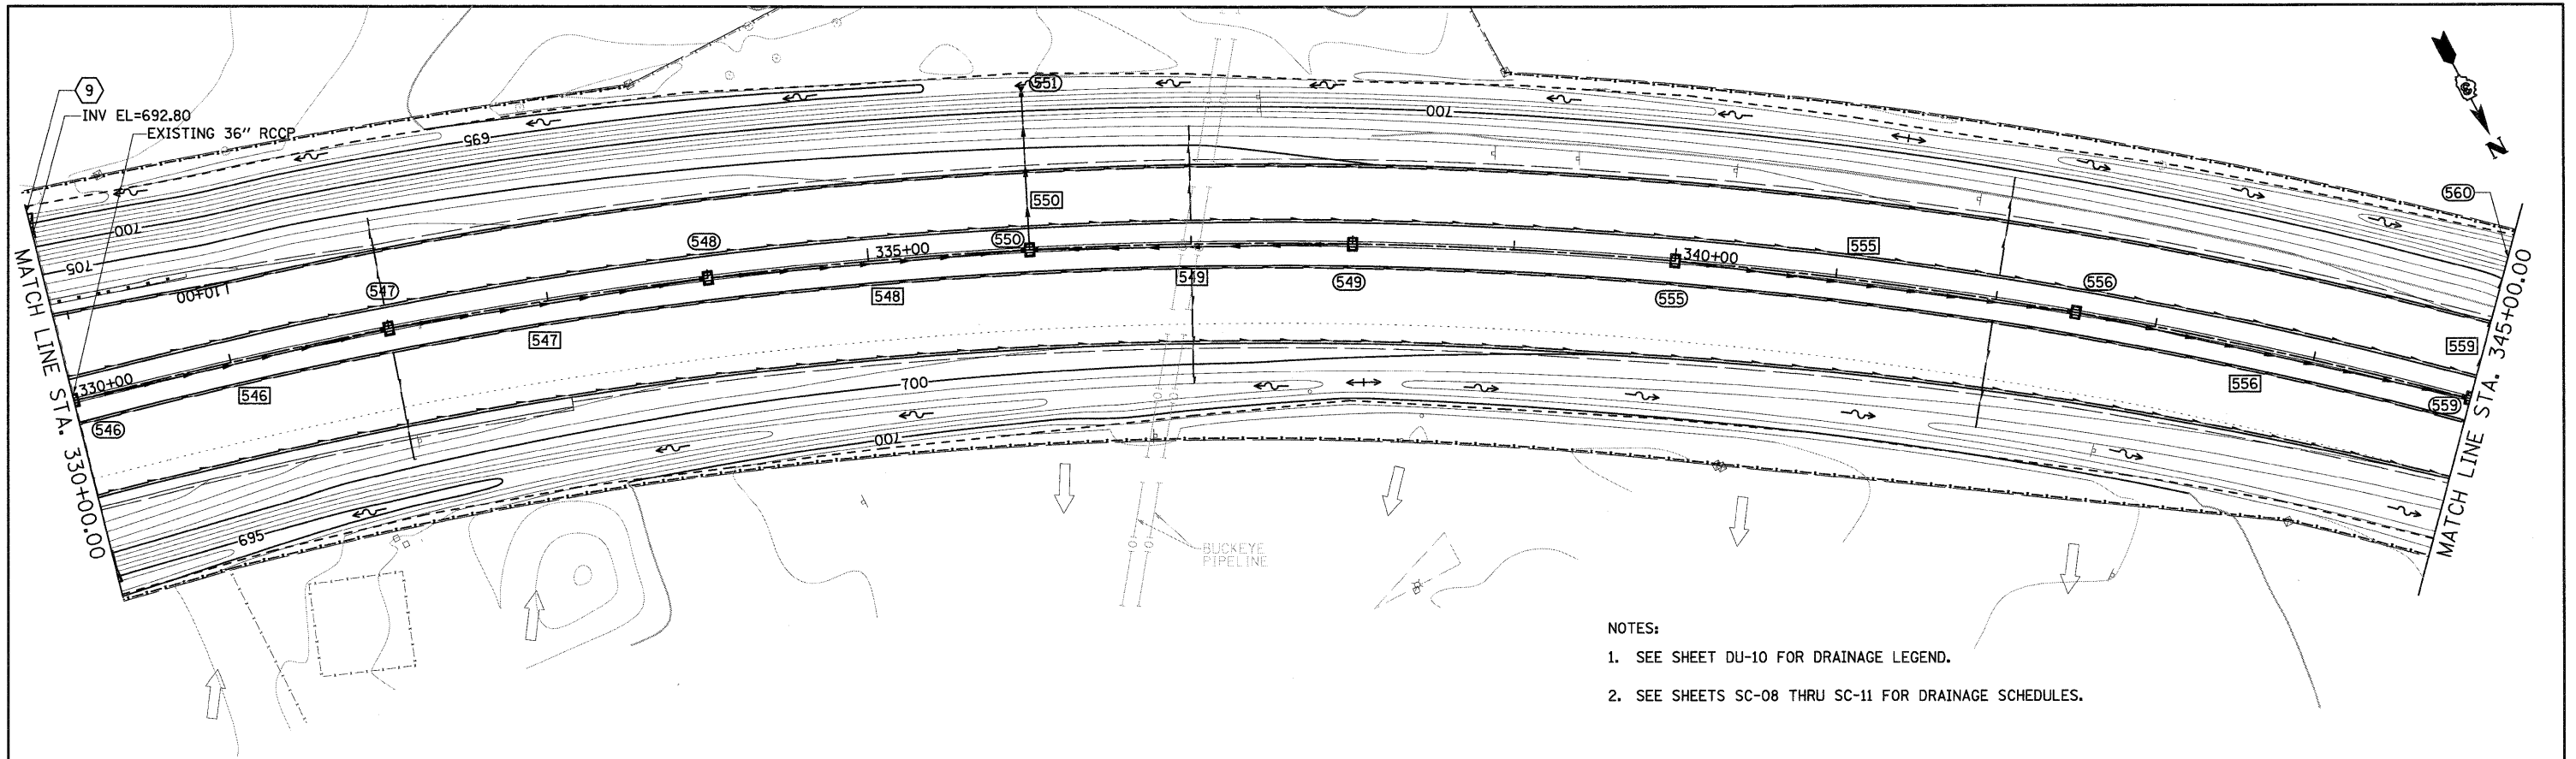


PLAN	DESIGNED	DATE
	PLOTTED	
	GRADES CHECKED	
	ALIGNMENT CHECKED	
	NOTE BOOK NO.	
	BY	
	FILE NAME	

PROFILE	DESIGNED	DATE
	PLOTTED	
	GRADES CHECKED	
	ALIGNMENT CHECKED	
	NOTE BOOK NO.	
	BY	
	FILE NAME	

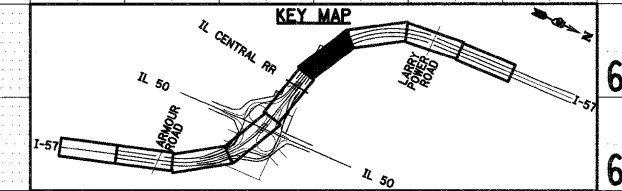

- NOTES:
- SEE SHEET DU-10 FOR DRAINAGE LEGEND.
 - SEE SHEETS SC-08 THRU SC-11 FOR DRAINAGE SCHEDULES.

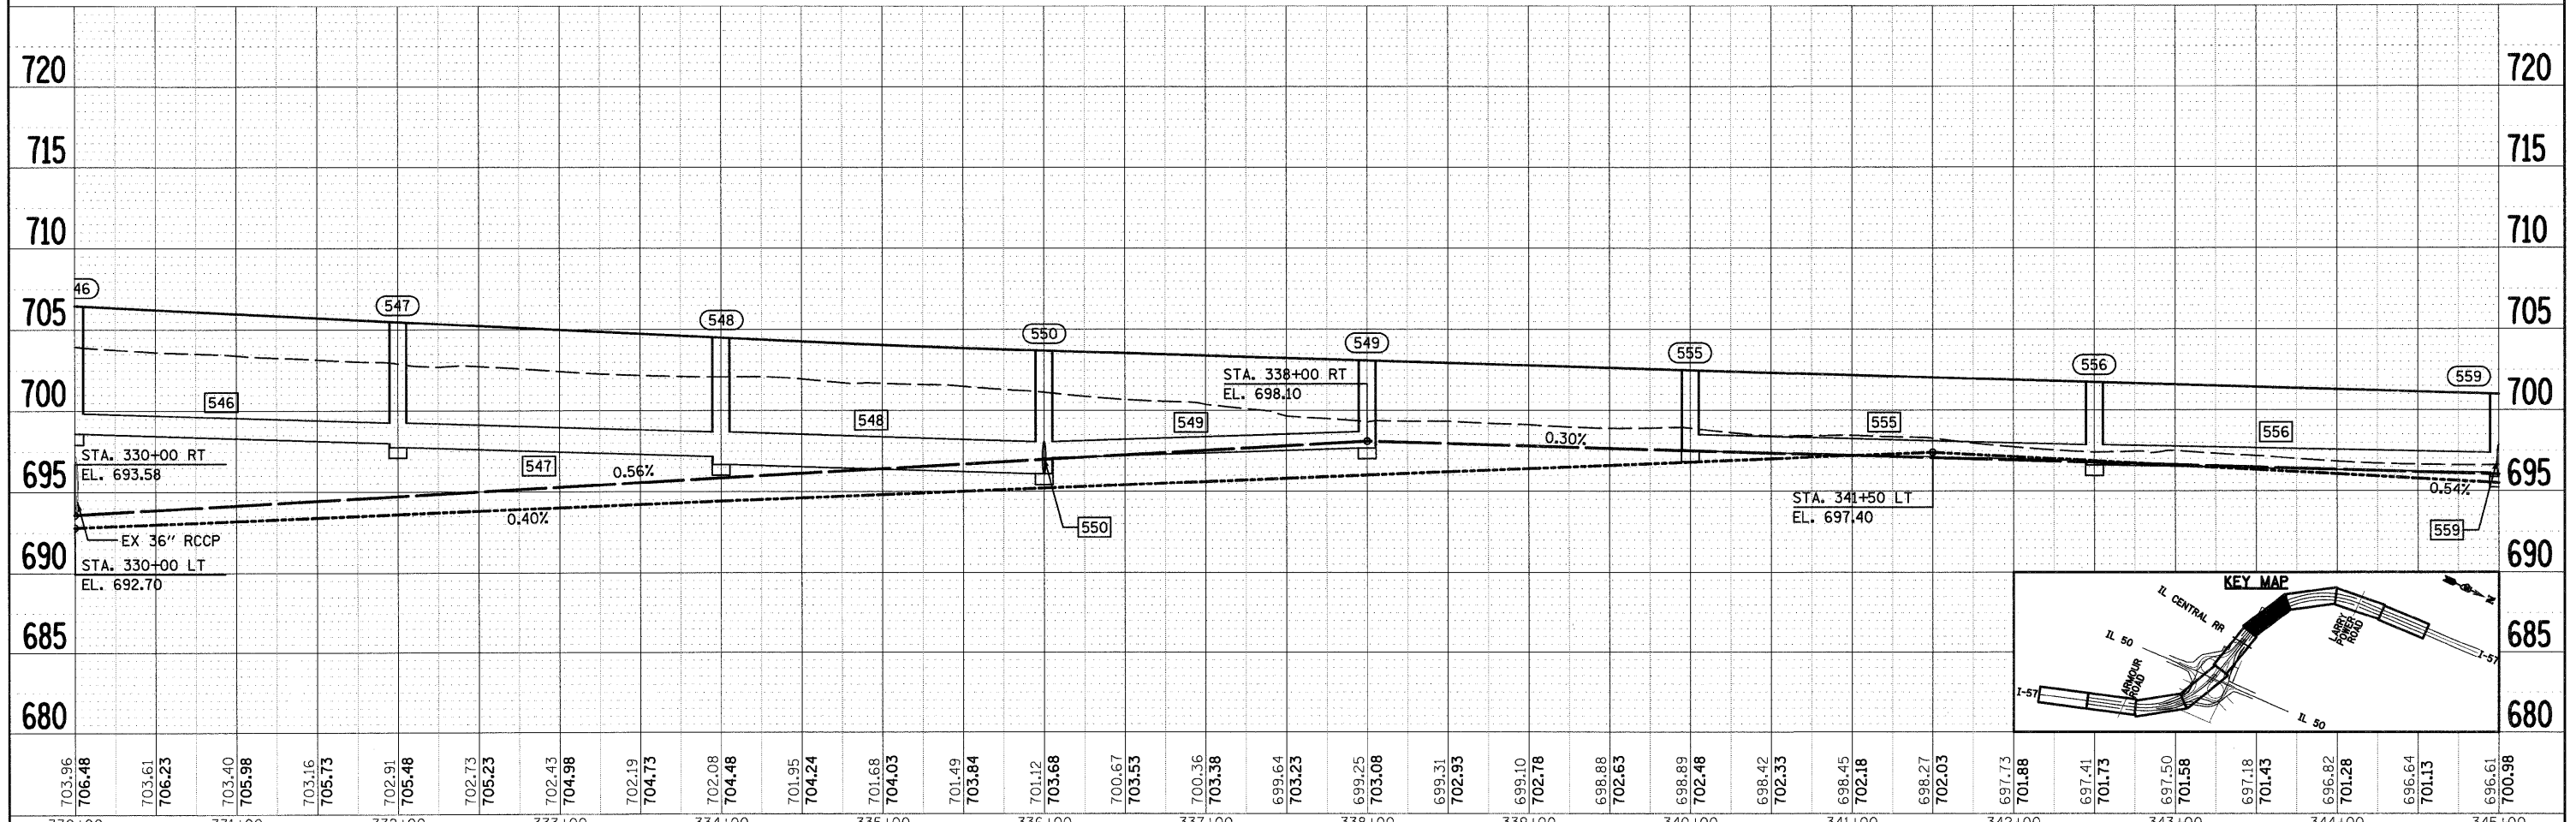

703.96 706.48	703.61 706.23	703.40 705.98	703.16 705.73	702.91 705.48	702.73 705.23	702.43 704.98	702.19 704.73	702.08 704.48	701.95 704.24	701.68 704.03	701.49 703.84	701.12 703.68	700.67 703.53	700.36 703.38	699.64 703.23	699.25 703.08	699.31 702.93	699.10 702.78	698.88 702.63	698.89 702.48	698.42 702.33	698.45 702.18	698.27 702.03	697.73 701.88	697.41 701.73	697.50 701.58	697.18 701.43	696.82 701.28	696.64 701.13	696.61 700.98
330+00	331+00	332+00	333+00	334+00	335+00	336+00	337+00	338+00	339+00	340+00	341+00	342+00	343+00	344+00	345+00															

FILE NAME = I:\0gn\shoeta\dul5.dgn

USER NAME = E-rig
PLOT SCALE = 1:50
PLOT DATE = 12/22/2010

DESIGNED - JWM
DRAWN - JWM
CHECKED - EJG
DATE - 12/17/10

REVISED -
REVISED -
REVISED -
REVISED -

STATE OF ILLINOIS
DEPARTMENT OF TRANSPORTATION

I-57 PROPOSED DRAINAGE PLAN AND PROFILE

SCALE: SHEET NO. OF SHEETS STA. TO STA.

F.A.I. RTE.	SECTION	COUNTY	TOTAL SHEETS	SHEET NO.
57	(46-2) I, HBR, VBR	KANKAKEE	558	147
CONTRACT NO. 66409				
FED. ROAD DIST. NO. 3 ILLINOIS FED. AID PROJECT				