


GENERAL NOTES:

- FOR ELECTRICAL GENERAL NOTES, SYMBOLS LEGEND AND ABBREVIATIONS REFER TO SHEET LI-1.
- PROVIDE TEMPORARY LIGHTING UNIT NEAR EXIT/ENTRANCE OF RAMPS AND CROSSOVERS FOR CONSTRUCTION PHASES.
- MAINTAIN EXISTING LIGHTING UNITS DURING CONSTRUCTION PHASES. EXISTING LIGHTING UNITS TO BE REMOVED AFTER THE PROPOSED LIGHTING SYSTEM IS INSTALLED AND OPERATIONAL. EXISTING LIGHTING UNITS SHALL BE USED AS TEMPORARY LIGHTING UNITS FOR CONSTRUCTION PHASE.
- CONNECT TEMPORARY LIGHTING UNITS TO EXISTING LIGHTING SYSTEM LIGHTING CONTROLLER. ALL TEMPORARY LIGHTING FEEDS SHALL BE OVERHEAD WITH AERIAL CABLES. USE UNDERGROUND FEED FOR EXISTING POLES.
- ALL SALVAGE MATERIALS SHALL BE DELIVERED TO IDOT DISTRICT 3 STORAGE FACILITIES.
- AFTER PROPOSED LIGHTING IS INSTALLED AND START FUNCTIONING, REMOVE TEMPORARY 60 FOOT CLASS 4 WOOD POLE, THE COST OF ITS REMOVAL SHALL BE INCLUDED IN THE PAY ITEM "REMOVAL OF TEMPORARY LIGHTING UNIT." (TYP.)
- GUY WIRE AND ANCHORS SHALL CONFORM TO IDOT SECTION 1069.04. (TYP.)
- MAINTAIN EXISTING UNDERGROUND FEED.


- TEMPORARY LIGHTING LUMINAIRE SHALL BE PAID UNDER PAY ITEM: 82102400-LUMINAIRE SODIUM VAPOR, HORIZONTAL MOUNT 400 WATT. (TYP.)

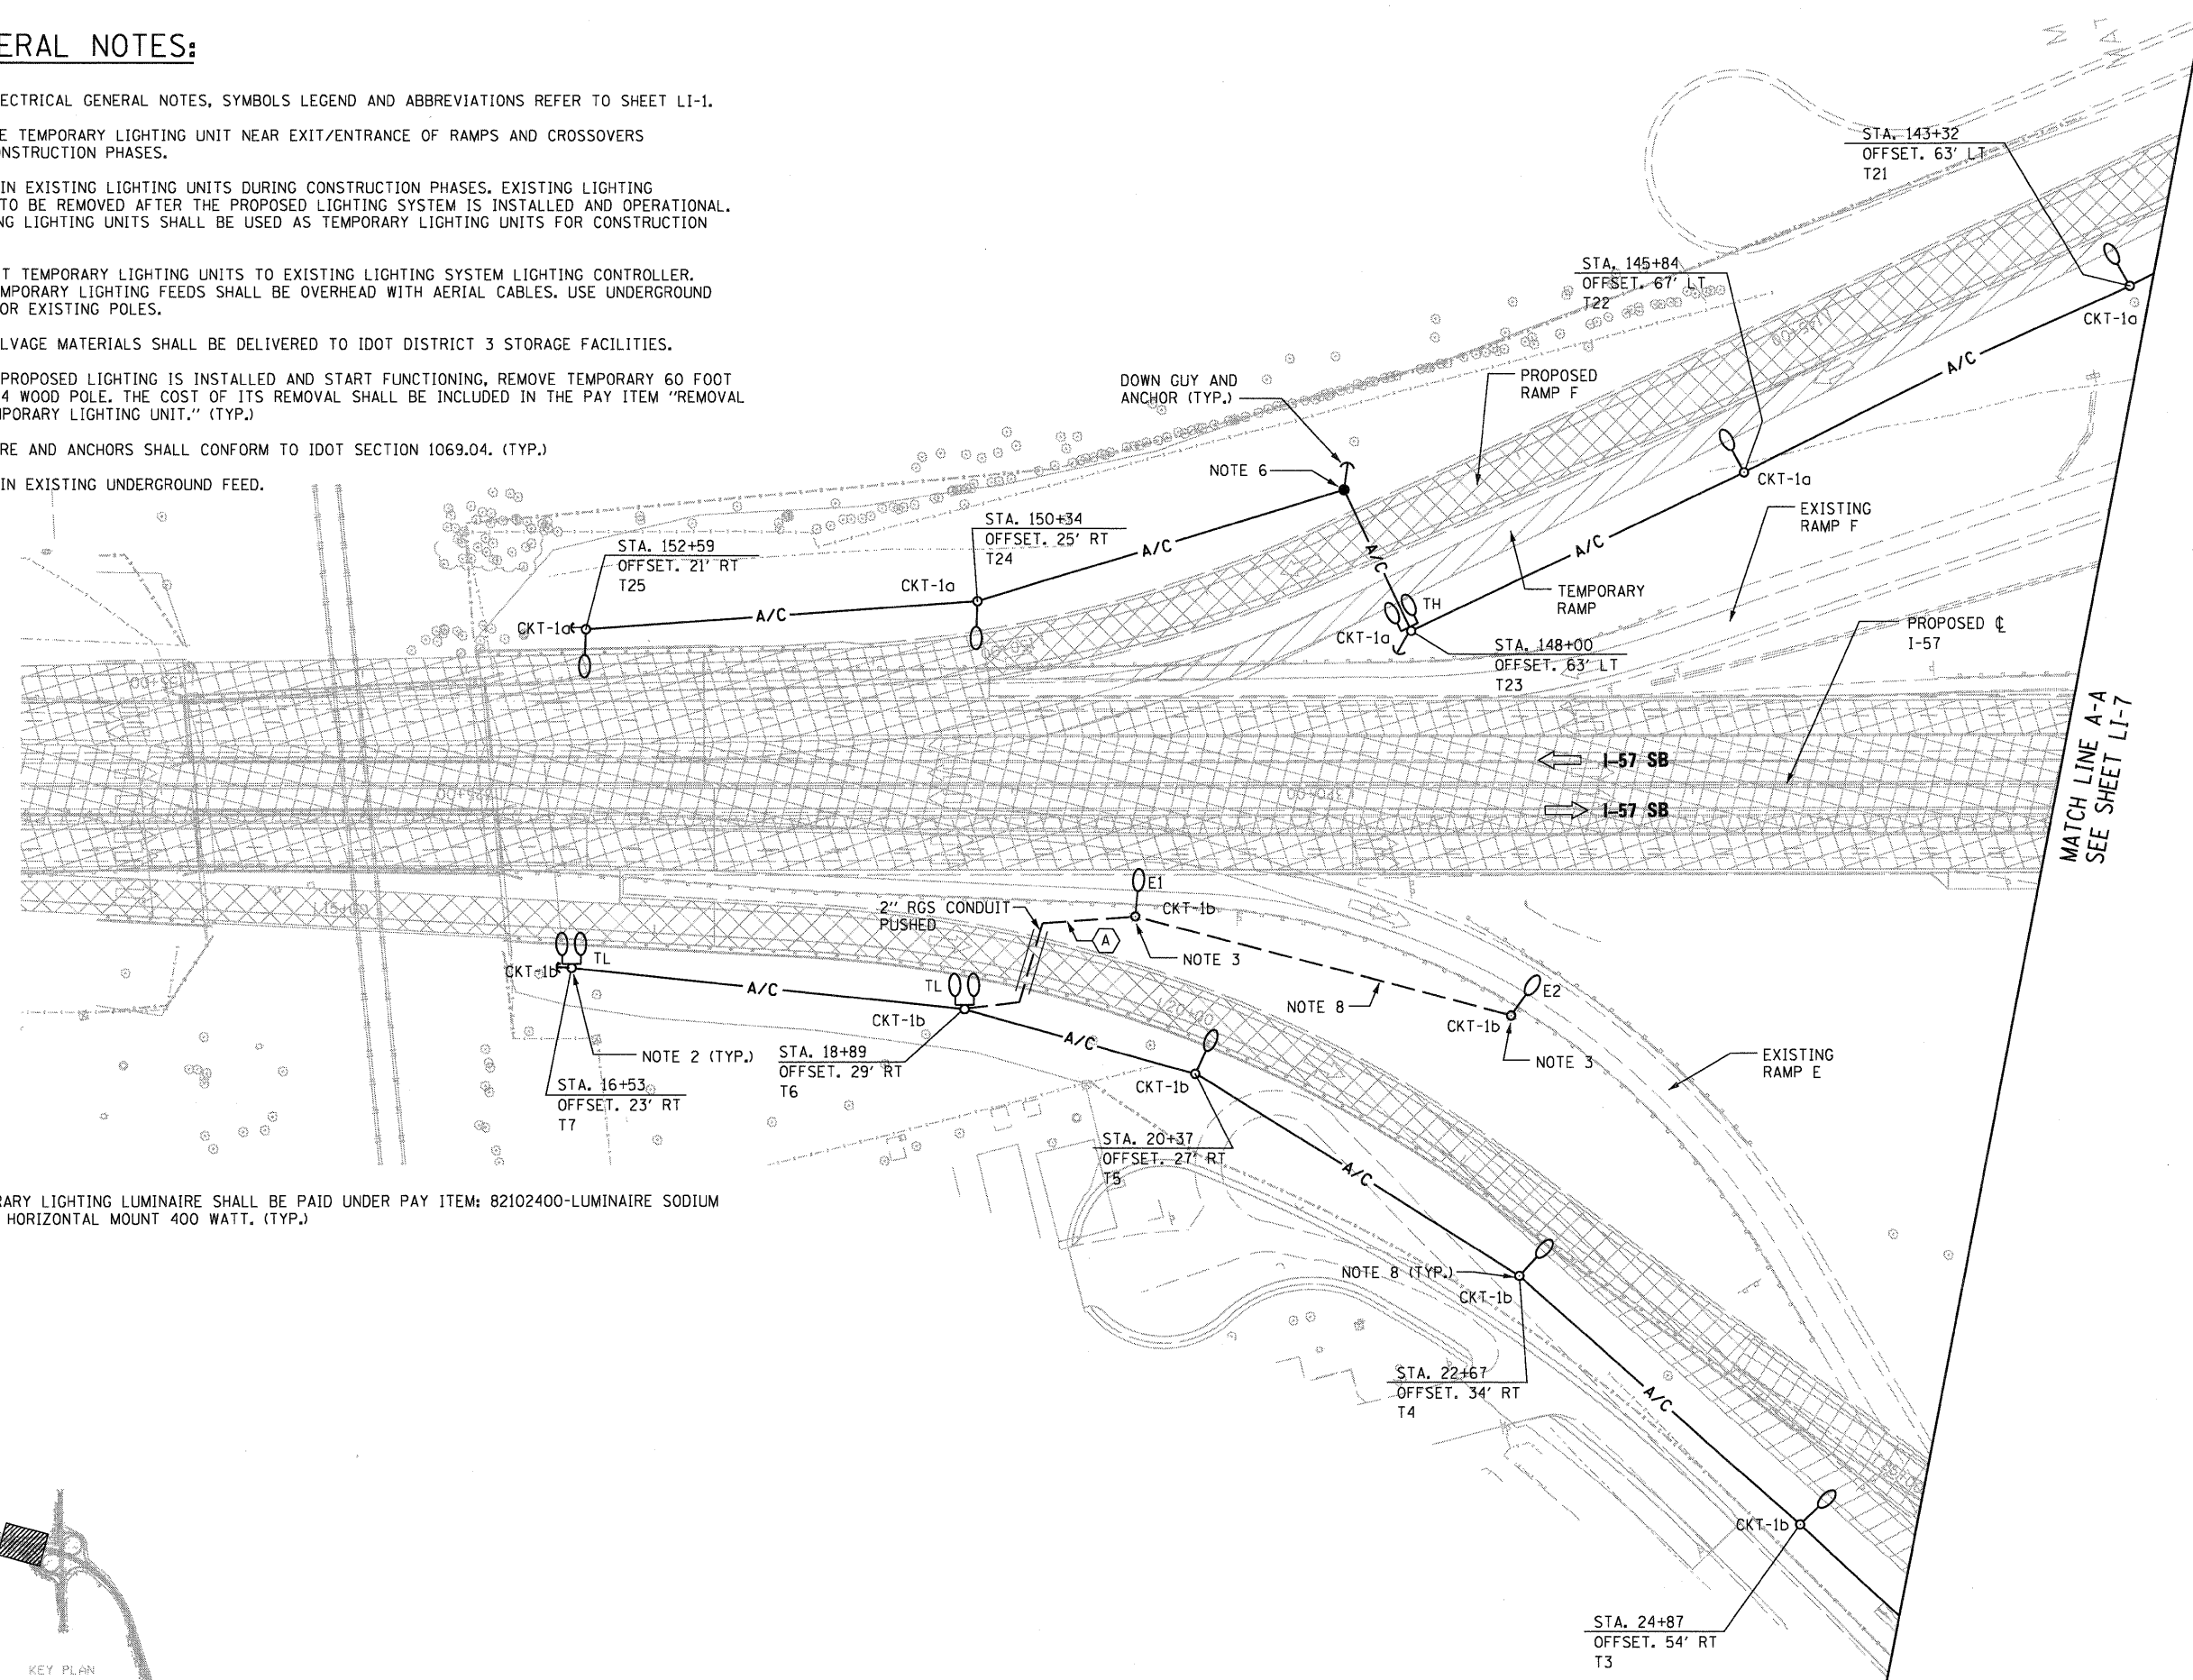

MATCH LINE A-A
SEE SHEET LI-7



Delta Engineering, Inc.
CONSULTING ENGINEERS, CONSTRUCTION MANAGERS, SURVEYORS
111 West Jackson Blvd, Suite 910 Chicago, IL 60604-2001

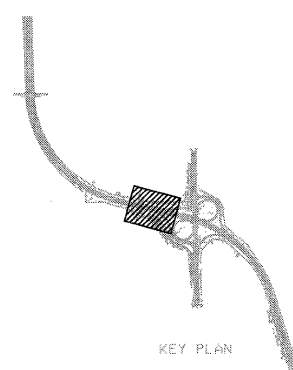

| | | | | | | | | | | | | |
|------------------------------------|----------------------|----------------------|----------------------|---|--|---------------------|--------------|----------------------|-------------------------------|--------------------|------------------------|---------------------|
| FILE NAME = g:\zd40403\LI-6.DGN | USER NAME = kkhan | DESIGNED - HS | REVISED - | STATE OF ILLINOIS DEPARTMENT OF TRANSPORTATION | TEMPORARY LIGHTING PLAN I-57, RAMP "E" AND RAMP "F" | | | F.A.I. RTE. 57 | SECTION (46-2) I, HBR, VBR | COUNTY KANKAKEE | TOTAL SHEETS 558 | SHEET NO. 253 |
| PLOT SCALE = 1:500 | CHECKED - HS | REVISOR - | DATE - 12-17-2010 | | SCALE: | SHEET NO. OF SHEETS | STA. TO STA. | CONTRACT NO. 66409 | | | | |
| PLOT DATE = 12/17/2010 | DATE - 12-17-2010 | DATE - 12-17-2010 | DATE - | | FED. ROAD DIST. NO. 3 ILLINOIS FED. AID PROJECT | | | | | | | |
| Rev. | | | | | | | | | | | | |