


MAR 11, 2011 10:37 AM RINKED0461 C:\P\W\WORK\DO\_NOT\_DELETE\DM\8063\RP-131DRN.L1.DWG

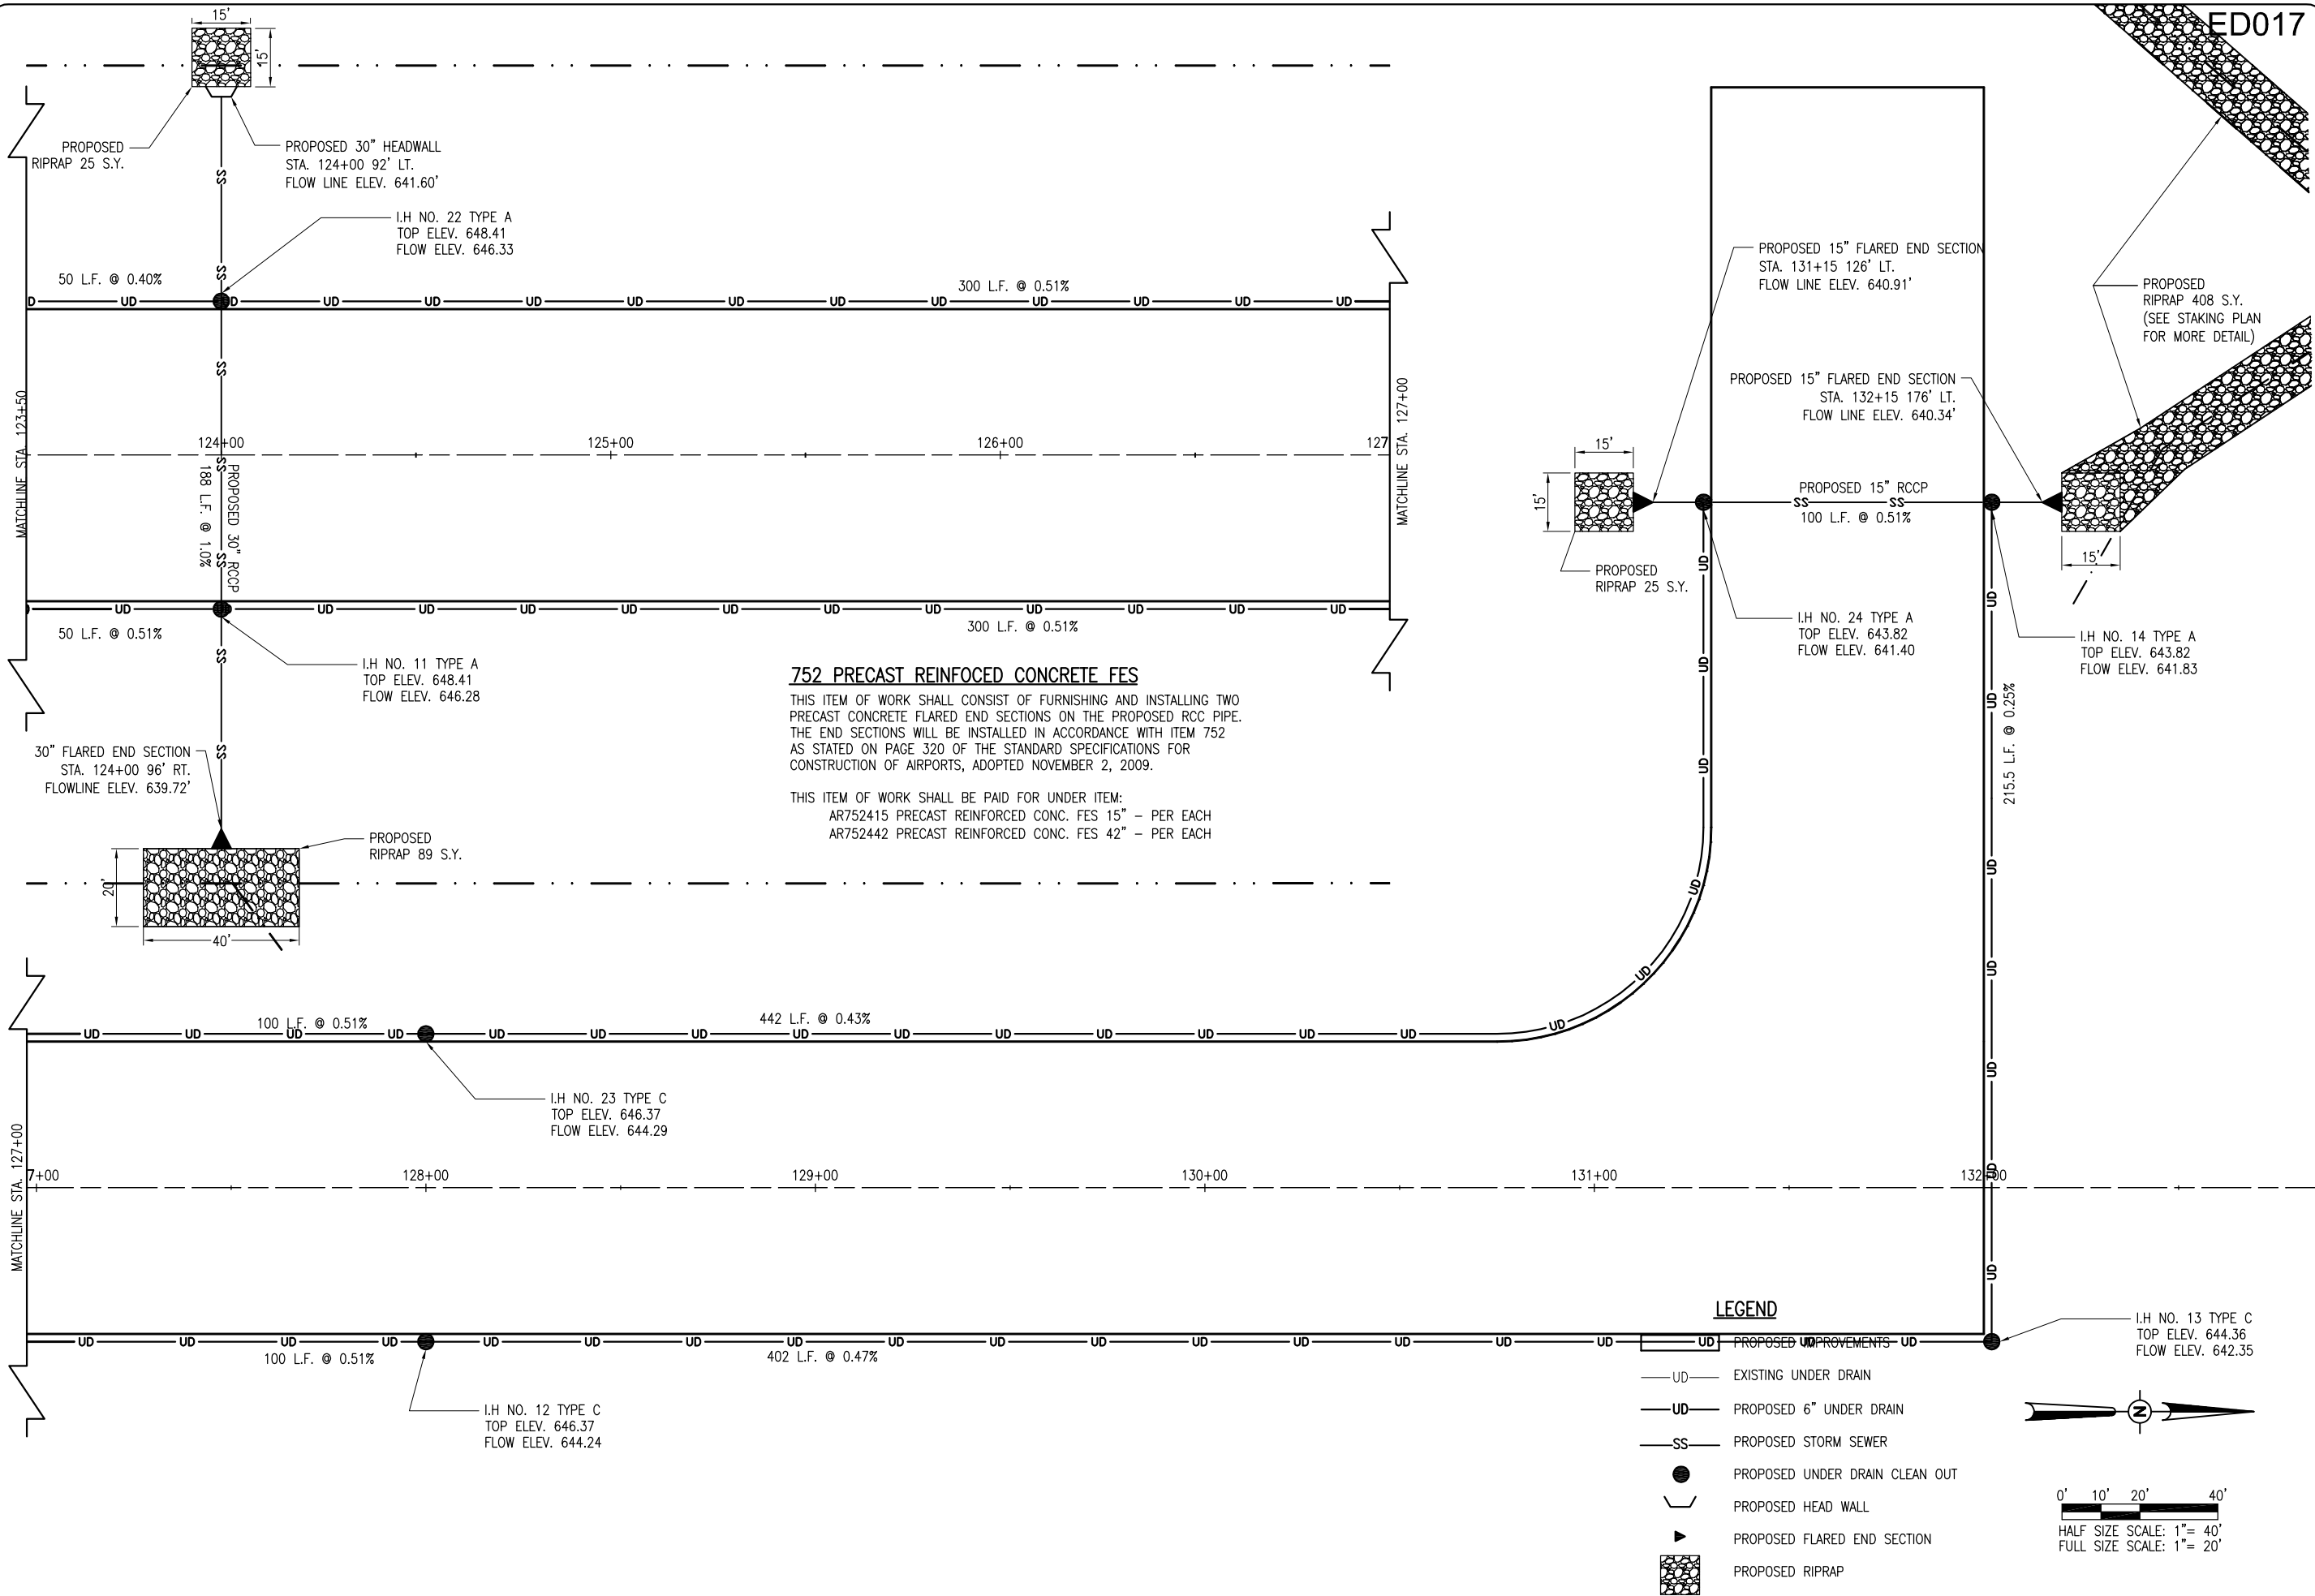


**752 PRECAST REINFORCED CONCRETE FES**

THIS ITEM OF WORK SHALL CONSIST OF FURNISHING AND INSTALLING TWO PRECAST CONCRETE FLARED END SECTIONS ON THE PROPOSED RCC PIPE. THE END SECTIONS WILL BE INSTALLED IN ACCORDANCE WITH ITEM 752 AS STATED ON PAGE 320 OF THE STANDARD SPECIFICATIONS FOR CONSTRUCTION OF AIRPORTS, ADOPTED NOVEMBER 2, 2009.

THIS ITEM OF WORK SHALL BE PAID FOR UNDER ITEM:  
 AR752415 PRECAST REINFORCED CONC. FES 15" - PER EACH  
 AR752442 PRECAST REINFORCED CONC. FES 42" - PER EACH

**LEGEND**

- UD — EXISTING UNDER DRAIN
- UD — PROPOSED 6" UNDER DRAIN
- SS — PROPOSED STORM SEWER
- PROPOSED UNDER DRAIN CLEAN OUT
- ⌋ PROPOSED HEAD WALL
- ▶ PROPOSED FLARED END SECTION
- ▨ PROPOSED RIPRAP

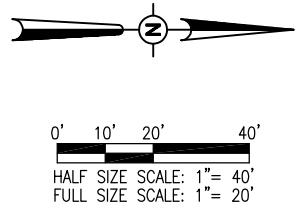

REVISION	DATE

EDGAR COUNTY AIRPORT  
 PARIS, ILLINOIS  
 A.I.P. PROJ.: 3-17-0077-B13  
 IL PROJ.: PRG-4018

Hanson Proj. No. 10A0053	BAK	01/10/11
Filename R=131DRN.L1.DWG	BAK	01/10/11
Scale NOT TO SCALE	xxx	xx/xx/xx
Date 03/10/11		

**HANSON**  
 Professional Services Inc. 2011  
 1525 South Sixth Street  
 Springfield, Illinois 62703-2886  
 www.hanson-inc.com  
 Offices Nationwide

CONSTRUCT CROSSWIND  
 RUNWAY 18-36  
 PROPOSED DRAINAGE PLAN  
 STA. 123+00 TO STA. 132+00